


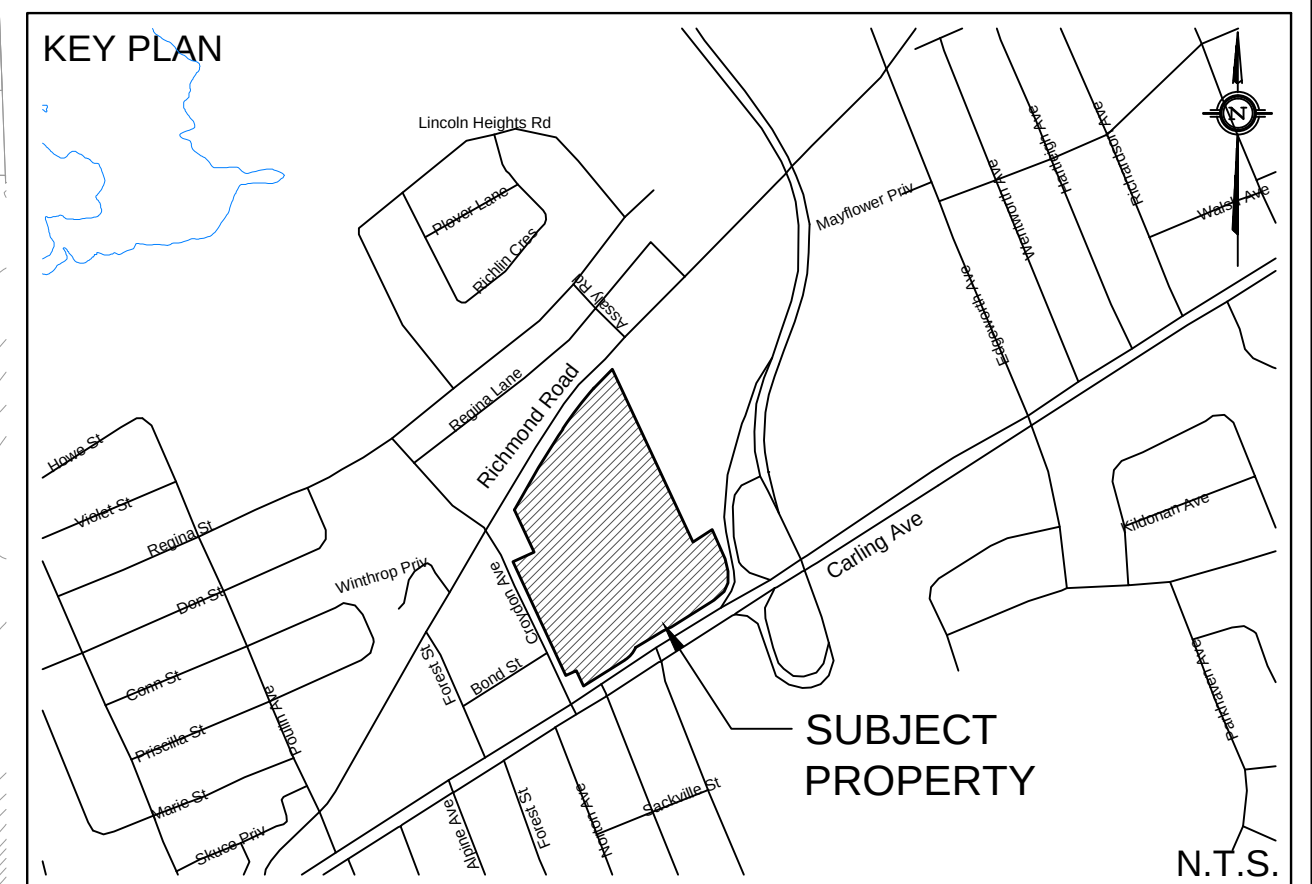

LEGEND

 EX6 4.010 0.19		PROPERTY LINE
		PROPOSED STORM SEWER
		DRAINAGE DIVIDE
		PROPOSED SWALE
		PROPOSED PERFORATED SUBDRAIN
		PROPOSED STORM MANHOLE
		PROPOSED CATCH BASIN
		PROPOSED CB "T"
		MAJOR SYSTEM FLOW ROUTE
		SURFACE PONDING AREA

MAX PONDING
INTERMEDIATE PONDING

NOT FOR CONSTRUCTION

TOPOGRAPHIC INFORMATION
TOPOGRAPHIC INFORMATION PROVIDED BY STANTEC GEOMATICS LTD
PROJ. NO. 161613668-111
DATED JANUARY 9, 2018


SITE PLAN INFORMATION
SITE PLAN PROVIDED BY RLA ARCHITECTURE
PROJ. NO. 1803
DATED DECEMBER 14, 2018

GEOTECHNICAL STUDY
GEOTECHNICAL RECOMMENDATIONS PROVIDED BY GOLDER ASSOCIATES LTD
PROJ. NO. 1780158-3000
DATED NOVEMBER 2018

SITE SERVICING AND STORMWATER MANAGEMENT STUDY
SERVICING AND STORMWATER MANAGEMENT RECOMMENDATIONS PROVIDED BY DSEL
PROJ. NO. 17-997
DATED DECEMBER 2018

BENCH MARK
FIRE HYDRANT TOP OF SPINDLE LOCATED ON CARLING AVE
ELEV=74.37m

1	B.N.C.	18.12.17	ISSUED FOR MUNICIPAL REVIEW
No.	BY	YY.MM.DD	DESCRIPTION

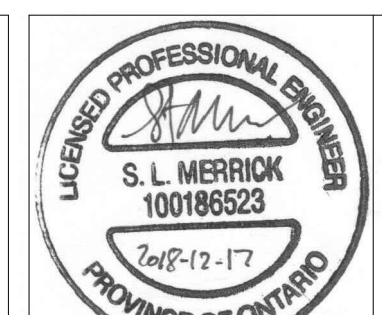

PROJECT No. 17-997

REVIEWED BY


STORMWATER MANAGEMENT PLAN
LINCOLN FIELDS

RioCAN

RioCan Yonge Eglinton Centre
2300 Yonge Street, Suite 500
Toronto, Ontario, M4P 1E4



DRAWN BY: B.N.C.			CHECKED BY: S.L.M	DRAWING NO.	SHEET NO.
DESIGNED BY: B.N.C.			CHECKED BY: S.L.M	SWM-1	1 of 1
SCALE: 1: 750		DATE: DECEMBER 2018			

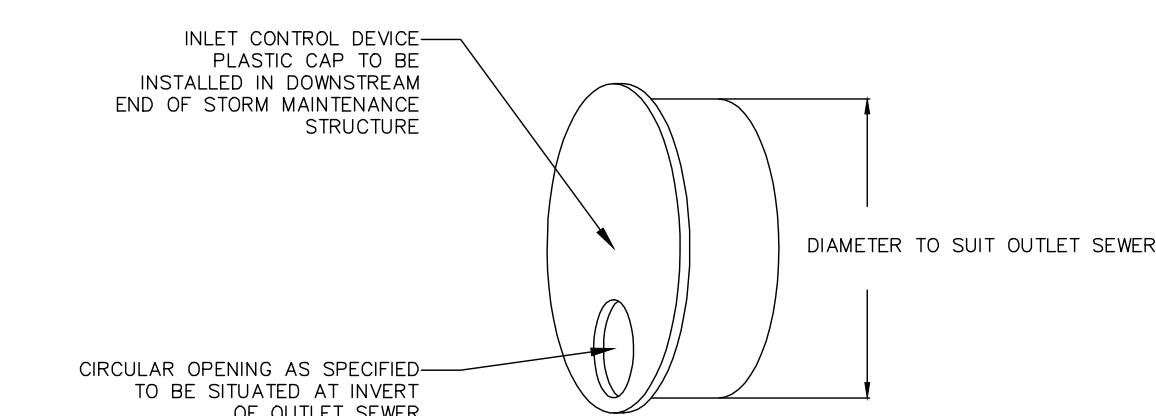

NOT TO SCALE