
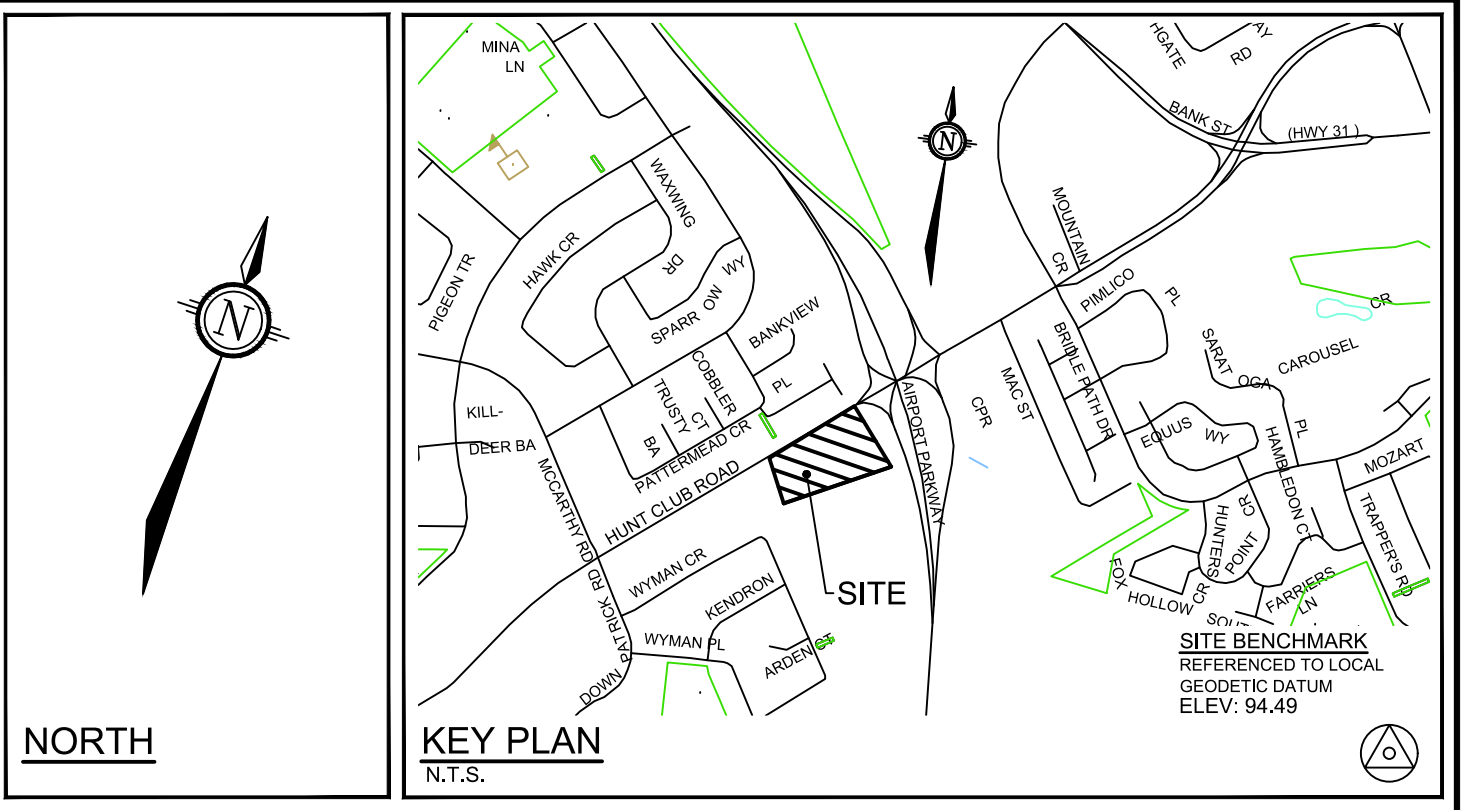


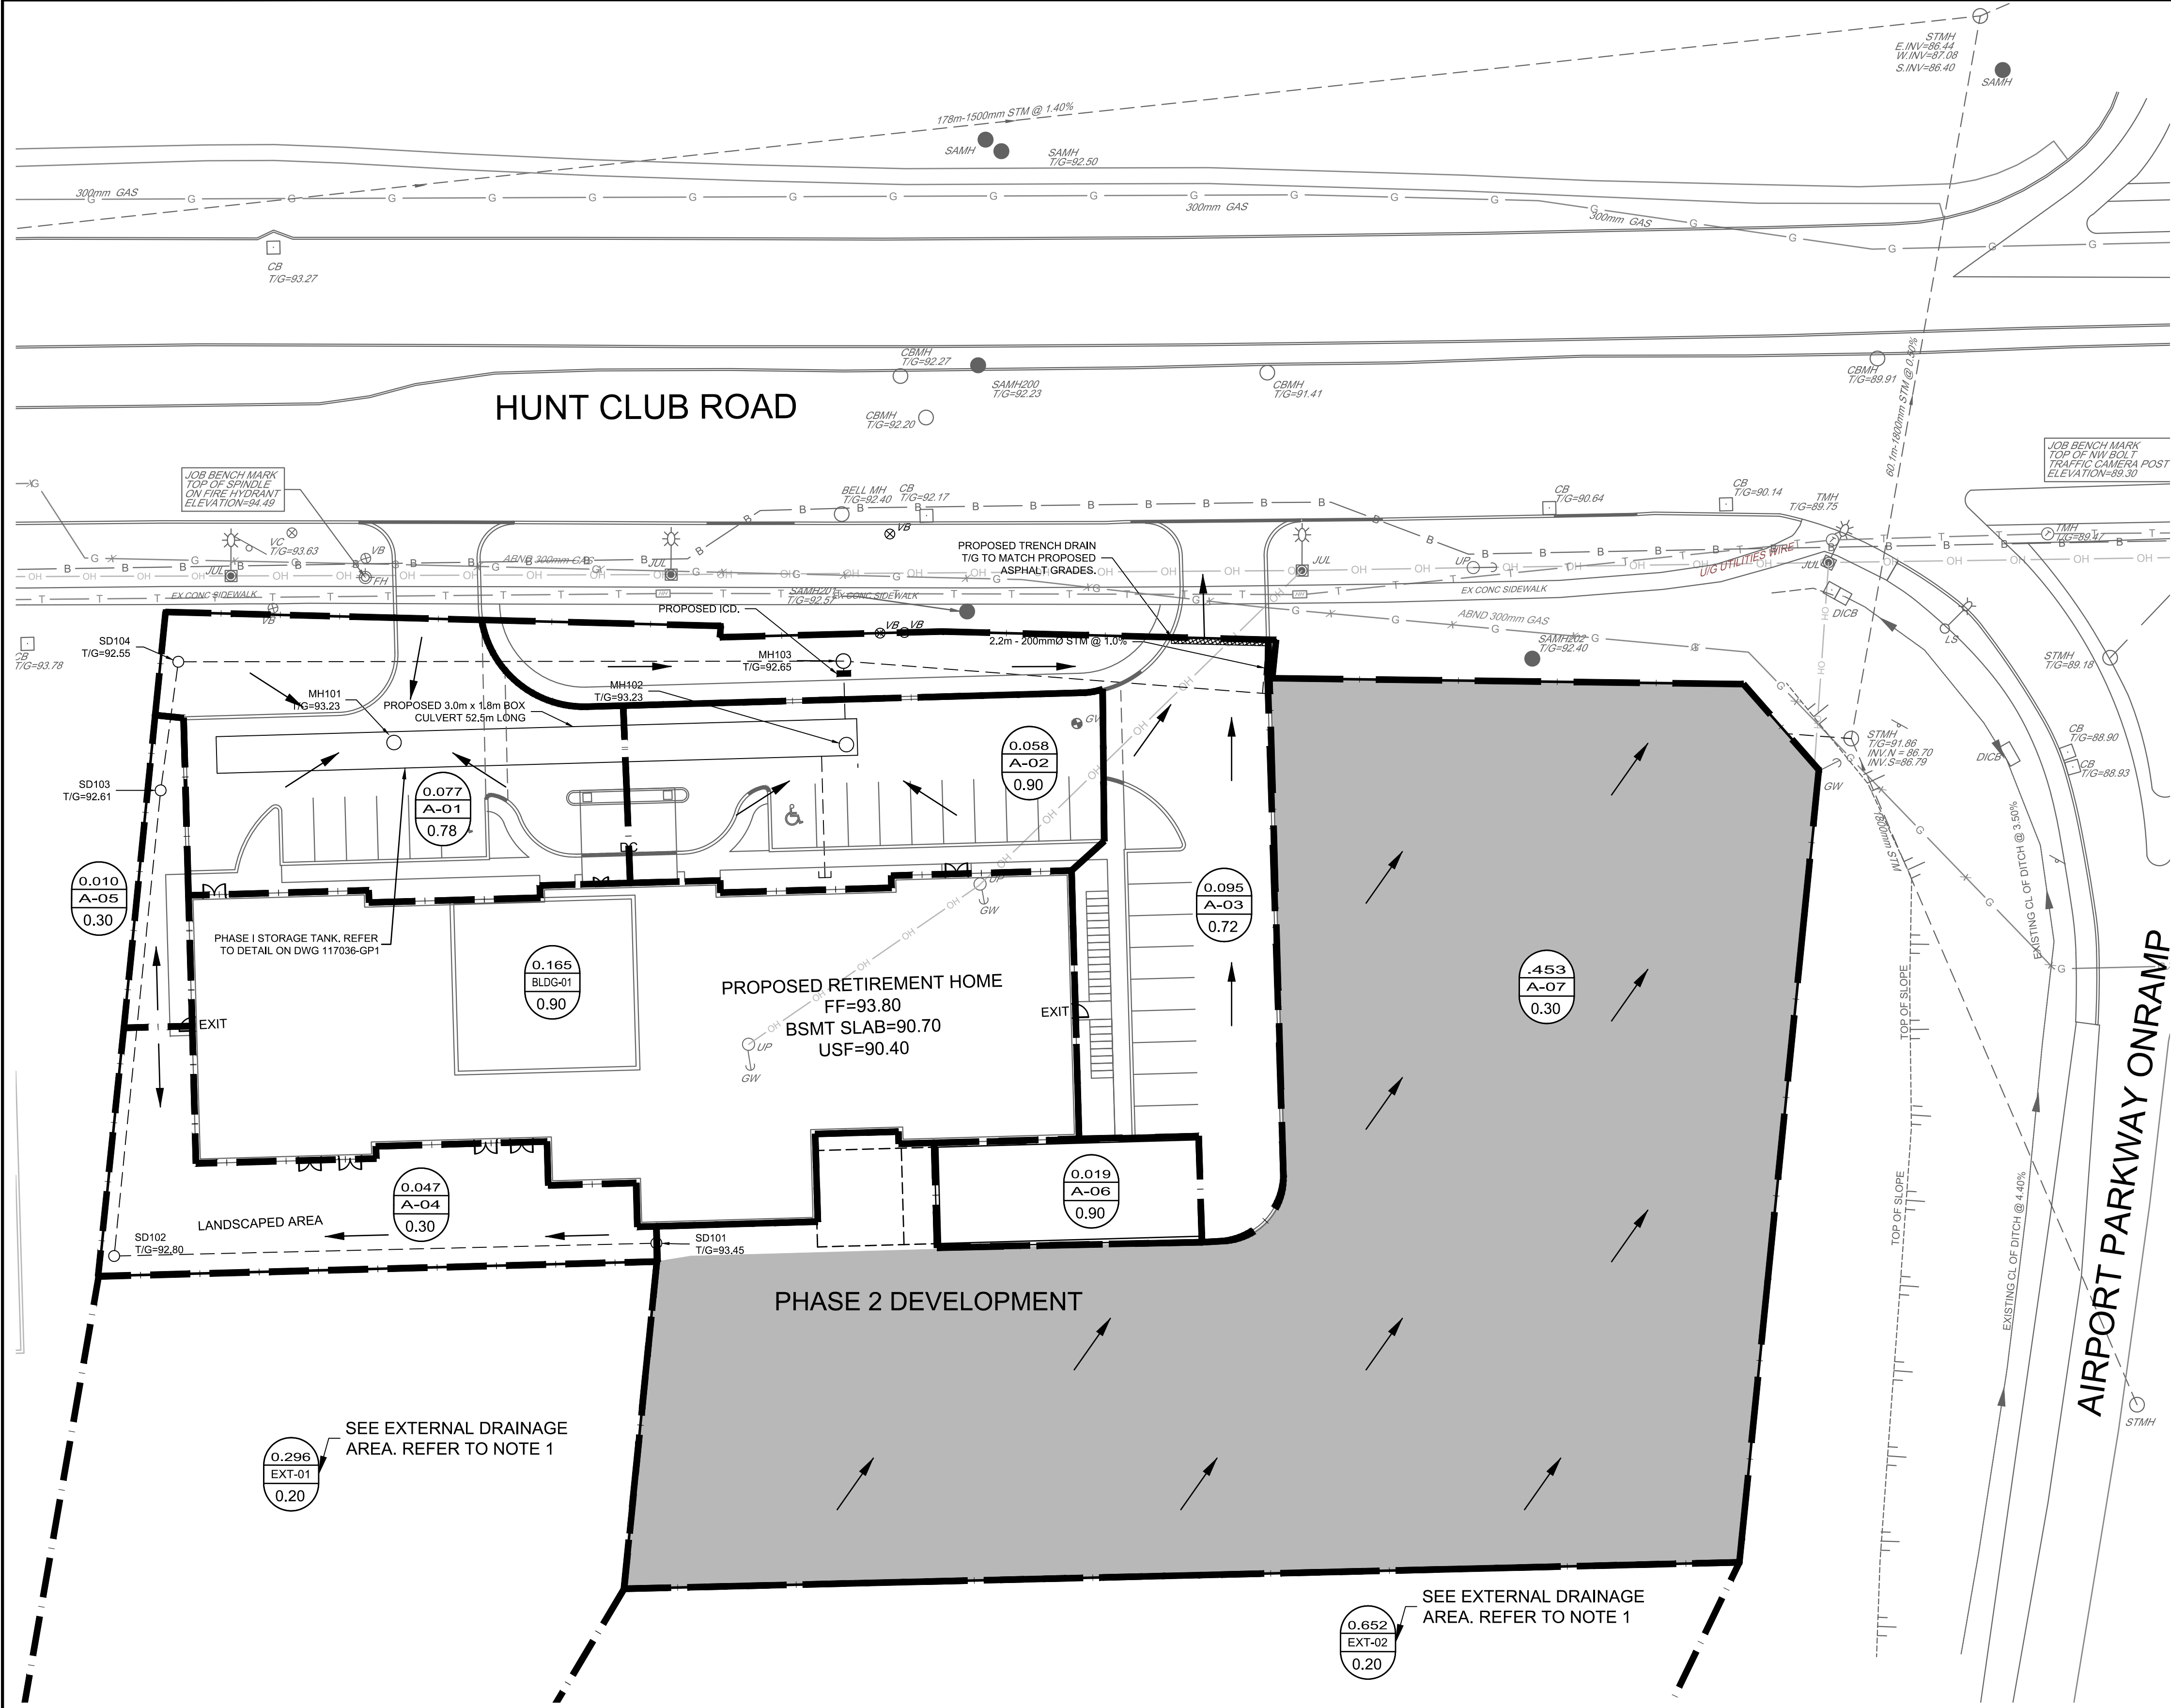

- LEGEND**
- .453 DRAINAGE AREA (hectares)
 - A-07 AREA ID
 - 0.30 RUN-OFF COEFFICIENT
 - STORM DRAINAGE AREA
 - MH 100
 - DIRECTION OF OVERLAND FLOW

STORM ICD TABLE					
STR. NO	T/G ELEVATION	INVERT IN	ICD MODEL/SIZE*	100-YR HEAD (m)	RELEASE RATE (L/s)
MH103	92.65	90.75	TBD	1.39	2.4

*ICD SIZE TO BE DETERMINED AT DETAILED DESIGN STAGE

NOTE:
THE POSITION OF ALL POLE LINES, CONDUITS, WATERMANS, SEWERS AND OTHER UNDERGROUND AND OVERGROUND UTILITIES AND STRUCTURES IS NOT NECESSARILY SHOWN ON THE CONTRACT DRAWINGS, AND WHERE SHOWN, THE ACCURACY OF THE POSITION OF SUCH UTILITIES AND STRUCTURES IS NOT GUARANTEED. BEFORE STARTING WORK, DETERMINE THE EXACT LOCATION OF ALL SUCH UTILITIES AND STRUCTURES AND ASSUME ALL LIABILITY FOR DAMAGE TO THEM.



No.	REVISION	DATE	BY
1.	ISSUED FOR SITE PLAN APPLICATION	MAY 25/17	GJM

SCALE
1:300
0 3 6 9 12

DESIGN
MTL
GJM
MTL
GJM
GJM

FOR REVIEW ONLY

PROFESSIONAL ENGINEER
G.J. McDONALD
PROVINCE OF ONTARIO

NOVATECH
Engineers, Planners & Landscape Architects
Suite 200, 240 Michael Cowpland Drive
Ottawa, Ontario, Canada K2M 1P6
Telephone (613) 254-9643
Facsimile (613) 254-5867
Website www.novatech-eng.com

LOCATION CITY OF OTTAWA HUNT CLUB DEVELOPMENT	
DRAWING NAME	PROJECT No. 117036-00
STORM AREA DRAINAGE PLAN PHASE 1	REV REV # 1
	DRAWING No. 117036-STM1

M:\2017\117036\CAD\Design\117036_STM1.dwg, STM1, May 25, 2017, 11:45am, milton

PLAN A1, DWG - 841mm x 1189mm