


**LEGEND**

 DRAINAGE AREA	 AREA SIZE (sq.m.)
 RUNOFF COEFFICIENT	

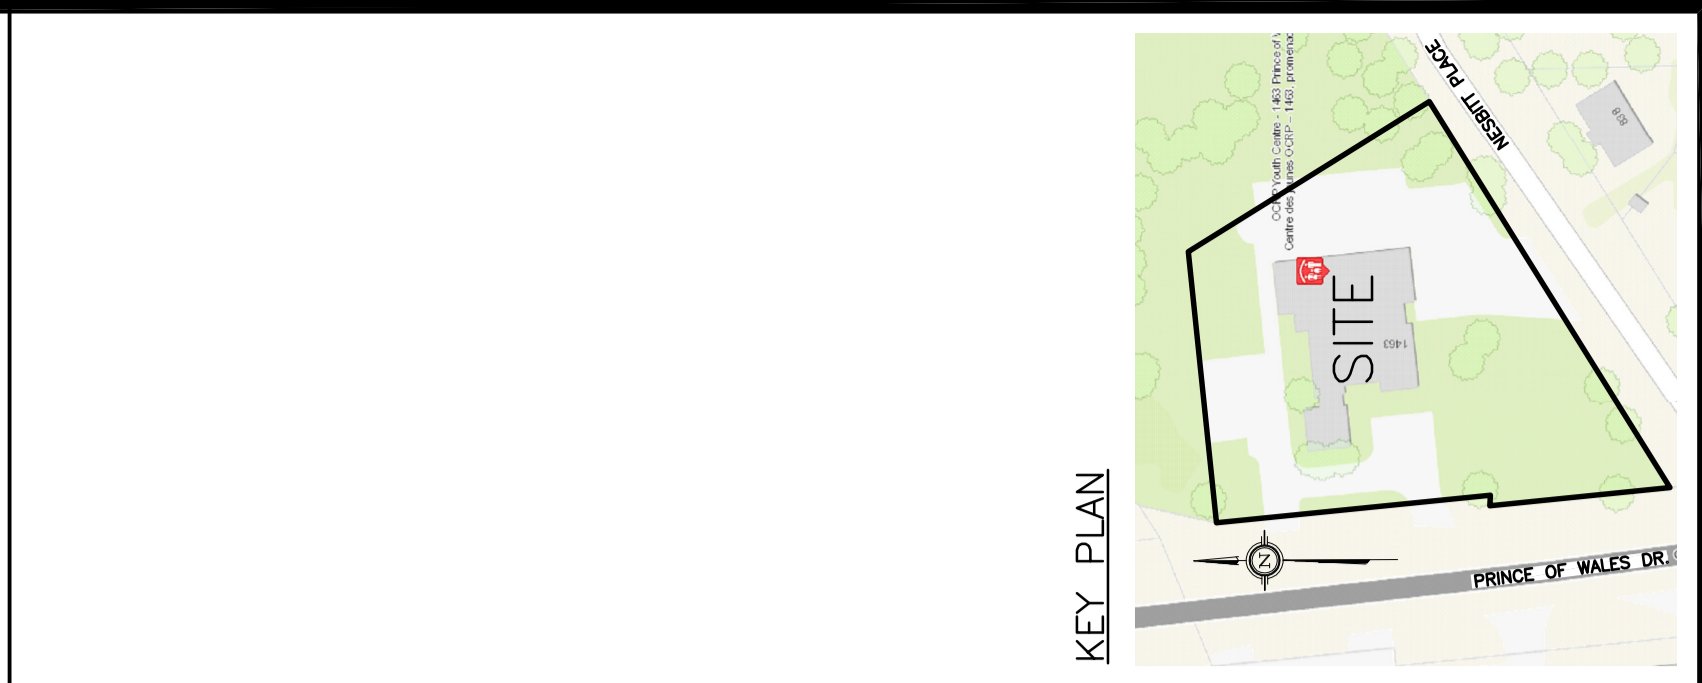

No.	Date	REVISION
2	JUN 6-17	ISSUED FOR APPROVAL
1	MAY 12-17	ISSUED FOR REVIEW AND COORDINATION

**D. B. GRAY ENGINEERING INC.**  
 Stormwater Management, Grading & Pavement, Storm & Sanitary Sewers, Drainage  
 700 Long Point Circle  
 Ottawa, Ontario K1T 4E9  
 Tel: 613-425-8044  
 dgray@dbgray.com


**PROPOSED  
 BOYS AND GIRLS  
 RENOVATION  
 1463 PRINCE OF WALES DR  
 OTTAWA, ONTARIO**

**DRAINAGE PLAN**

Engineer's Seal  
  
 D.B. GRAY  
 17016502  
 JUN 8-19  
 PROFESSIONAL ENGINEER  
 CIVIL  
 PROVINCE OF ONTARIO  
 NOT VALID UNLESS  
 SIGNED & DATED  
 Drawing No. **C-4** of **4**

REFER TO NOTES &  
 DETAILS ON DRAWING C-3

P.I.N. 04076 - 0013

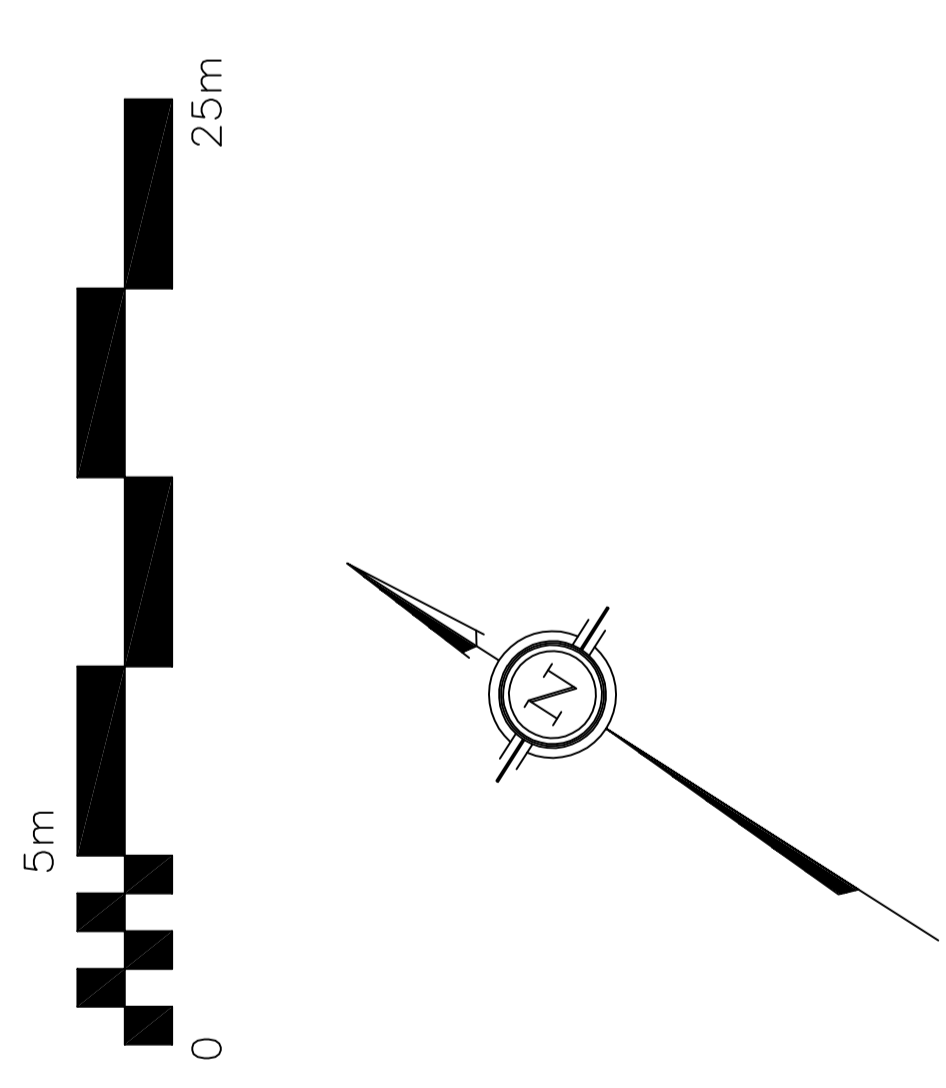

AS WIDENED BY INST. N40749 (P-1591)  
 0 2 7 3

PART 1 PLAN 4R-16329  
 SUBJECT TO EASEMENT INST. NO. 00113777

Approximate Crown of Road