


PART 2 PLAN 5R-4307
PIN 04076 - 0001



LEGEND	
DRAINAGE AREA	AREA SIZE (sq.m.)
I	697
0.27	5-YEAR RUNOFF COEFFICIENT

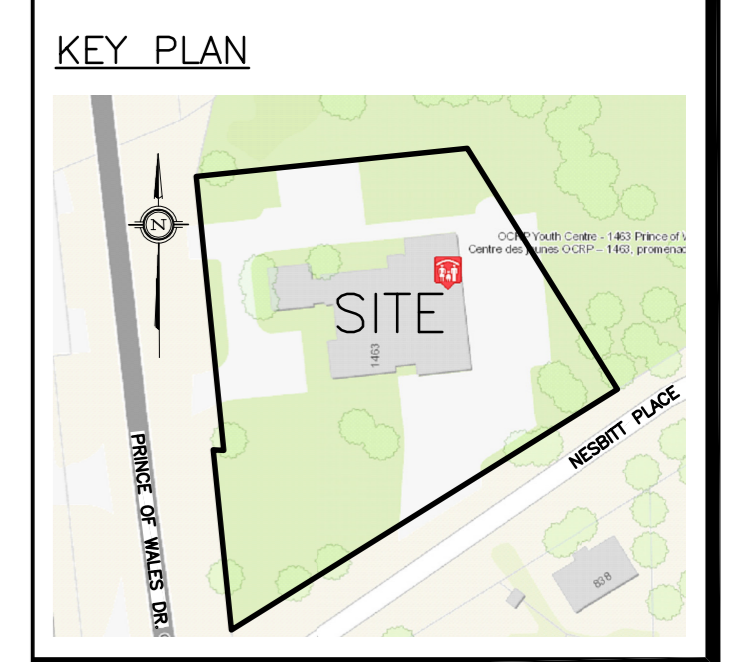


No.	Date	REVISION
3	OCT 18-17	RE-ISSUED FOR APPROVAL
2	JUN 6-17	ISSUED FOR APPROVAL
1	MAY 12-17	ISSUED FOR REVIEW AND COORDINATION

D. B. GRAY ENGINEERING INC.
Stormwater Management - Grading & Drainage - Storm & Sanitary Sewers - Watermain
700 Long Point Circle Tel: 613-425-8044
Ottawa, Ontario K1T 4E9 dbgray@rogers.com

Project **PROPOSED BOYS AND GIRLS RENOVATION**
1463 PRINCE OF WALES DR
OTTAWA, ONTARIO

Drawing Title
DRAINAGE PLAN

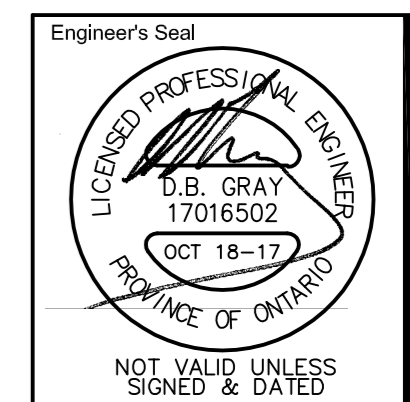

Engineer's Seal
Drawn D.B.G.
Hor. Scale 1:200
Vert. Scale
Date MAR 31-17
Job 16087

Drawing No.
C-4 of 4

REFER TO NOTES & DETAILS ON DRAWING C-3