


APPROVED ☐ REFUSED ☐

THIS ____ DAY OF _____, 20__

DON HERWEYER, MCIP, RPP, MANAGER
DEVELOPMENT REVIEW SOUTH PLANNING,
INFRASTRUCTURE AND ECONOMIC DEVELOPMENT
DEPARTMENT, CITY OF OTTAWA

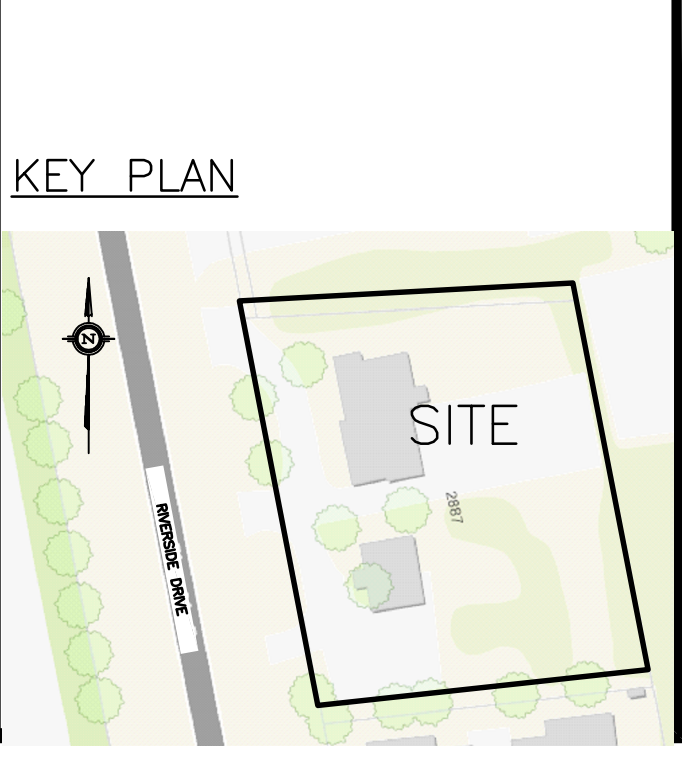

No.	Date	REVISION
4	DEC 21-17	RE-ISSUED FOR APPROVAL
3	SEP 8-17	RE-ISSUED FOR APPROVAL
2	JUN 9-17	ISSUED FOR SITE PLAN CONTROL, ZONING
1	JUN 7-17	ISSUED FOR REVIEW & COORDINATION

D. B. GRAY ENGINEERING INC.

Stormwater Management - Grading & Drainage - Storm & Sanitary Sewers - Watermain

700 Long Point Circle
Ottawa, Ontario K1T 4E9

Tel: 613-425-8044
dgray@rogers.com

Project

PROPOSED

YOUTH SERVICES BUREAU (YSB)

2887 RIVERSIDE DR.

OTTAWA, ONTARIO

DRAINAGE PLAN & NOTES

Engineer's Seal

Drawn D.B.G.
Hor. Scale 1:200
Vert. Scale
Date MAY 25-17
Job 15051

Drawing No. C-3 of 3

D07-12-17-0075