


LEGEND

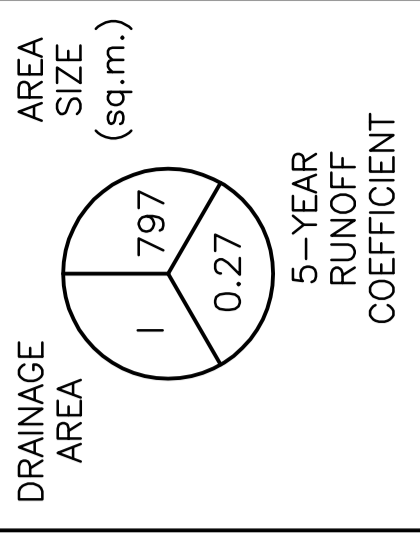

APPROVED REFUSED

THIS _____ DAY OF _____ 20____

Douglas James, MPEP, RPP
MANAGER, DEVELOPMENT REVIEW CENTRAL
PLANNING, INFRASTRUCTURE AND ECONOMIC
DEVELOPMENT DEPARTMENT, CITY OF OTTAWA

KEY PLAN




No.	Date	REVISION
4	FEB 14-18	SIGNATURE BLOCK REVISED RE-ISSUED FOR APPROVAL
3	FEB 5-18	RE-ISSUED FOR APPROVAL
2	NOV 1-17	RE-ISSUED FOR APPROVAL
1	JUL 4-17	ISSUED FOR APPROVAL

D. B. GRAY ENGINEERING INC.
Stormwater Management - Grading & Pavement - Storm & Sanitary Sewers - Retention
 700 Long Point Circle
 Ottawa, Ontario K1T 4E9
 Tel: 613-425-8044
 dgray@grayeng.com


Project
THE PULLMAN
 515-511-509
 GLADSTONE AVE.
 OTTAWA, ONTARIO

Drawing Title
DRAINAGE PLAN

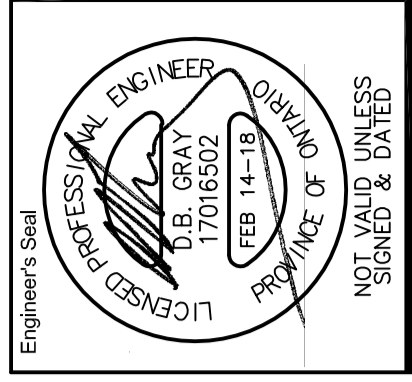

Drawing No.
C-4
 of **4**

007-12-17-0094

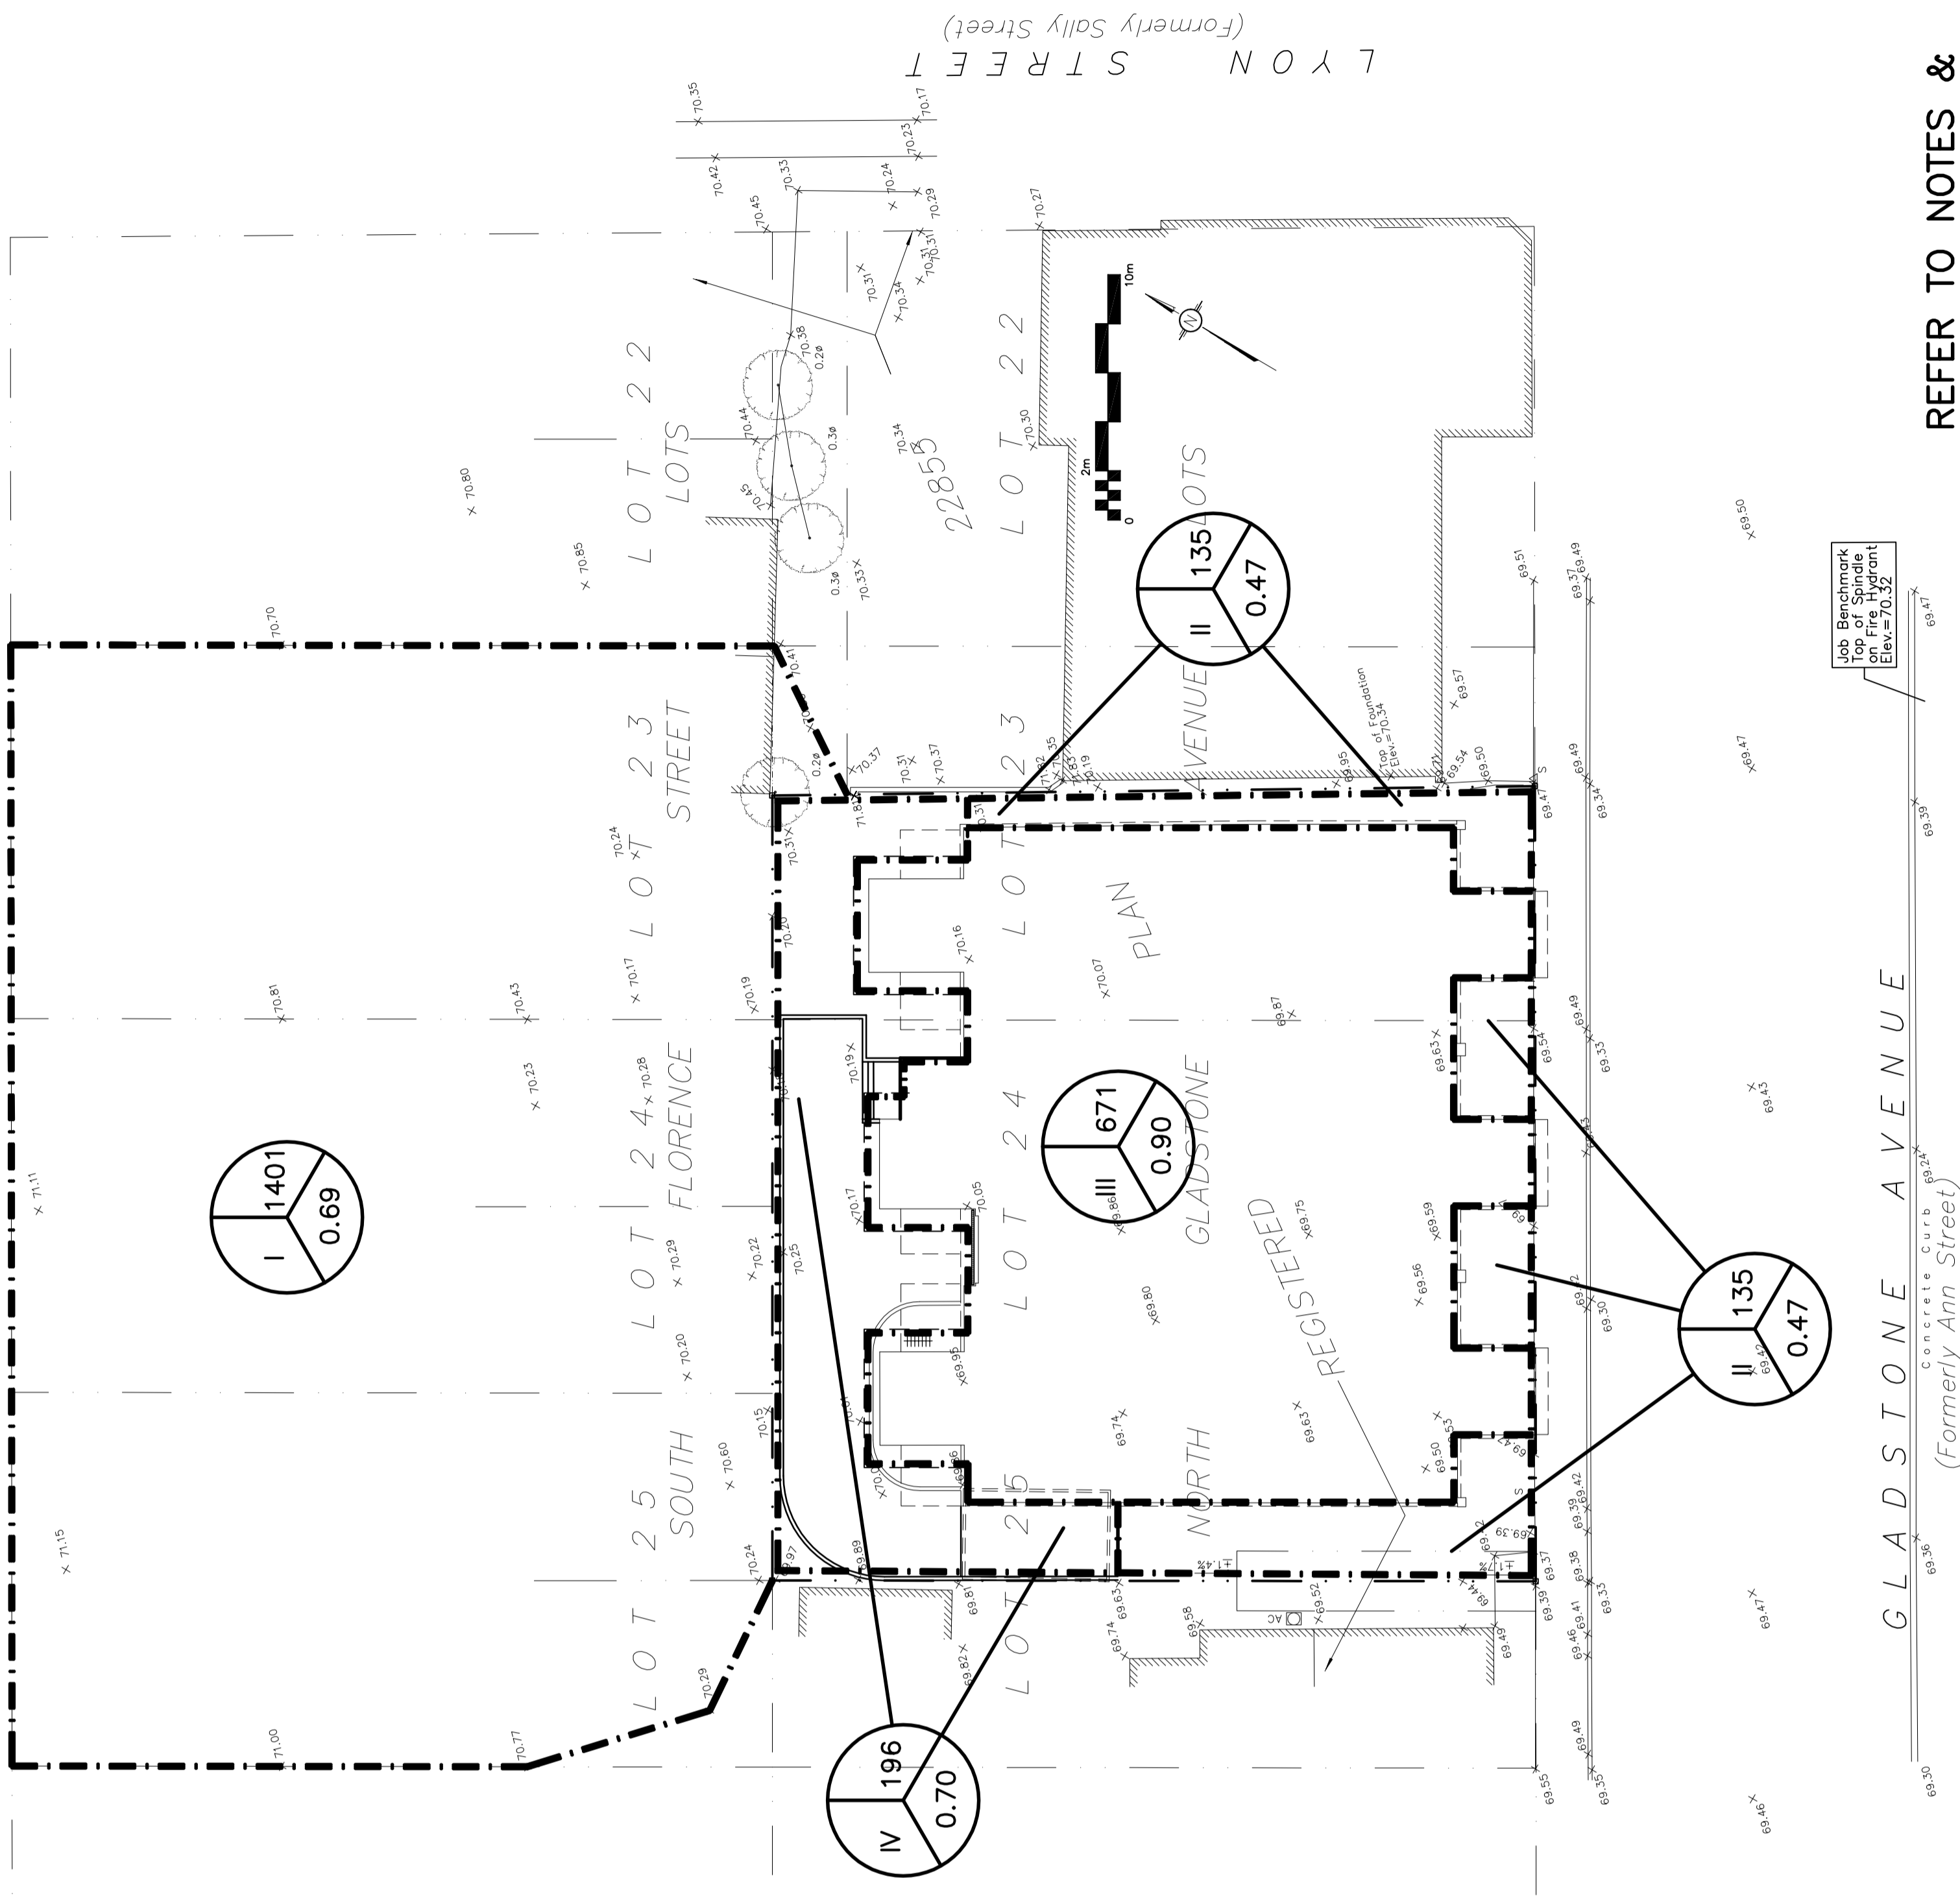

REFER TO NOTES &
 DETAILS ON DRAWING C-3