



DATE	REVISION	REF
18.02.06	RE-ISSUED FOR SITE PLAN WITH LIGHT FIXTURE REVISION	2
18.01.08	RE-ISSUED FOR SITE PLAN CONTROL APPLICATION	1
17.07.20	ISSUED FOR SITE PLAN	0

THE ENGINEER WAIVES ANY AND ALL RESPONSIBILITY AND LIABILITY FOR PROBLEMS WHICH ARISE FROM FAILURE TO FOLLOW THESE PLANS, SPECIFICATIONS AND THE DESIGN INTENT THEY CONVEY, OR FOR PROBLEMS WHICH ARISE FROM OTHER FAILURE TO OBTAIN AND / OR FOLLOW THE ENGINEER'S GUIDANCE WITH RESPECT TO ANY ERRORS, OMISSIONS, INCONSISTENCIES, AMBIGUITIES OR CONFLICTS WHICH ARE ALLEGED.

THIS DRAWING IS THE PROPERTY OF GOODKEY WEEDMARK & ASSOCIATES LIMITED AND ALL COPYRIGHTS ARE RESERVED. NO USE OF THIS DRAWING MAY BE MADE WITHOUT EXPRESS WRITTEN CONSENT.

DO NOT SCALE DRAWINGS.

L'INGÉNIEUR DÉCLINE TOUTE RESPONSABILITÉ DÉCOULANT DE PROBLÈMES FAISANT SUITE AU NON RESPECT DES PLANS, DES DÉTAILS ET DE L'INTENTION DU CONCEPT QU'ILS INDIQUENT OU DE TOUTS LES PROBLÈMES POUVANT RÉSULTER DU DÉFAUT D'OBTENIR ET / OU DE SUIVRE LES CONSEILS DE L'INGÉNIEUR EN CE QUI CONCERNE LES ERREURS, OMISSIONS, INCONSISTANCES, AMBIGUITÉS OU CONFLITS ALLEGUÉS.

CE DESSIN EST LA PROPRIÉTÉ LITTÉRAIRE DE GOODKEY WEEDMARK & ASSOCIATES LIMITED ET TOUTS LES DROITS SONT RÉSERVÉS. L'UTILISATION EST INTERDITE SANS LE CONSENTEMENT ÉCRIT DE L'AUTEUR.

NE PAS MESURER LES DESSINS À L'ÉCHELLE.

Goodkey Weedmark
Consulting Engineers

GOODKEY WEEDMARK & ASSOCIATES LIMITED
1688 Woodward Dr. Ottawa Ontario Canada K2C 3R8
613 727-5111 613 727-5115
Voice Fax
www.gwal.com Web

Project north
Nord du projet


Seal/Scelo

Project/Projet

890-900 BANK STREET REDEVELOPMENT

Drawing title/Titre du dessin
ELECTRICAL SITE PLAN

Scale Échelle	AS NOTED	Project no./No. du projet	2017-377
Design by Conçu par	H.MASROOR	Drawing/Desin	
Drawn by Dessiné par	H.MASROOR	E1	OF 1
Reviewed by Examiné par	D.VVAS		
Date	JANUARY 2018	Revision no.	0
Date		Acad file/Fichier:	Z:\2017-377\ELEC

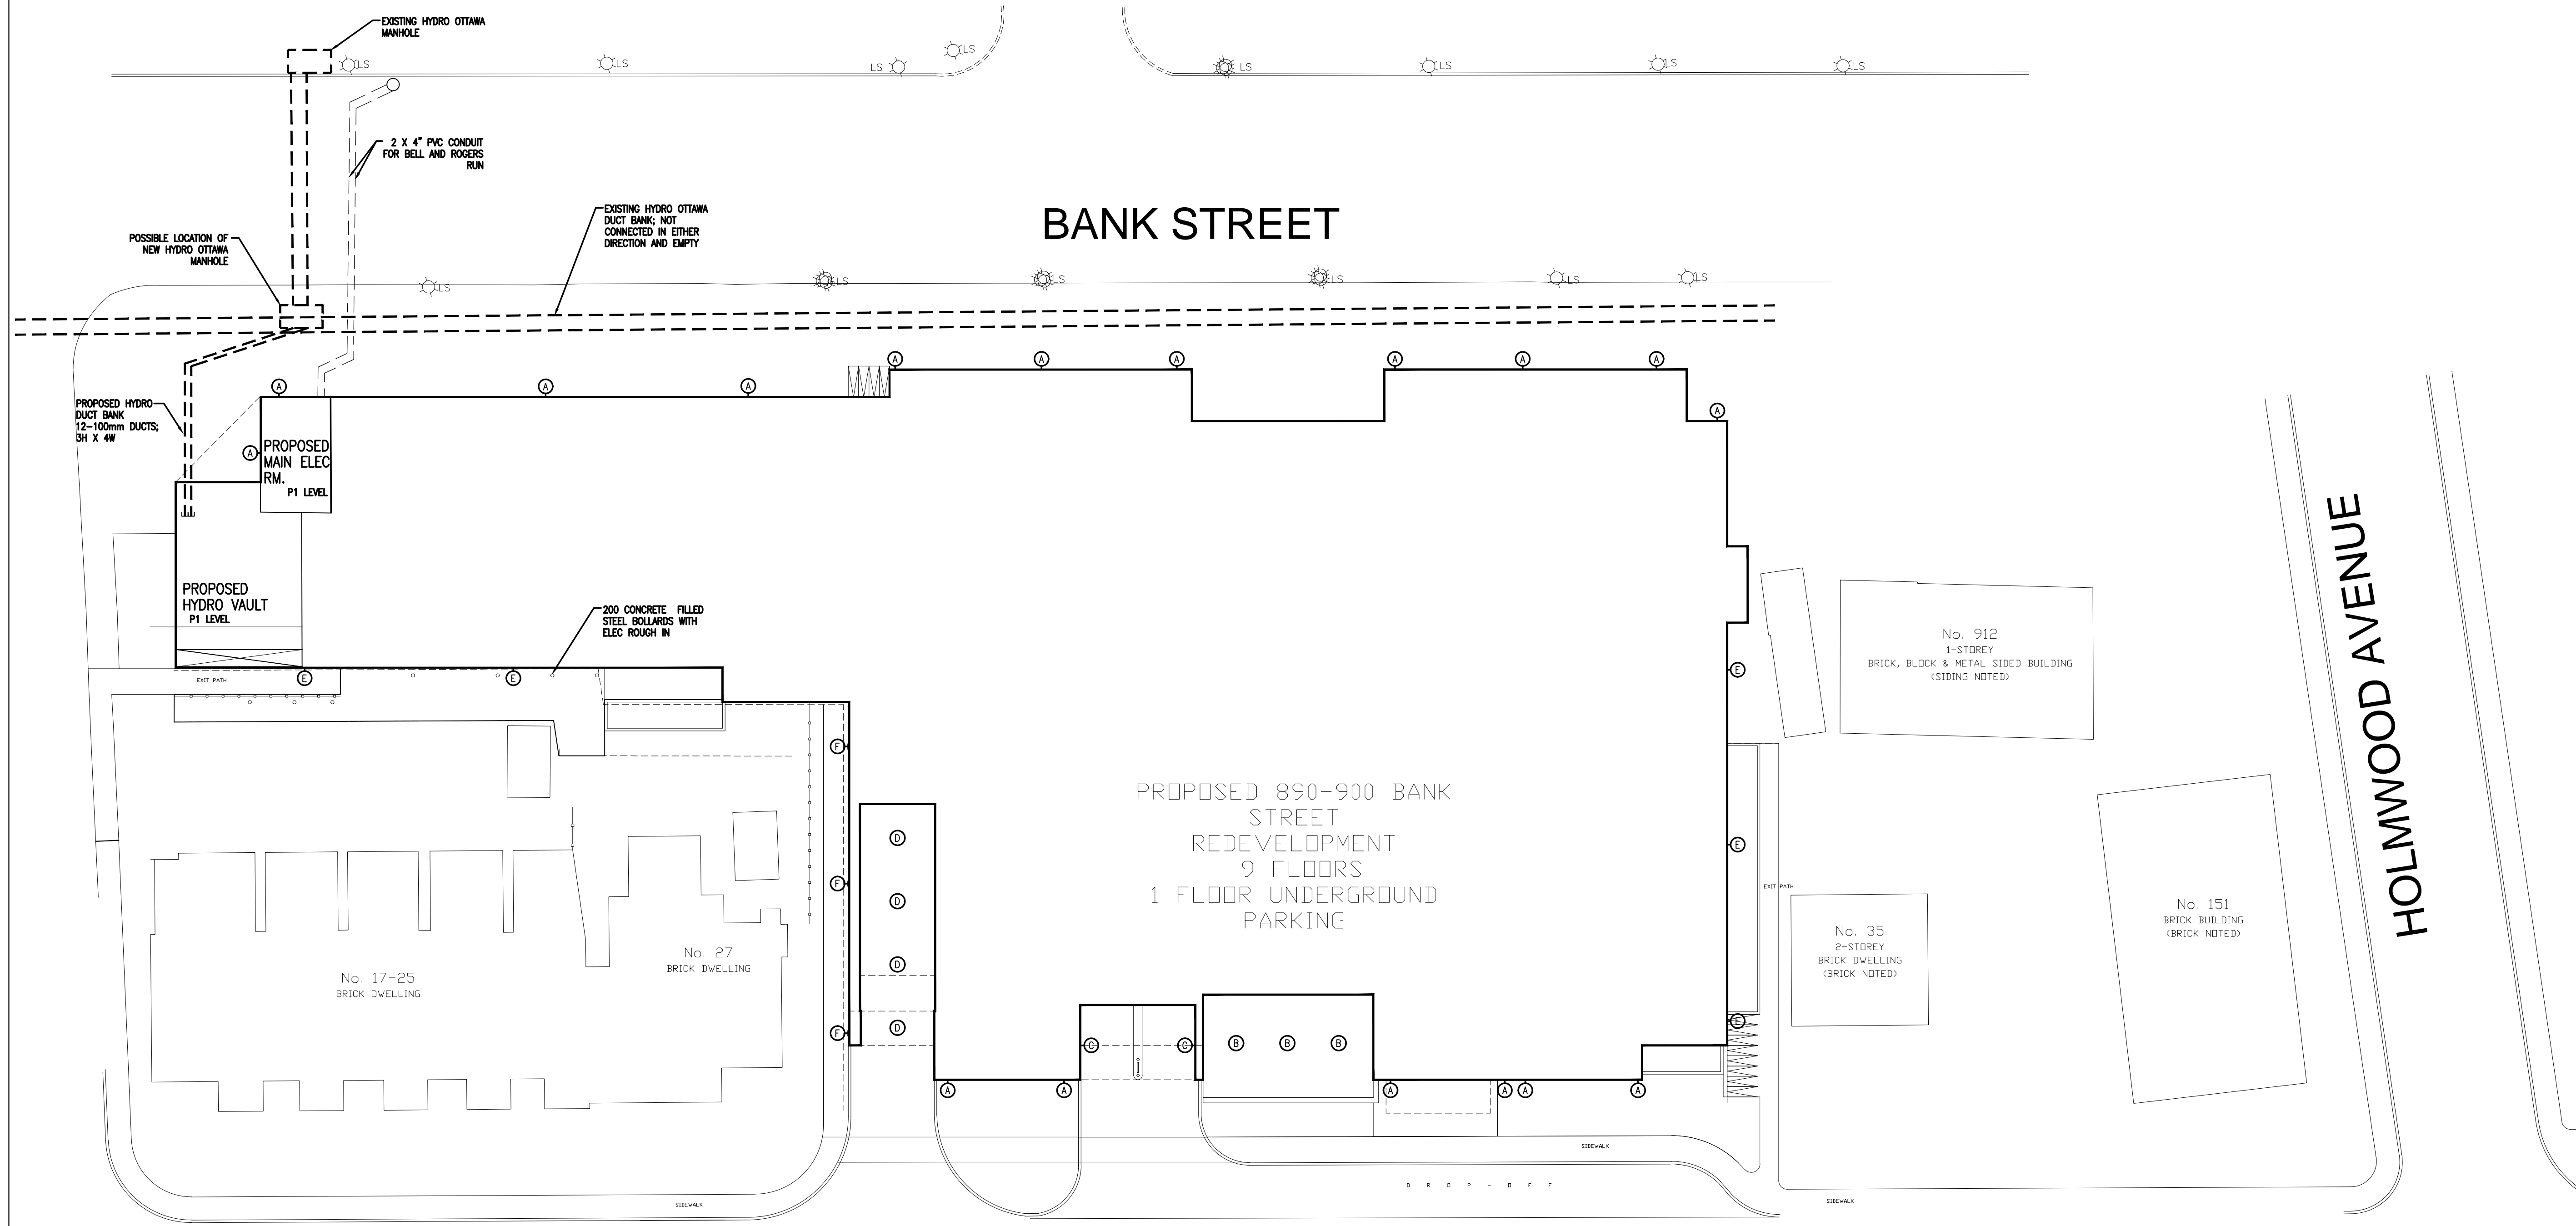

MONK STREET

1
E1
1:200
ELECTRICAL SITE PLAN

LIGHTING FIXTURE SCHEDULE							
TYPE	DESCRIPTION	CATALOG NUMBER	LAMPS PER FIXTURE			MOUNTING	REMARKS
			TYPE	WATTS	COLOUR		
A	WALL CYLINDER	LUMIERE-LANTERRA 9004-W2-RW-LED4080-S/M-BK-L1/L2	LED	10/20W	4000K	120	UP DOWN LIGHT, MATTE BLACK FINISH
B	DOWN LIGHT	HALO COMMERCIAL PD6-ED010-PDM6A-840-61V-H	LED	89LPW	4000K	120	RECESSED
C	WALL PACK	LUMARK XTOR29-W-BK-PC1	LED	18W	4000	120	WALL
D	SURFACE DOWNLIGHT	HALO COMMERCIAL PRBS-30-DO10-MB-PRBM34-MB	LED	118LPW	4000	120	DOWNLIGHT
E	WALL MOUNT	IMPACT ELITE LED IST TRAPEZOID IST - F02 - LED - E1 - BL3 - DP	LED	50W	4000	120	WALL
F	WALL CYLINDER	LUMIERE - LANTERRA 9004-W1-RW-LED4080-M-BK-L2	LED	20W	4000K	120	DOWN LIGHT, MATTE BLACK FINISH

NOTE:
LIGHT FIXTURES EQUAL IN PHOTOMETRICS, LUMEN OUTPUT AND AESTHETICS ARE ACCEPTABLE

GENERAL NOTES:

- PROVIDE PVC/EMT TRANSITION SLEEVES BETWEEN EXTERIOR CONDUITS AND INTERIOR CONDUITS.
- ALL EXTERIOR LIGHT FIXTURES ARE CONTROLLED BY PHOTOCELL MOUNTED ON EXTERIOR WALL AT APPROPRIATE LOCATION.