

MONTFORD HOSPITAL
ORLEANS FAMILY
HEALTH HUB


LEGEND

	PROPERTY LINE		BERM
	CONCRETE PAVING W/ BROOM FINISH		BIKE RACKS
	TINTED CONCRETE PAVING W/ BROOM FINISH		WOOD SCREEN
	WOOD DECK		EMERGENCY CALL SYSTEM
	DETECTABLE WARNING STRIP		LIGHT STANDARD
	DECIDUOUS TREE 80mm CAL.		BOLLARD LIGHT
	CONIFEROUS TREE TYPE ONE 1800mm HT.		DOWN LIGHT
	LAWN - SOD		UPLIGHT
	SEEDED MEADOW NATIVE SEED MIX		ELECTRICAL OUTLET
	PLANTER CURB		LIGHT COLUMN
	RAISED TIMBER PLANTER		MANHOLE
	TIMBER PERGOLA		CATCH BASIN
	SHADE STRUCTURE		VALVE BOX
	FLAG POLE		FIRE HYDRANT
	ORNAMENTAL METAL FENCE 1200HT		WATER MAIN
	BOLLARD		STORM SEWER
	PEAGRAVEL		SANITARY SEWER

PRELIMINARY
NOT FOR CONSTRUCTION

MARK	DATE	DESCRIPTION
1.	17-06-16	ISSUED FOR REVIEW
2.	17-09-21	ISSUED FOR REVIEW
3.	17-11-10	MOULTC STAGE 3/2 SKETCH PLAN
4.	18-02-16	ISSUED FOR 50% PEER REVIEW
5.	18-02-23	ISSUED FOR PEER REVIEW
6.	18-03-21	ISSUED FOR REVIEW
7.	18-04-03	ISSUED FOR REVIEW

Project Number 1707
Original Issue
Scale: 1:500

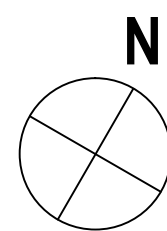

Sheet Name


LANDSCAPE UTILITY PLAN

Sheet Number

L101

Project Status

SITE PLAN APPROVAL

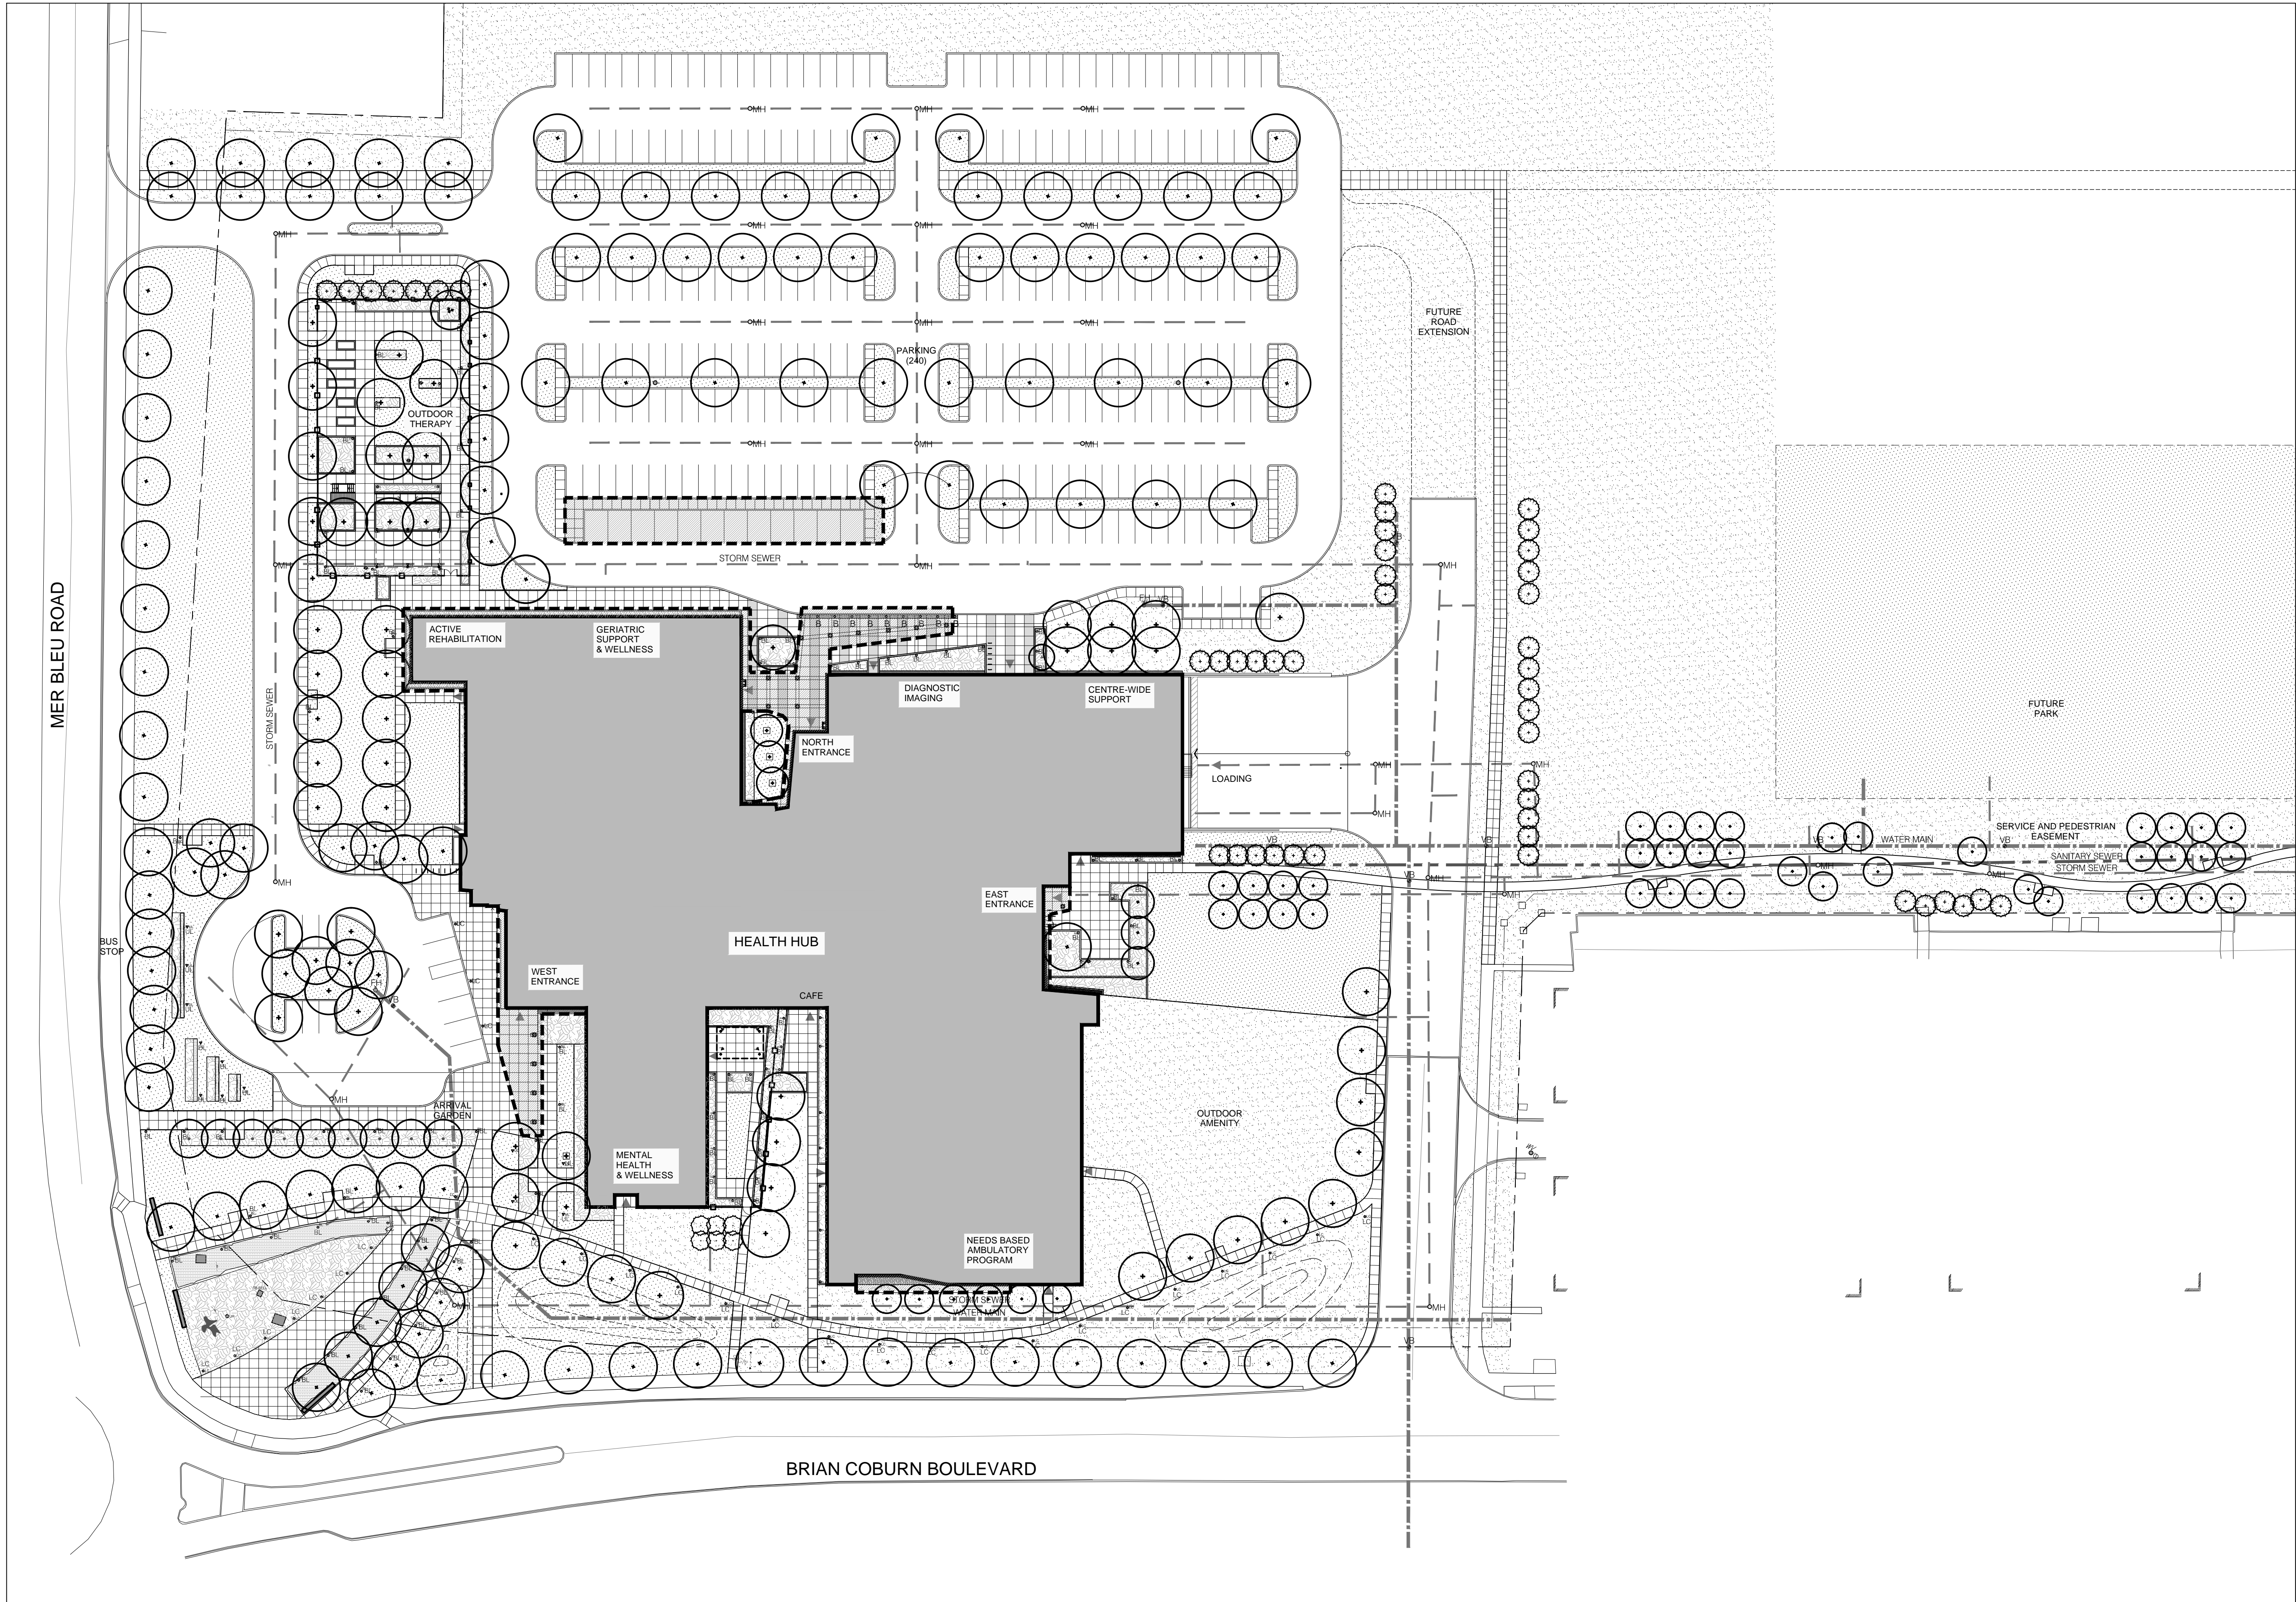

L1 LANDSCAPE UTILITY PLAN
L101 PLAN

SCALE 1:500