


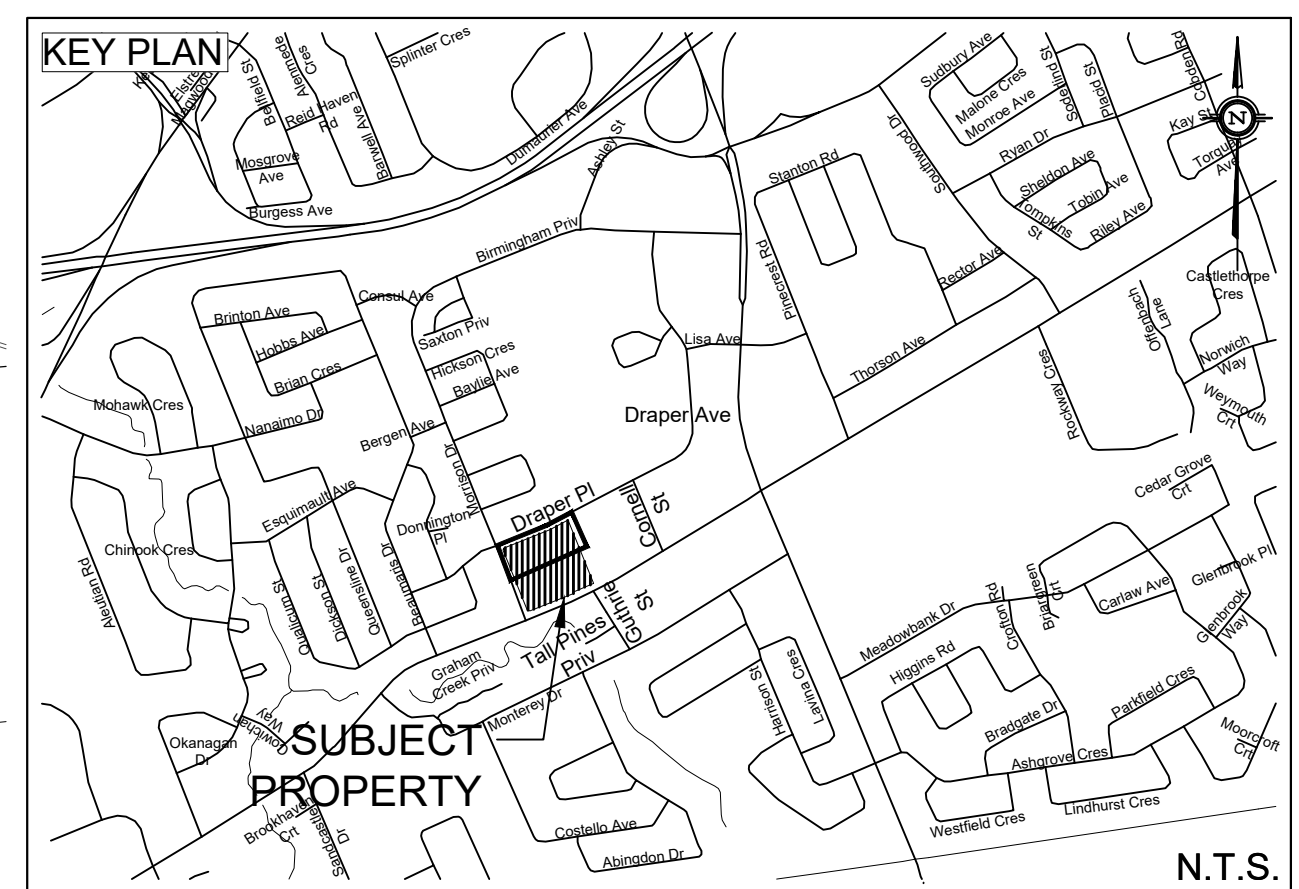

LEGEND

	PROPERTY LINE		PROPOSED STORM MANHOLE
	PROPOSED STORM SEWER		PROPOSED CATCH BASIN
	DRAINAGE DIVIDE		PROPOSED CB "1" OR "1"
	PROPOSED SWALE		
	PROPOSED PERFORATED SUBDRAIN		
	MAJOR SYSTEM FLOW ROUTE		

	DRAINAGE AREA ID
	RATIONAL METHOD RUNOFF COEFFICIENT
UPSTREAM MANHOLE ID TO DOWNSTREAM MANHOLE ID	

NOT FOR CONSTRUCTION

TOPOGRAPHIC INFORMATION
TOPOGRAPHIC INFORMATION PROVIDED BY ANNIS, O'SULLIVAN, VOLLEBEKK LTD.
PROJ. NO. 19336-17
DATED MAY 16, 2017


SITE PLAN INFORMATION
 SITE PLAN PROVIDED BY RODERICK LAHEY ARCHITECTS
 PROJ. NO. 1020
 RECEIVED MARCH 12, 2018

GEOTECHNICAL STUDY
 GEOTECHNICAL RECOMMENDATIONS PROVIDED BY PATERSON GROUP INC.
 PROJ. NO. PG1630-3
 DATED NOVEMBER 28, 2017 REVISION 1

SITE SERVICING AND STORMWATER MANAGEMENT STUDY
 SERVICING AND STORMWATER MANAGEMENT RECOMMENDATIONS PROVIDED BY DSEL
 PROJ. NO. 17-927
 DATED MAY 2018

BENCH MARK
TOP OF FIRE SPINDLE LOCATED NORTH EAST OF THE SUBJECT SITE
ELEV=74.01m

5	A.J.G.	18.05.02	ISSUED FOR MUNICIPAL REVIEW
4	A.J.G.	18.03.23	ISSUED FOR MUNICIPAL REVIEW
3	A.J.G.	17.11.28	ISSUED FOR GEOTECHNICAL REVIEW
2	A.J.G.	17.11.17	ISSUED FOR MUNICIPAL REVIEW
1	A.J.G.	17.06.14	ISSUED FOR MUNICIPAL REVIEW
No.	BY	YY.MM.DD	DESCRIPTION

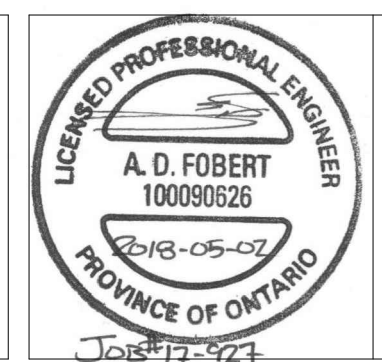


PROJECT No. 17-927

STORMWATER MANAGEMENT PLAN

FRESH TOWNS - 2710 DRAPER AVENUE PHASE 3-1 © DSEL

GREATWISE DEVELOPMENT

333 Wilson Avenue, Suite 200
Toronto, Ontario, M3H 1T2

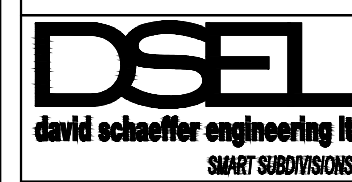

120 Iber Road Unit 103
Stittsville, Ontario, K2S 1E9
Tel. (613) 836-0856
Fax. (613) 836-7183
www.DSEL.ca

DRAWN BY: R.D.F.		CHECKED BY: A.D.F.		DRAWING NO.	SHEET NO.
DESIGNED BY: A.J.G.		CHECKED BY: R.D.F.		SWM-2	2 of 3
SCALE: 1: 300		DATE: MAY 2018			