



THESE DESIGN DOCUMENTS ARE PREPARED SOLELY FOR THE USE BY THE PARTY WITH WHOM THE DESIGN PROFESSIONAL HAS ENTERED INTO A CONTRACT AND THERE ARE NO REPRESENTATIONS OF ANY KIND MADE BY THE DESIGN PROFESSIONAL TO ANY PARTY WITH WHOM THE DESIGN PROFESSIONAL HAS NOT ENTERED INTO A CONTRACT.

THE PAPER COPY OF THE DRAWINGS ISSUED FOR BUILDING PERMIT AND/OR TENDER WILL TAKE PRECEDENCE OVER ELECTRONIC COPIES.

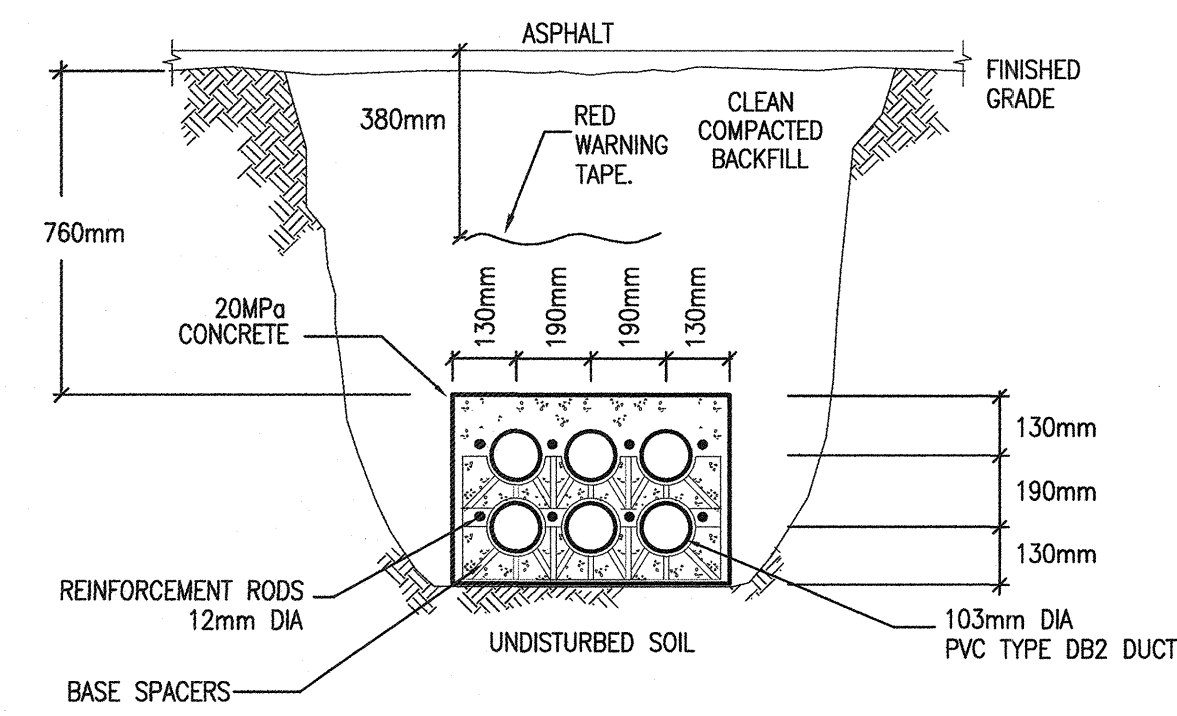


DETAIL SHOWN FOR REFERENCE ONLY, REFER TO HYDRO OTTAWA SPECIFICATIONS FOR ADDITIONAL INFORMATION. PROVIDE CONCRETE ENCASED 6-CELL DUCT BANK AS PER HYDRO OTTAWA DETAIL UDS0001, DETAIL E.

1 TRENCH DETAIL – PRIMARY 6 CELL
ES0.2 CONCRETE ENCASED
N.T.S.

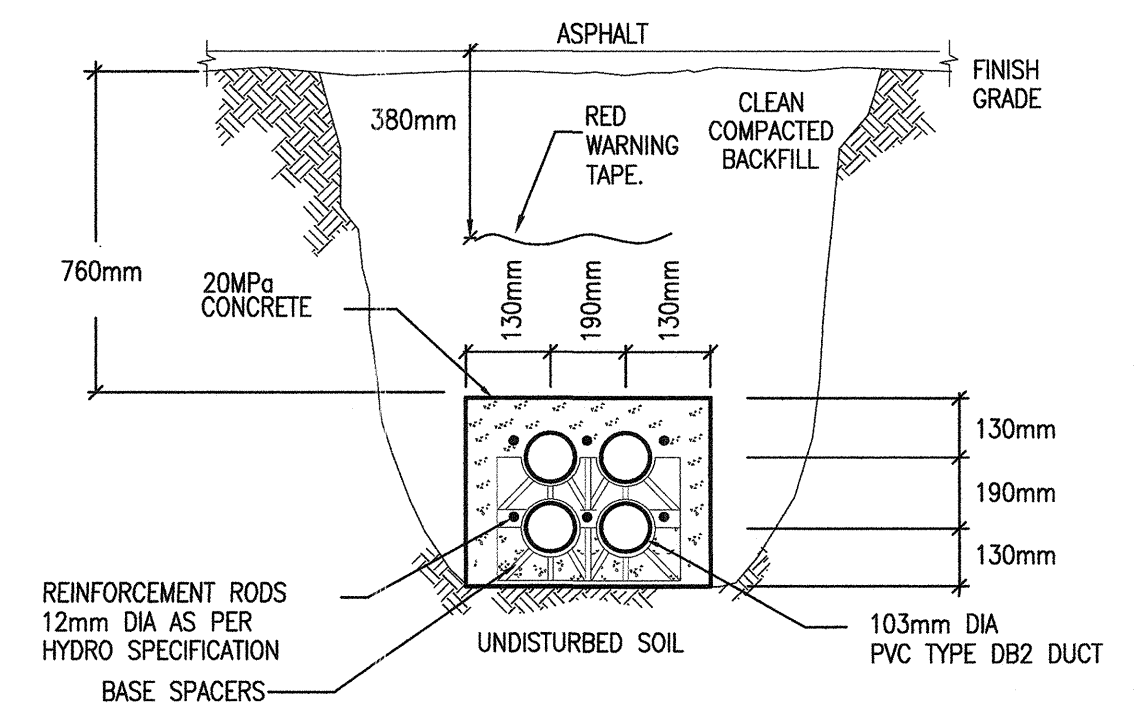

2 TRENCH DETAIL – SECONDARY 4 CELL
ES0.2 CONCRETE ENCASED
N.T.S.

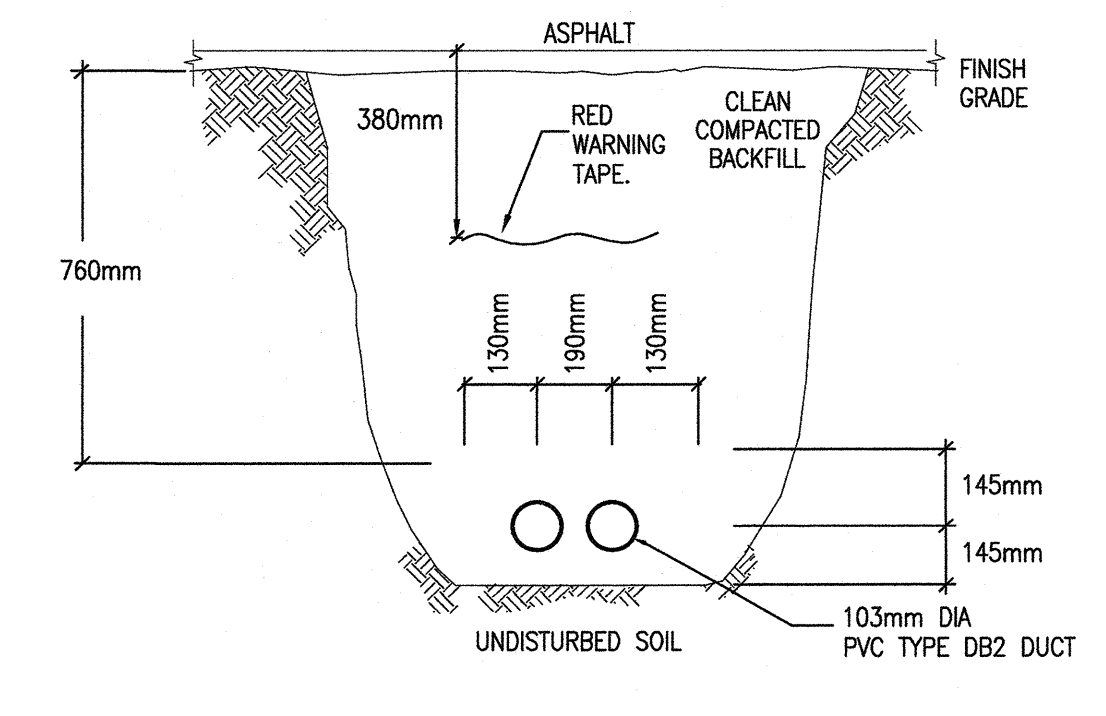

3 TRENCH DETAIL – 2 CELL DIRECT BURIED
ES0.2 N.T.S.

1.	SITE PLAN APPLICATION	APR 30/18
REVISION No.	DESCRIPTION	DATE

MCKEE ENGINEERING
R.J. MCKEE
ENGINEERING LTD.
1785 Woodward Drive
Ottawa, ON K2C 0P9
CANADA
Tel: (613) 723-9585
Fax: (613) 723-9584
www.mckeeottawa.ca

PROJECT:
TAGGART REALTY MANAGEMENT
EAGLESON RETAIL
DEVELOPMENT

DRAWING:
ELECTRICAL:
DETAILS

DATE: APRIL 2018
DESIGNED BY: M.O.
DRAWN BY: M.O.
CHECKED BY: G.O.M.
SCALE: N.T.S.

No. DWGS. 2
PROJECT No. 18022
DRAWING No. ES0.2

