


MONTFORT HOSPITAL  
ORLEANS HEALTH HUB

LEGEND

	PROPERTY LINE		EMERGENCY CALL SYSTEM
	CONCRETE PAVING W/ BROOM FINISH		LIGHT STANDARD
	TINTED CONCRETE PAVING W/ BROOM FINISH		BOLLARD LIGHT
	WOOD DECK		DOWN LIGHT
	DETECTABLE WARNING STRIP		UPLIGHT
	DECIDUOUS TREE		ELECTRICAL OUTLET
	CONIFEROUS TREE		LIGHT COLUMN
	LAWN - SOD		MANHOLE
	SEEDED MEADOW NATIVE SEED MIX		CATCH BASIN
	PLANTER CURB		VALVE BOX
	RAISED TIMBER PLANTER		FIRE HYDRANT
	TIMBER PERGOLA		HYDRO POLE
	SHADE STRUCTURE		SIAMESE CONNECTION
	FLAG POLE		WATER MAIN
	ORNAMENTAL METAL FENCE 1200HT		STORM SEWER
	BOLLARD		SANITARY SEWER
	PEAGRAVEL		HYDRO UNDERGROUND LINES
	BERM		OVERHANGING POWER LINES
	BIKE RACK		OVERHANGING POWER LINES OFFSET ZONES
	WOOD SCREEN		

MARK	DATE	DESCRIPTION
1.	17-06-16	ISSUED FOR REVIEW
2.	17-09-21	ISSUED FOR REVIEW
3.	17-11-10	MOHLTC STAGE 3.2 SKETCH PLAN
4.	18-02-16	ISSUED FOR 50% PEER REVIEW
5.	18-02-23	ISSUED FOR PEER REVIEW
6.	18-03-21	ISSUED FOR REVIEW
7.	18-04-03	ISSUED FOR REVIEW
8.	18-07-26	ISSUED FOR SPA
9.	18-10-19	ISSUED FOR SPA
10.	18-11-02	REVISED SPA

Project Number 1707  
Original Issue  
Scale: 1:500

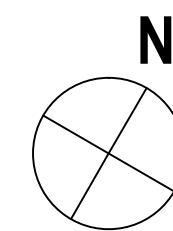

Sheet Name


LANDSCAPE UTILITY PLAN

Sheet Number

L101

Project Status

SITE PLAN APPROVAL

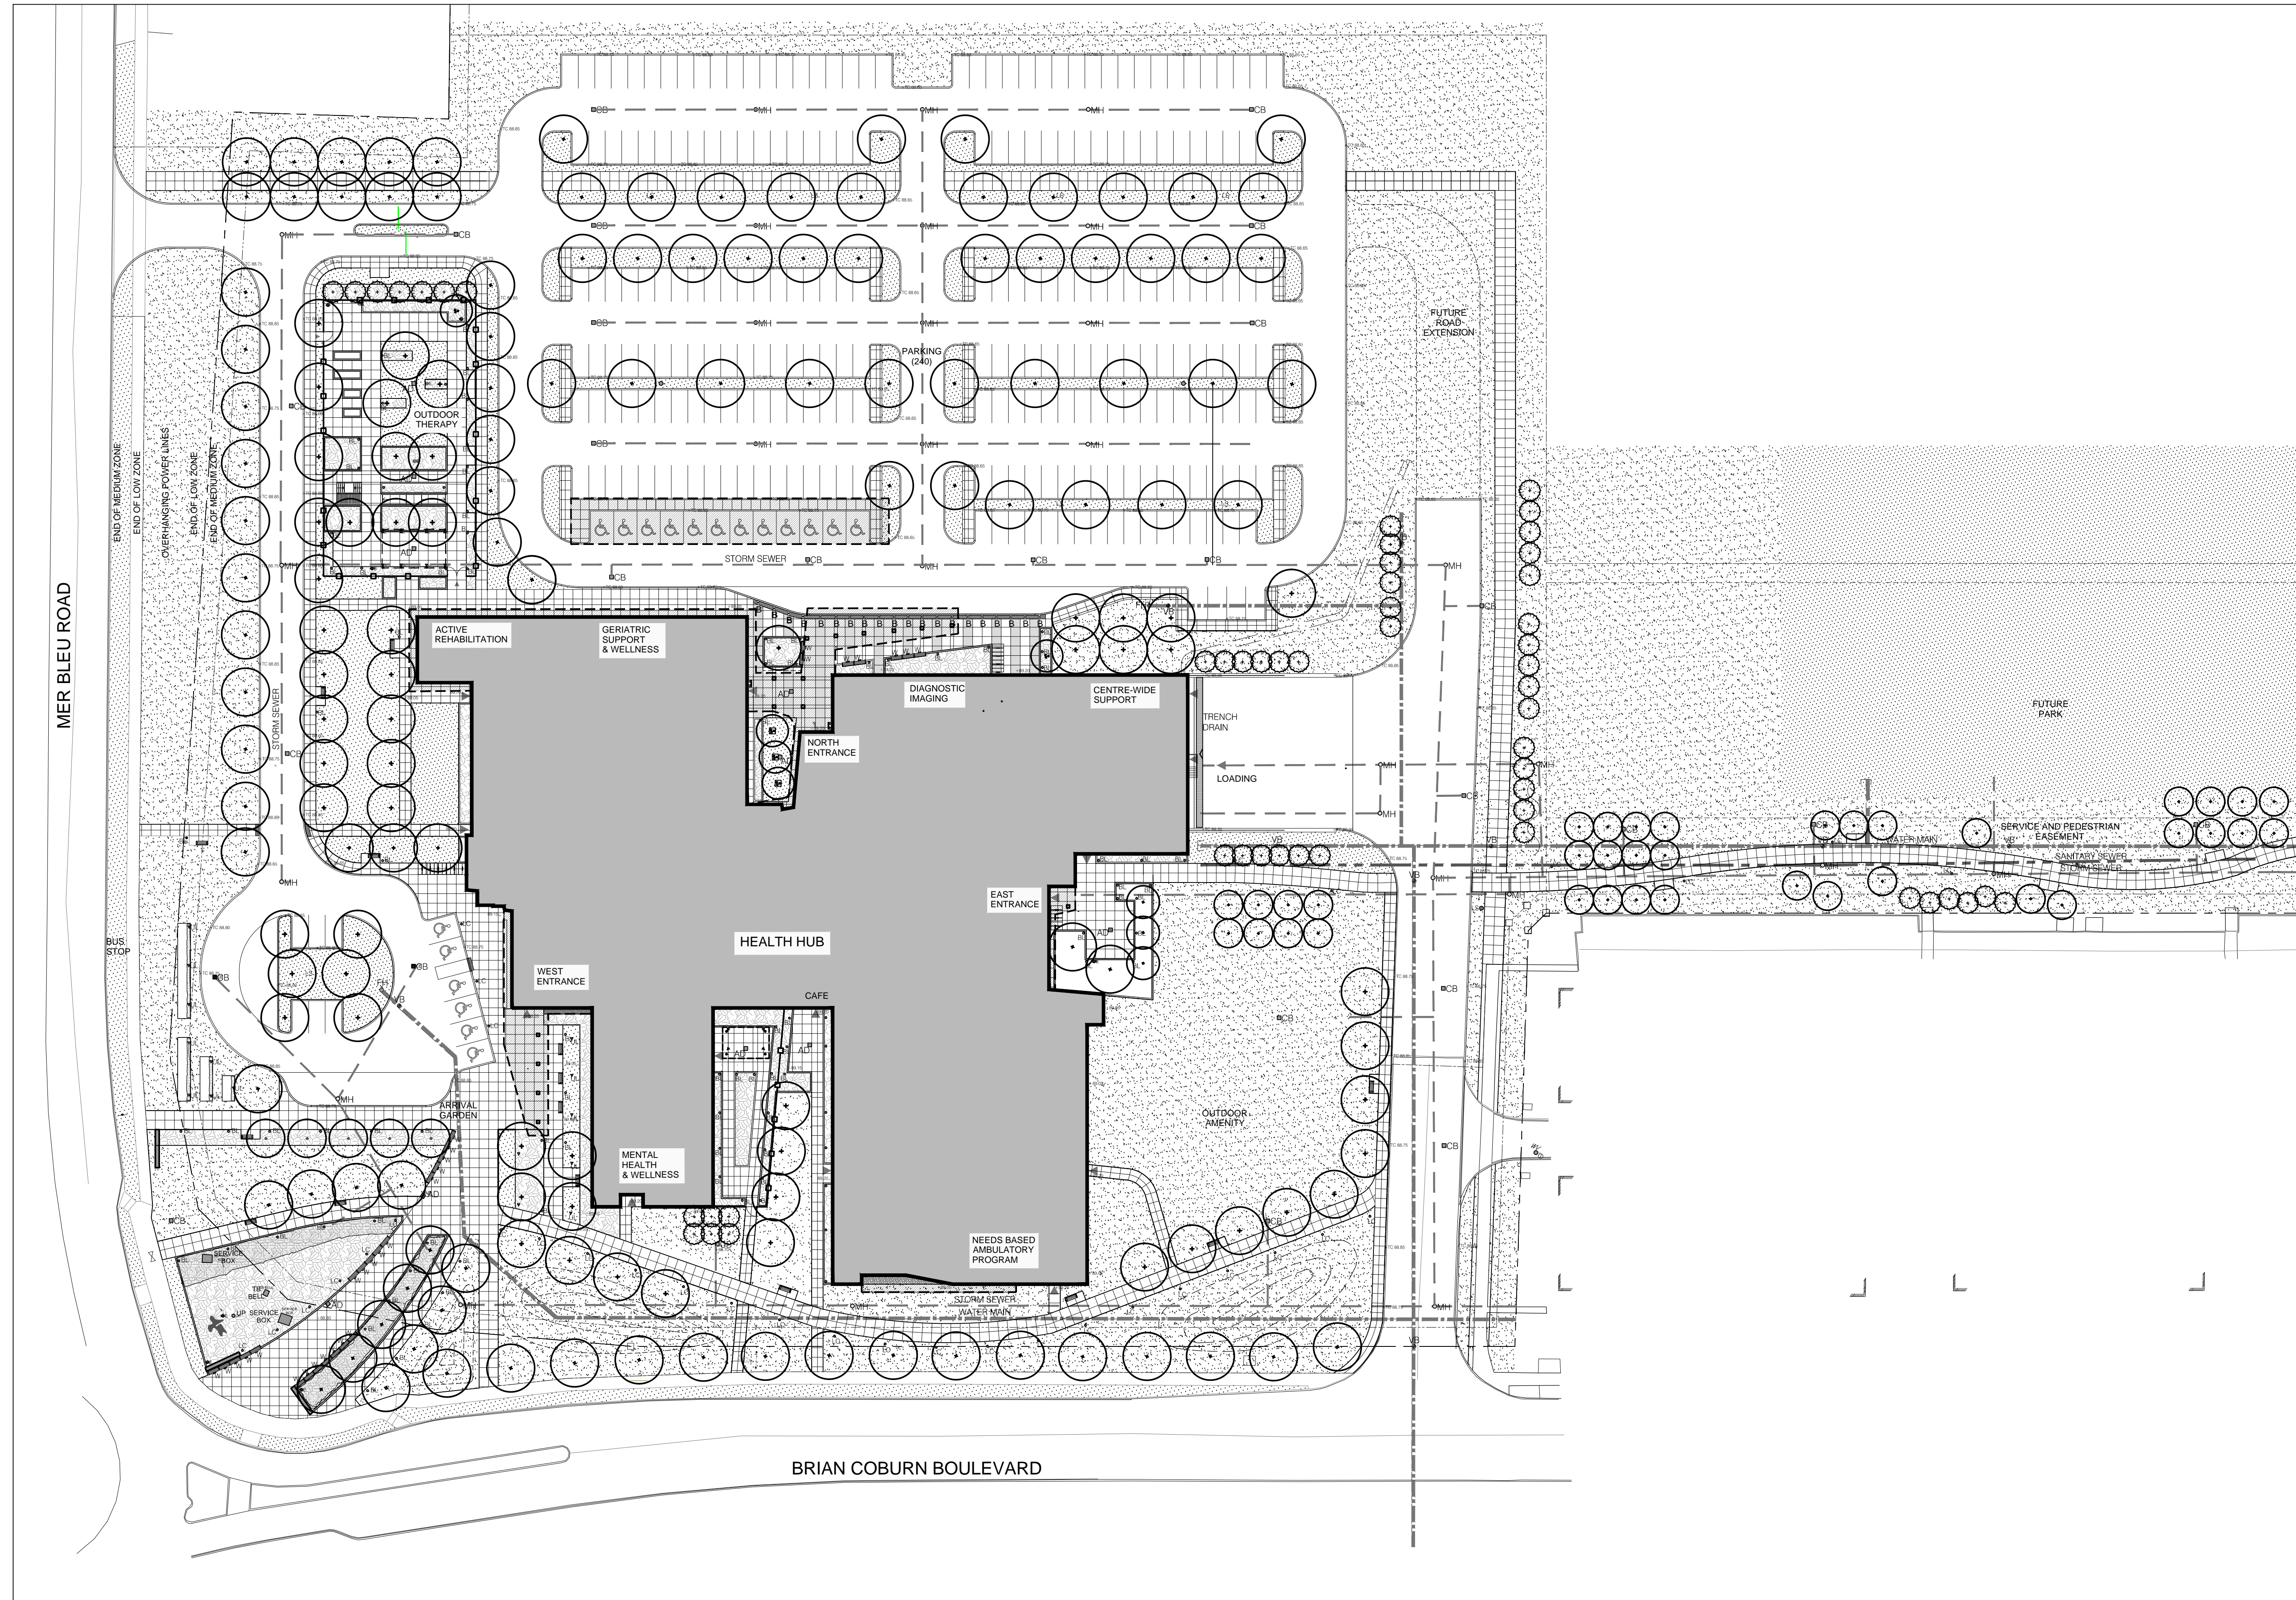

L1 LANDSCAPE UTILITY PLAN  
L101 PLAN

SCALE 1:500