

Luminaire Schedule						
Symbol	Qty	Label	LLF	Description	Lum. Watts	Lum. Lumens
	13	A	0.900	VPL-96L-220-4K7-4W-BC BEACON	217.6	15071
	18	B	0.900	LNC2-12L-4K-035-2 HUBBELL	13.8	1506
	8	C	0.900	LNC3-24L4K-035-4 HUBBELL	27.9	3116
	7	D	0.900	LNC3-24L4K-035-3 HUBBELL	27.894	3094

Luminaire Schedule						
Symbol	Qty	Label	LLF	Description	Lum. Watts	Lum. Lumens
	13	A	0.900	VPL-96L-220-4K7-4W-BC BEACON	217.6	15071
	18	B	0.900	LNC2-12L-4K-035-2 HUBBELL	13.8	1506
	8	C	0.900	LNC3-24L4K-035-4 HUBBELL	27.9	3116
	7	D	0.900	LNC3-24L4K-035-3 HUBBELL	27.894	3094



project:

COWAN'S GROVE PLAZA


4791 Bank St
OTTAWA, ONTARIO

SITE PHOTOMETRIC PLAN

project no.: 501-18N	drawing no.: E-1
revision: 0	of 2

An exact copy of all working documents including, without limitations, the original of the present document or plan is kept on file by J.R.P. Engineering. Any modification carried out to this document or plan or its accompanying documents without written authorization by the engineer is prohibited.

Authorized modifications must be signed and sealed by an engineer and this engineer will be completely responsible for these modifications. J.R.P. Engineering is not and will not be responsible for the consequences of these modifications or for modifications carried out without it's consent.

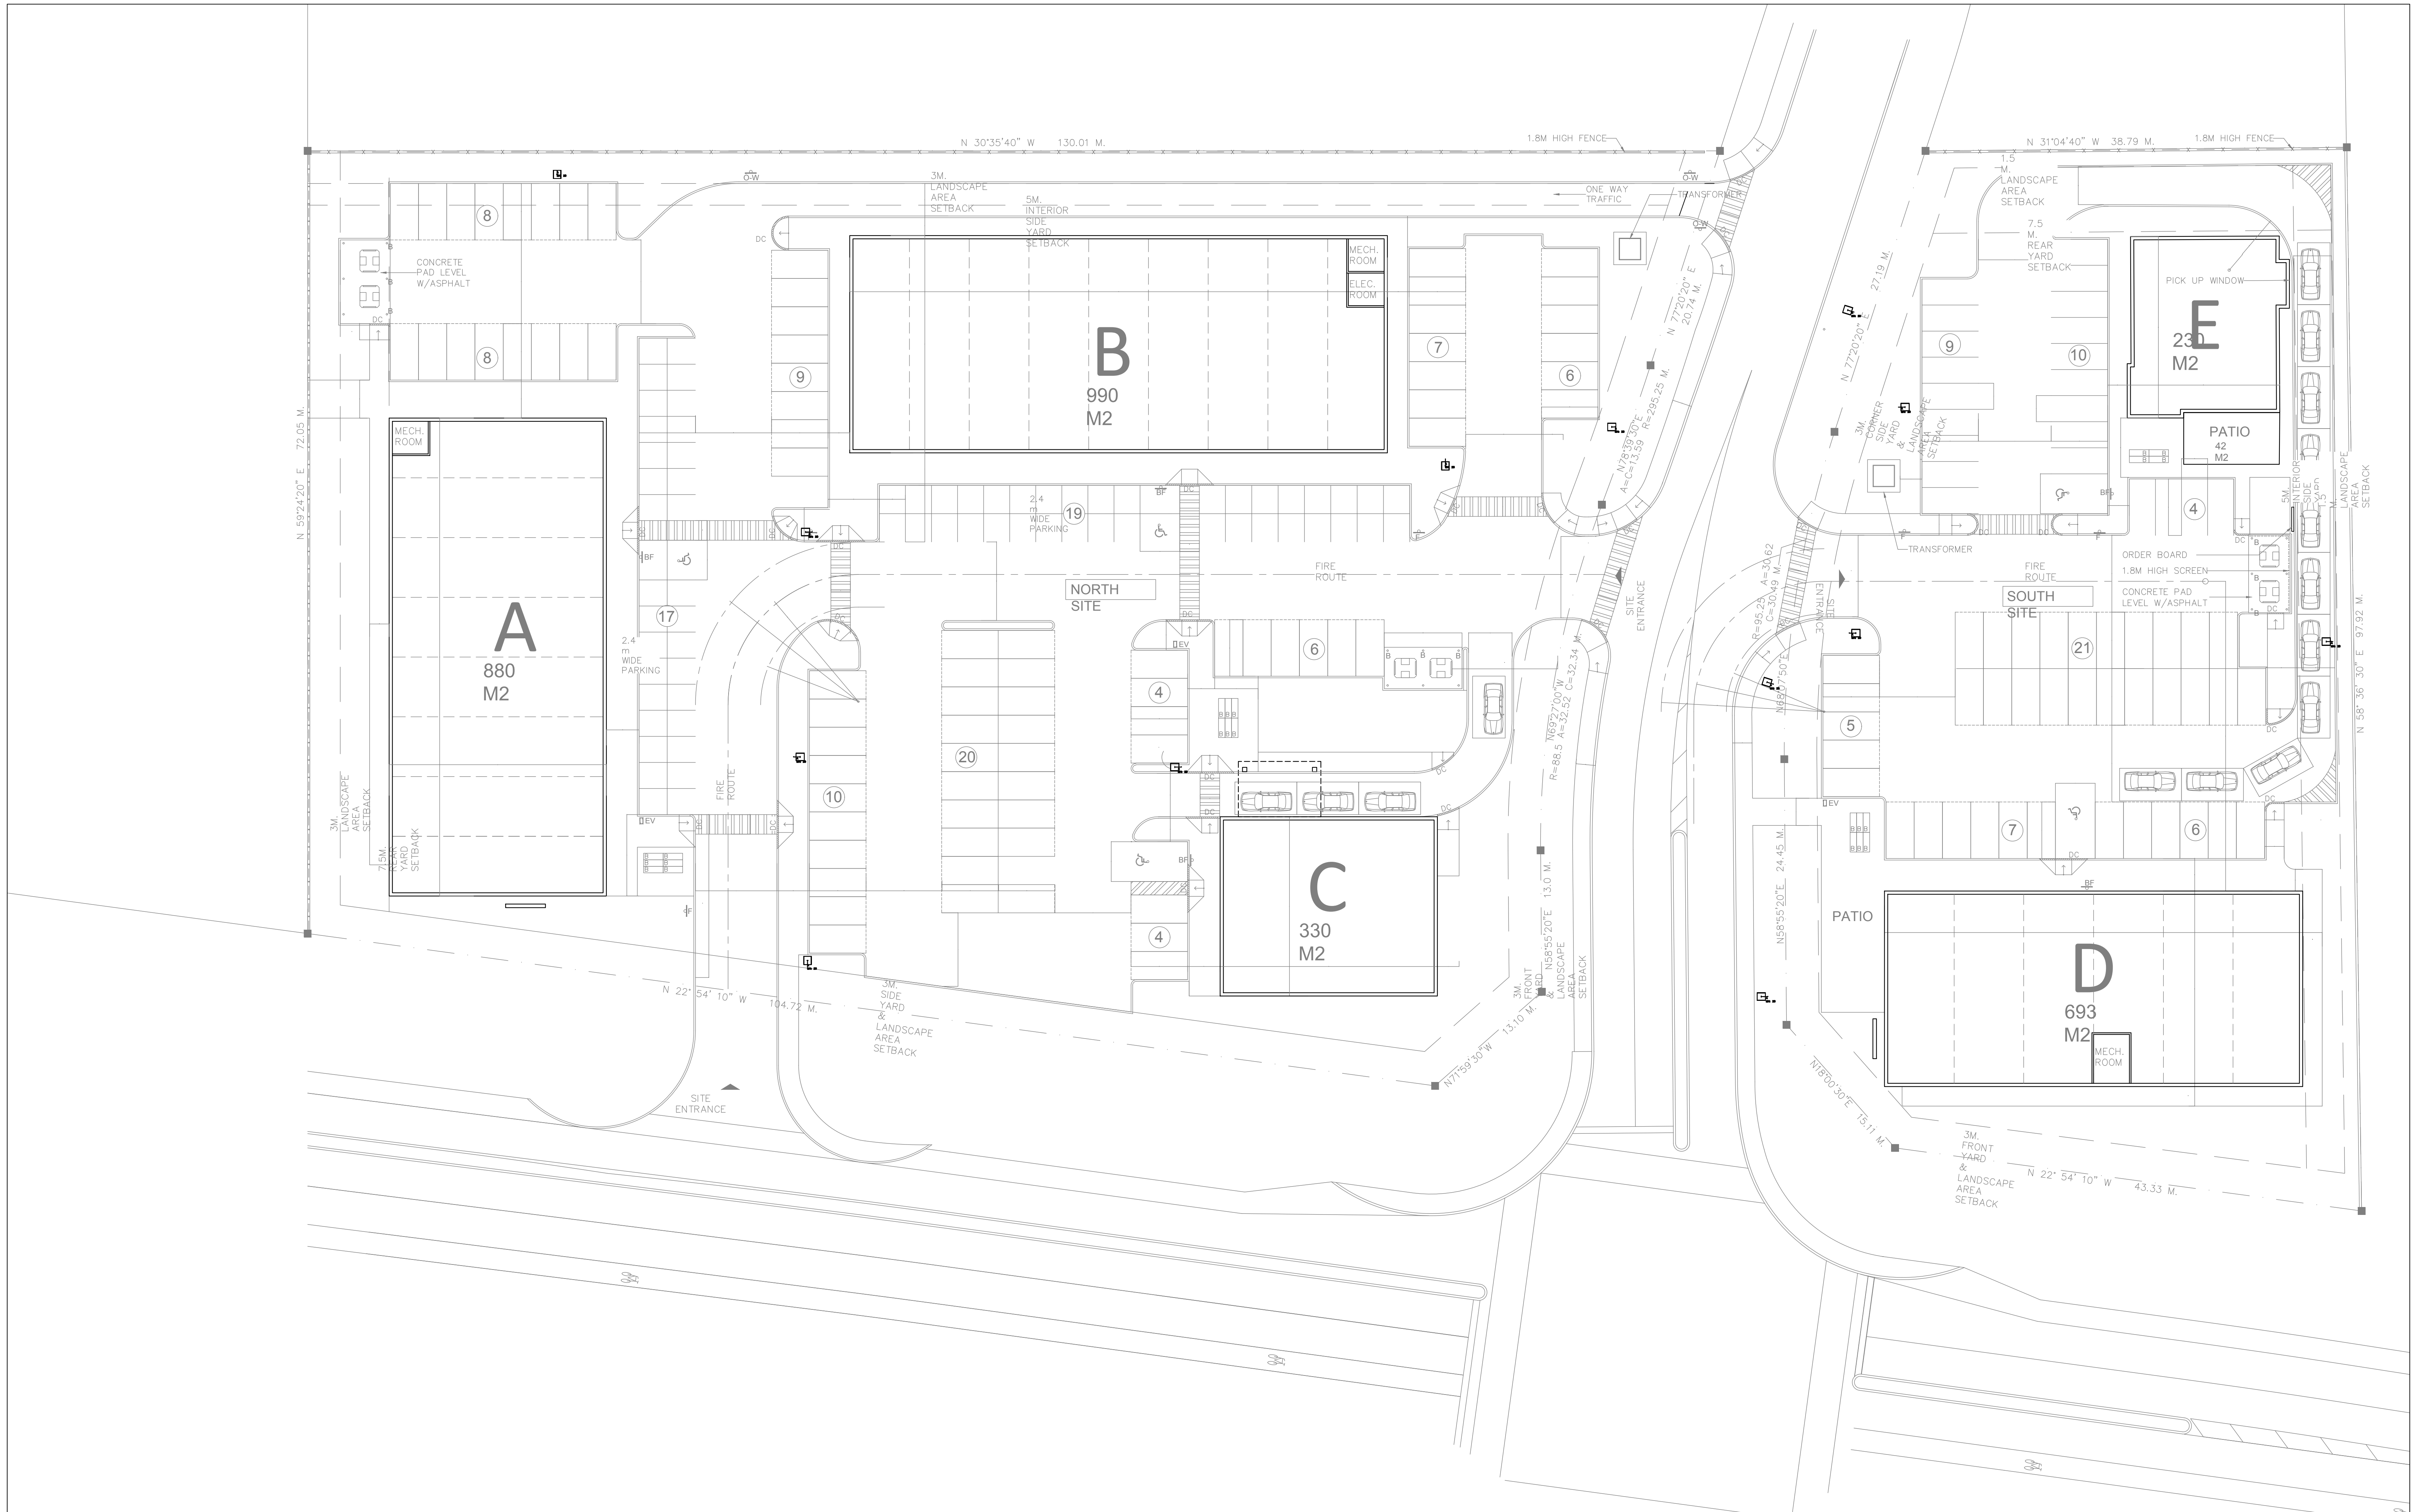

1 SITE LIGHTING PHOTOMETRIC
E-1 1:250

No	DESCRIPTION	DATE
1	ISSUED FOR SITE PLAN R1	NOV 16TH 2018
0	ISSUED FOR SITE PLAN	JULY 9TH 2018

REVISIONS



client:	URBANDALE CONSTRUCTION 2193 ARCH ST OTTAWA, ON K1G 2H5
---------	---

project:	COWAN'S GROVE PLAZA 4791 Bank St OTTAWA, ONTARIO
----------	--

drawing title:	SITE LIGHTING PLAN
----------------	--------------------

scale:	AS SHOWN	drawn by:	M.G
designed by:	M.G	reviewed by:	J.R.P.
approved by:	J.R.P.	date:	NOV 2018

project no.:	501-18N	drawing no.:	E-2
revision:	0		of 2