
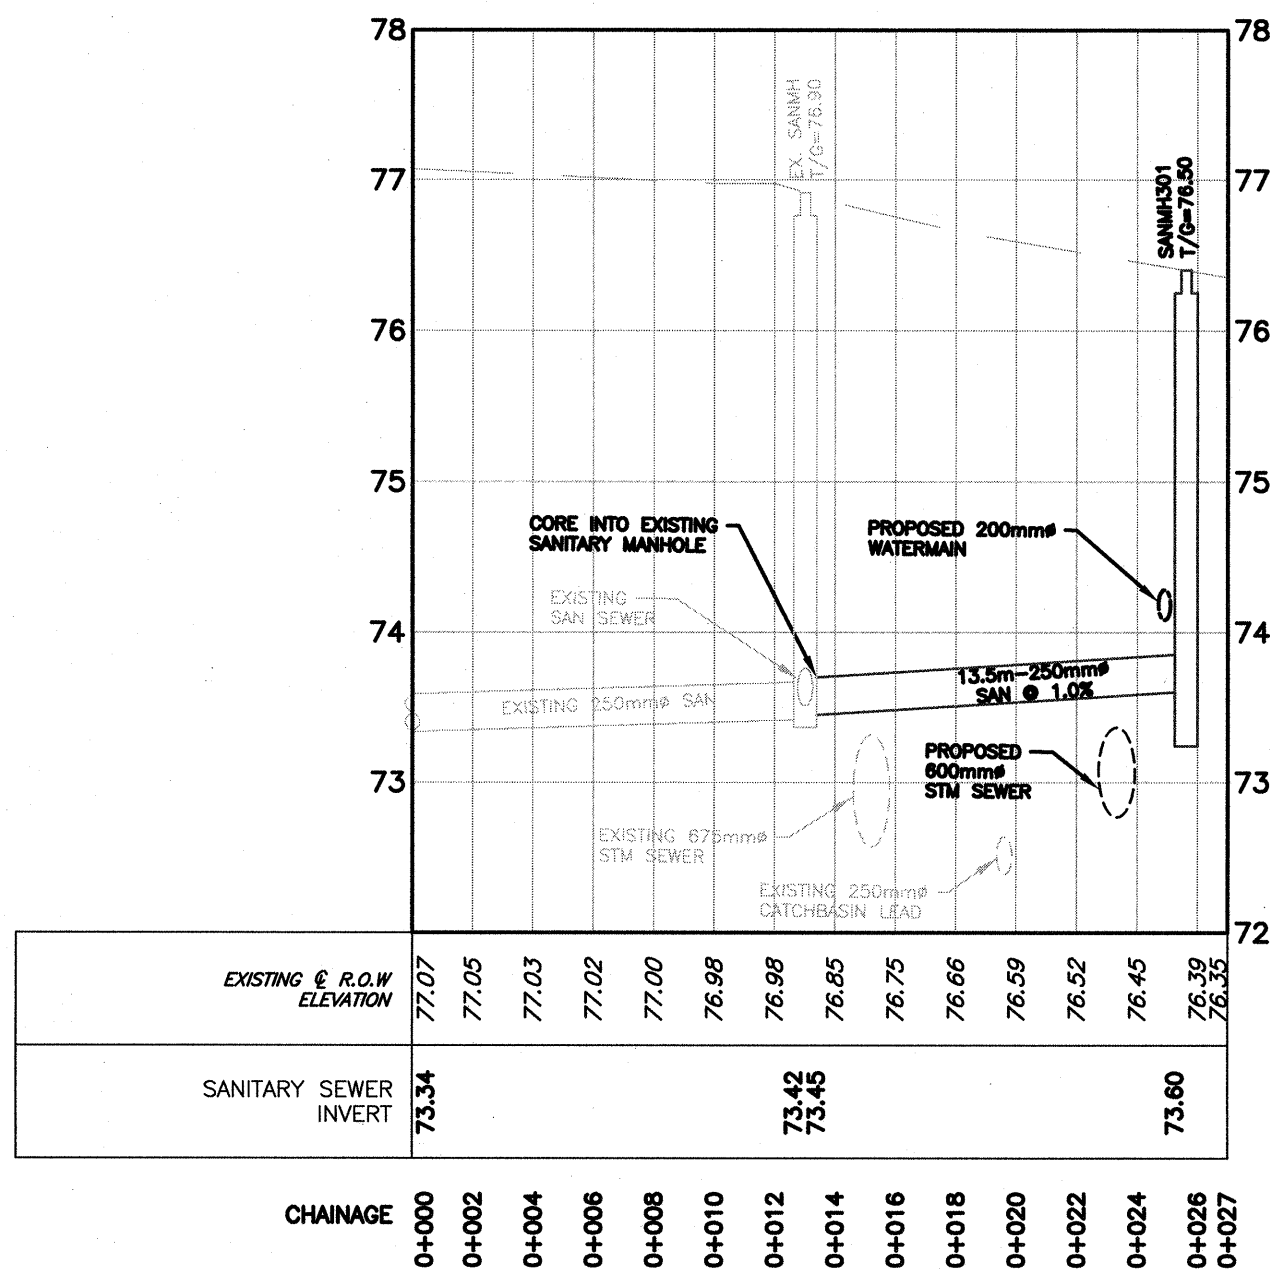


LEGEND

SB	STANDARD IRON BAR
IB	IRON BAR
CB	CATCH BASIN
MB	MANHOLE
WMH	WATER MANHOLE
LS	LAMP STANDARD
UP	UTILITY POLE
WV	WATER VALVE
FH	FIRE HYDRANT
W	WELL
GA	GUY WIRE AND ANCHOR
WM	WATERMAIN
UW	UNDERGROUND UTILITY WIRES
UB	UNDERGROUND HYDRO
UB	UNDERGROUND BELL
GM	GAS MAIN
CR	CABLE (ROGERS)
SL	STREET LIGHT
SS	STORM SEWER
SS	SANITARY SEWER
CR	CURB
CR	PROPOSED CURB
WM	PROPOSED WATERMAIN
SS	PROPOSED STORM SEWER
SS	PROPOSED SANITARY SEWER
MB	PROPOSED SANITARY MANHOLE
MB	PROPOSED STORM MANHOLE
MB	PROPOSED STORM CATCHBASIN MANHOLE
MB	PROPOSED STORM CATCHBASIN
MB	PROPOSED FIRE HYDRANT
MB	PROPOSED VALVE & VALVE BOX
MB	PROPOSED SIAMESE CONNECTION
MB	PROPOSED WATER METER
MB	PROPOSED REMOTE WATER METER
HP	PROPOSED HEAVY DUTY PAVEMENT
LP	PROPOSED LIGHT DUTY PAVEMENT
CS	PROPOSED CONCRETE SIDEWALK
3:1	TERRACING 3:1 MAX
150mm	150mm PERFORATED SUBDRAIN

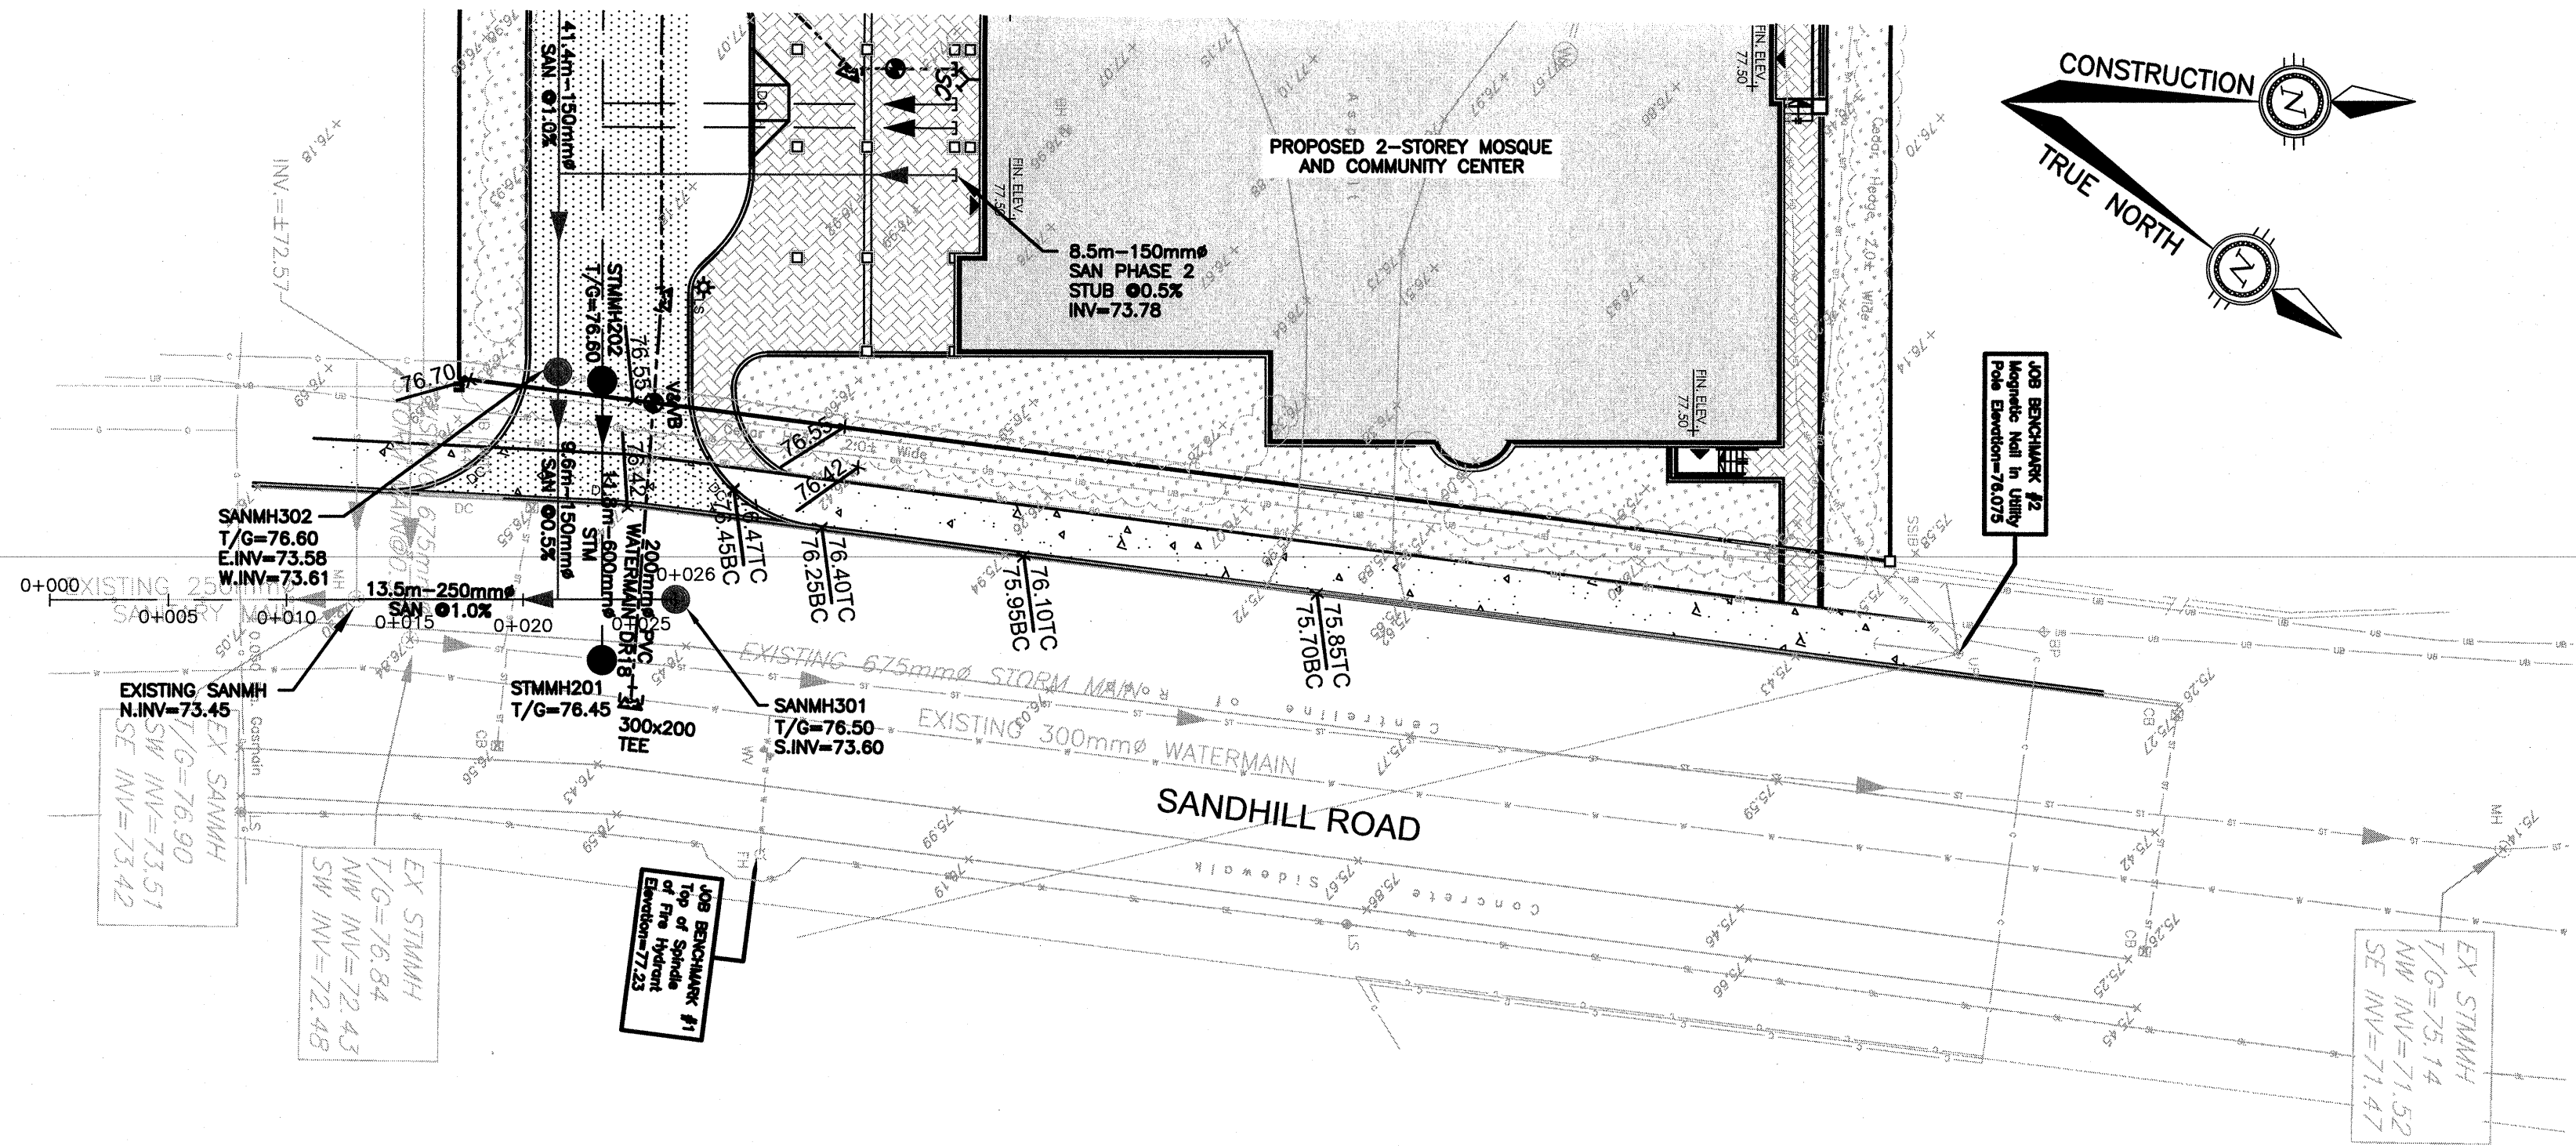

SANDHILL ROAD SANITARY EXTENSION
SCALE: HORIZ 1:250 VERT 1:50

APPROVED ☐ REFUSED ☐


THIS _____ DAY OF _____, 20____

DERRICK MOODIE, MANAGER
DEVELOPMENT REVIEW WEST
PLANNING INFRASTRUCTURE AND ECONOMIC
DEVELOPMENT DEPARTMENT, CITY OF OTTAWA

CAUTION
THE POSITION OF ALL POLE LINES, CONDUITS, WATERMANS, SEWERS AND OTHER UNDERGROUND AND OVERGROUND UTILITIES AND STRUCTURES IS NOT NECESSARILY SHOWN ON THE CONTRACT DRAWINGS, AND WHERE SHOWN, THE ACCURACY OF THE POSITION OF SUCH UTILITIES AND STRUCTURES IS NOT GUARANTEED. BEFORE STARTING WORK, DETERMINE THE EXACT LOCATION OF ALL SUCH UTILITIES AND STRUCTURES AND ASSUME ALL LIABILITY FOR DAMAGE TO THEM.

PRELIMINARY
NOT FOR CONSTRUCTION

NO.	1	ISSUED FOR SITE APPLICATION	02/11/18	AE	AA
NO.		REVISION DESCRIPTION	DATE	BY	APPD

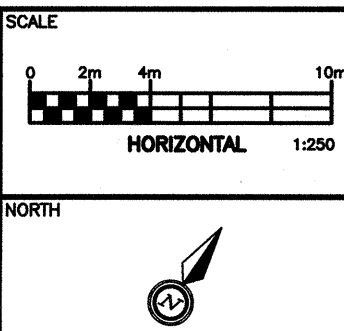

DESIGNED BY

REVIEWED BY

M.A. ANSARI
23/11/2018
PROVINCE OF ONTARIO

CLIENT

KANATA MUSLIM ASSOCIATION
832 MARCH ROAD, OTTAWA, ON.
K2W 0C9
613.973.5000

exp. Services Inc.
2111 FREDERICK STREET • #113, 2ND FLOOR
OTTAWA, ON K2B 8H6
www.exp.com
• BUILDINGS • EARTH & ENVIRONMENT • ENERGY •
• INDUSTRIAL • INFRASTRUCTURE • SUSTAINABILITY •

BASE PLAN
DESIGN
CHECKED
CAD
PROJECT MANAGER
APPROVED

PROJECT
KMA MOSQUE AND COMMUNITY CENTRE
351 SANDHILL ROAD, OTTAWA, ON

TITLE
MUNICIPAL SANITARY EXTENSION
PLAN AND PROFILE

PROJECT No.
OTT-00238504-A0

SURVEY
F M & W

DATE
2018-11-12

DRAWING No.
PP