
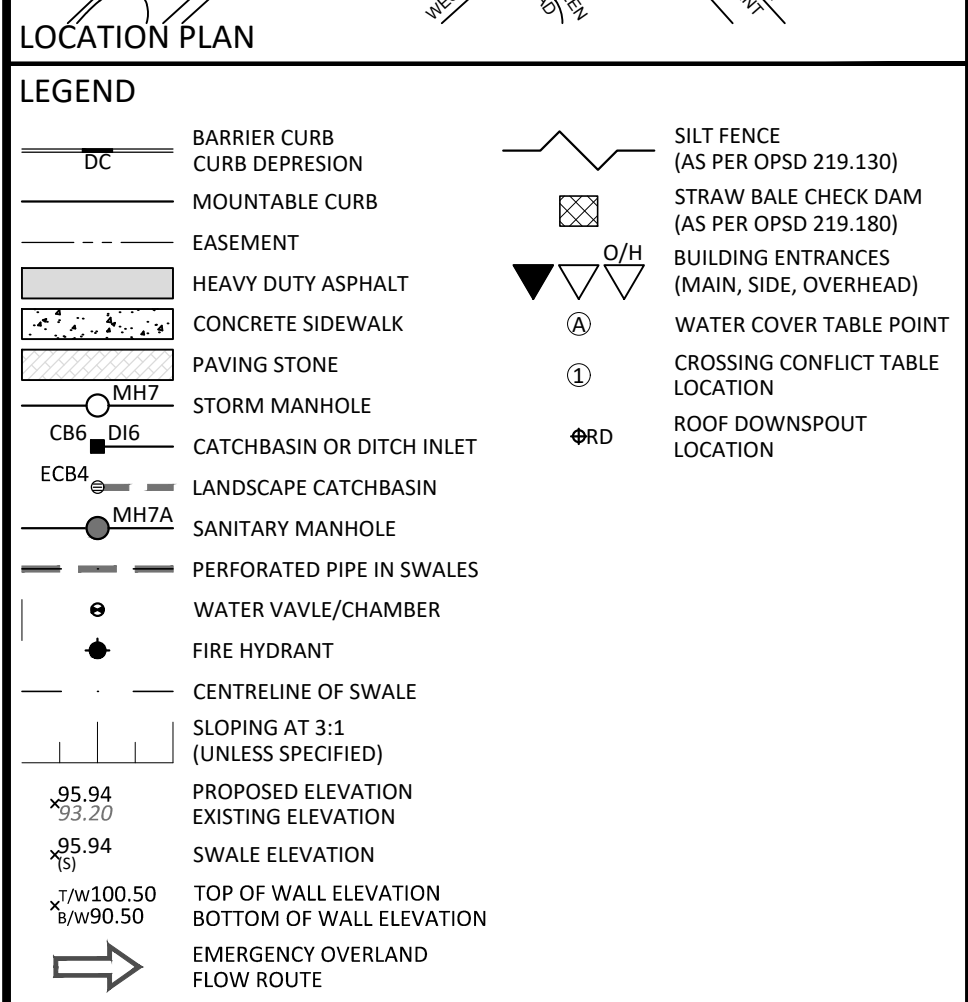



WATER COVER TABLE				
LOCATION	STATION	FINISHED GRADE	TOP OF PIPE	DEPTH OF PIPE
305 x 150 TEE	O+00.00	128.790	126.390	2.400
VALVE	O+01.02	128.800	126.500	2.400
150 x 150 TEE	O+01.73	128.700	126.300	2.400
150" 50 REDUCER	O+01.93	128.620	126.220	2.400
45" BEND	O+02.23	128.400	126.000	2.400
45" BEND	O+05.34	128.700	126.300	2.400
BUILDING	O+061.86	128.850	126.450	2.400
150 x 150 TEE	O+00.00	128.700	126.300	2.400
VALVE	O+00.14	128.730	126.330	2.400
HYDRANT	O+00.14	128.800	126.400	2.400

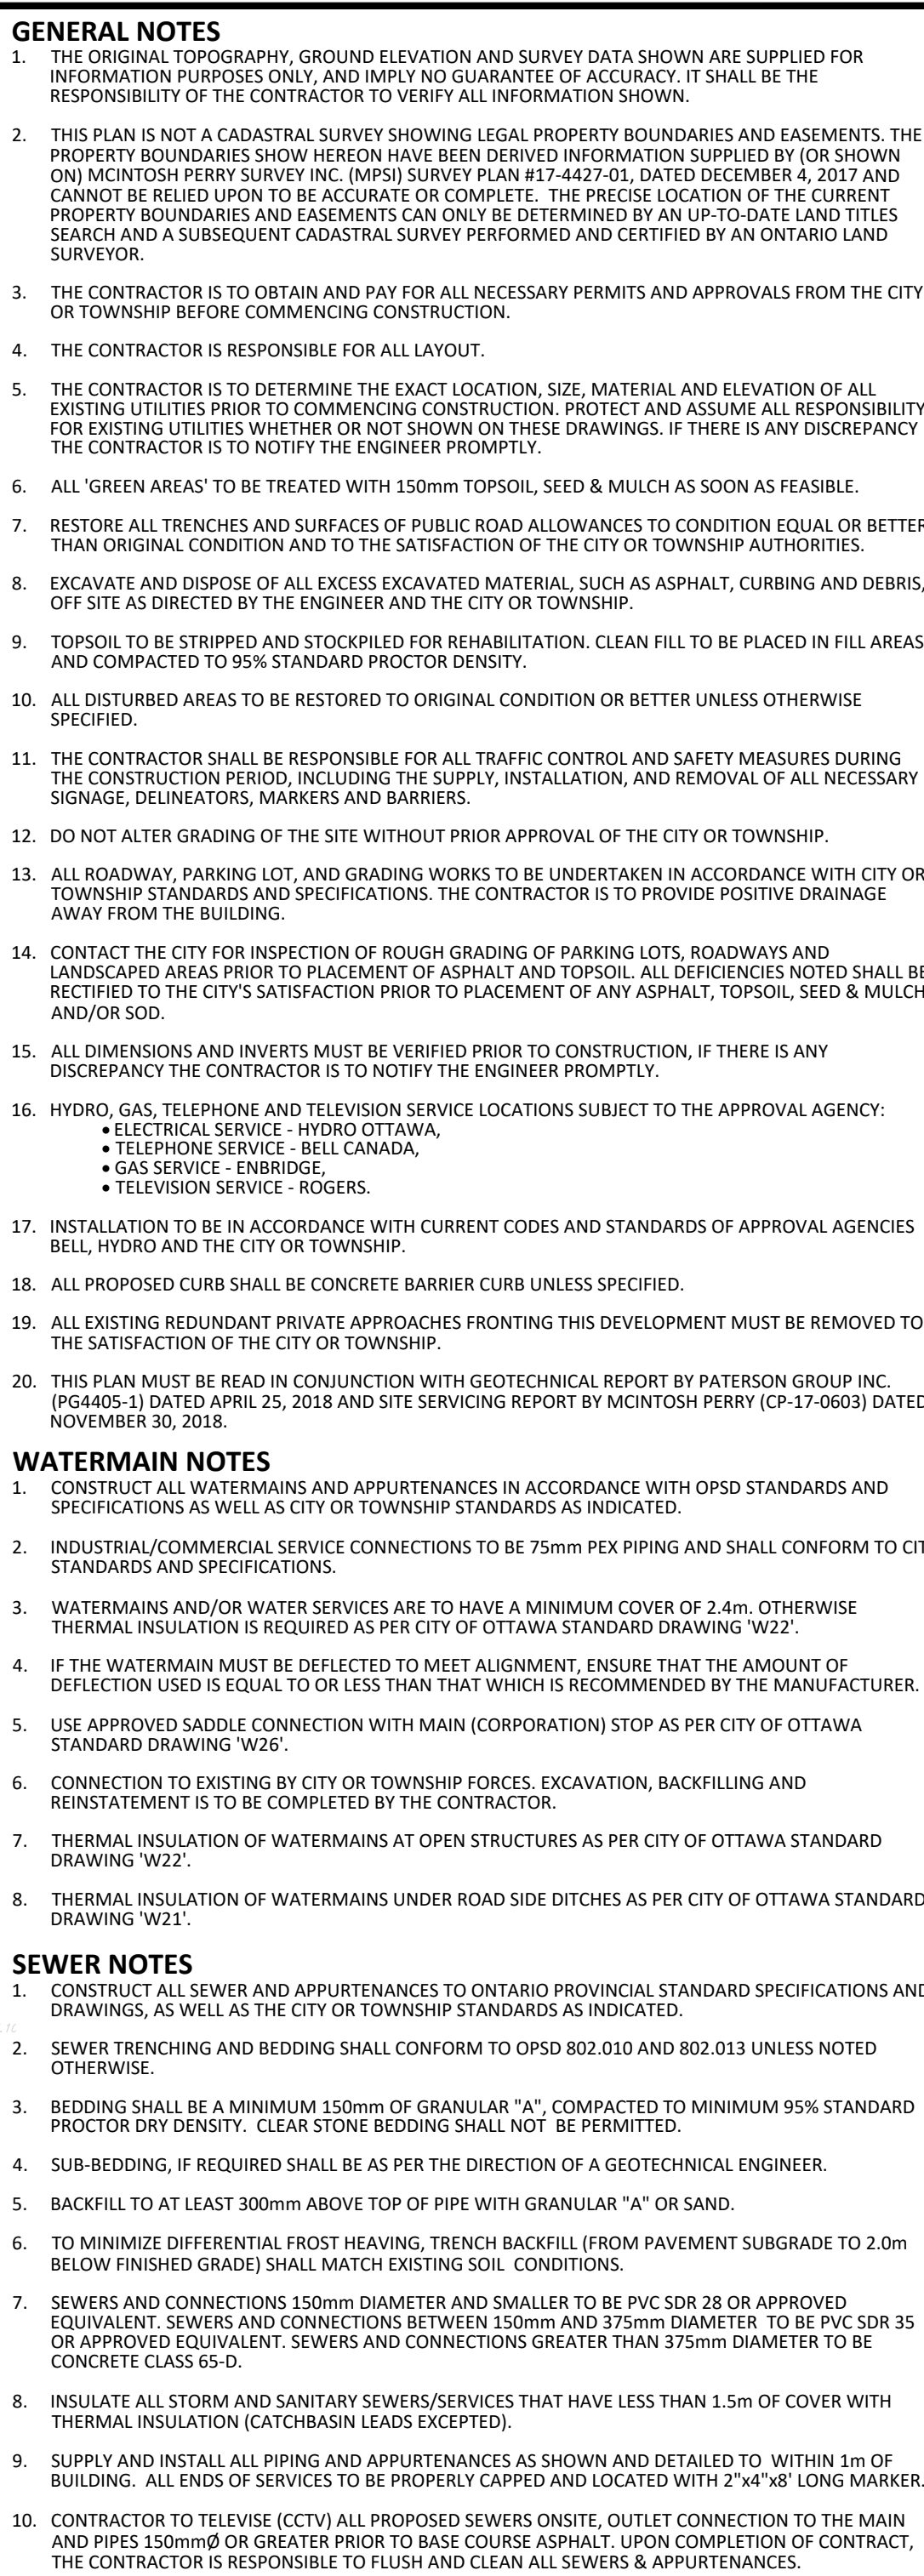

**FOR REVIEW ONLY**  
*NOT FOR CONSTRUCTION*

1	ISSUED FOR SITE PLAN CONTROL	NOV. 30, 2018
No.	Revisions	Date

 
Check and verify all dimensions before proceeding with the work Do not scale drawings



McINTOSH PERRY

115 Walgreen Road, RR3, Carp, ON K0A 1L0  
Tel: 613-836-2184 Fax: 613-836-3742  
[www.mcintoshperry.com](http://www.mcintoshperry.com)

[www.mcintoshperry.com](http://www.mcintoshperry.com)

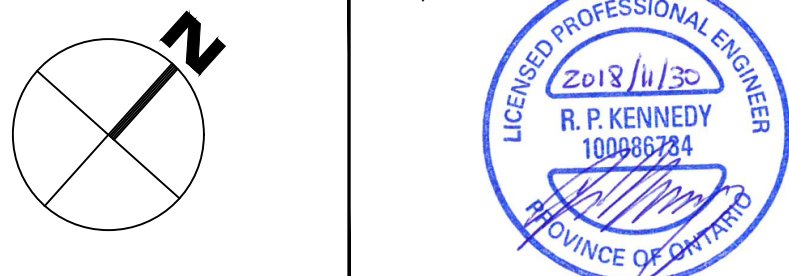

Client: **BBS CONSTRUCTION LTD.**  
1805 WOODWARD DRIVE  
OTTAWA, ON K2C 0P9

Project:

**CARP ROAD BODY SHOP**  
2113 & 2125 CARP ROAD

Drawing Title:

**SITE SERVICING PLAN**

Scale:	1:500	Project Number:	CP-17-0603
Drawn By:	C.D.H.		
Checked By:	R.P.K.	Drawing Number:	C102
Designed By:	C.D.H.		