
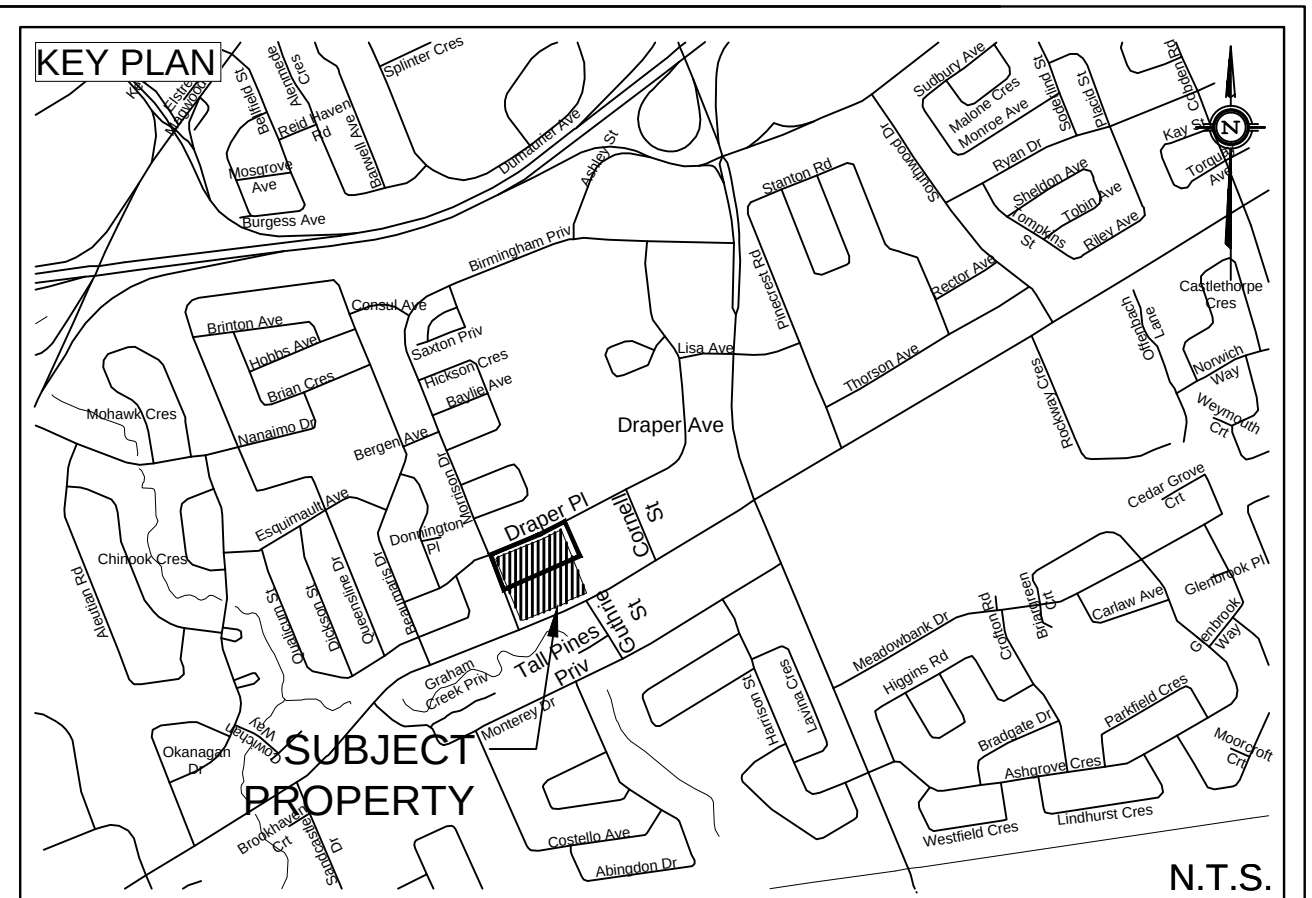


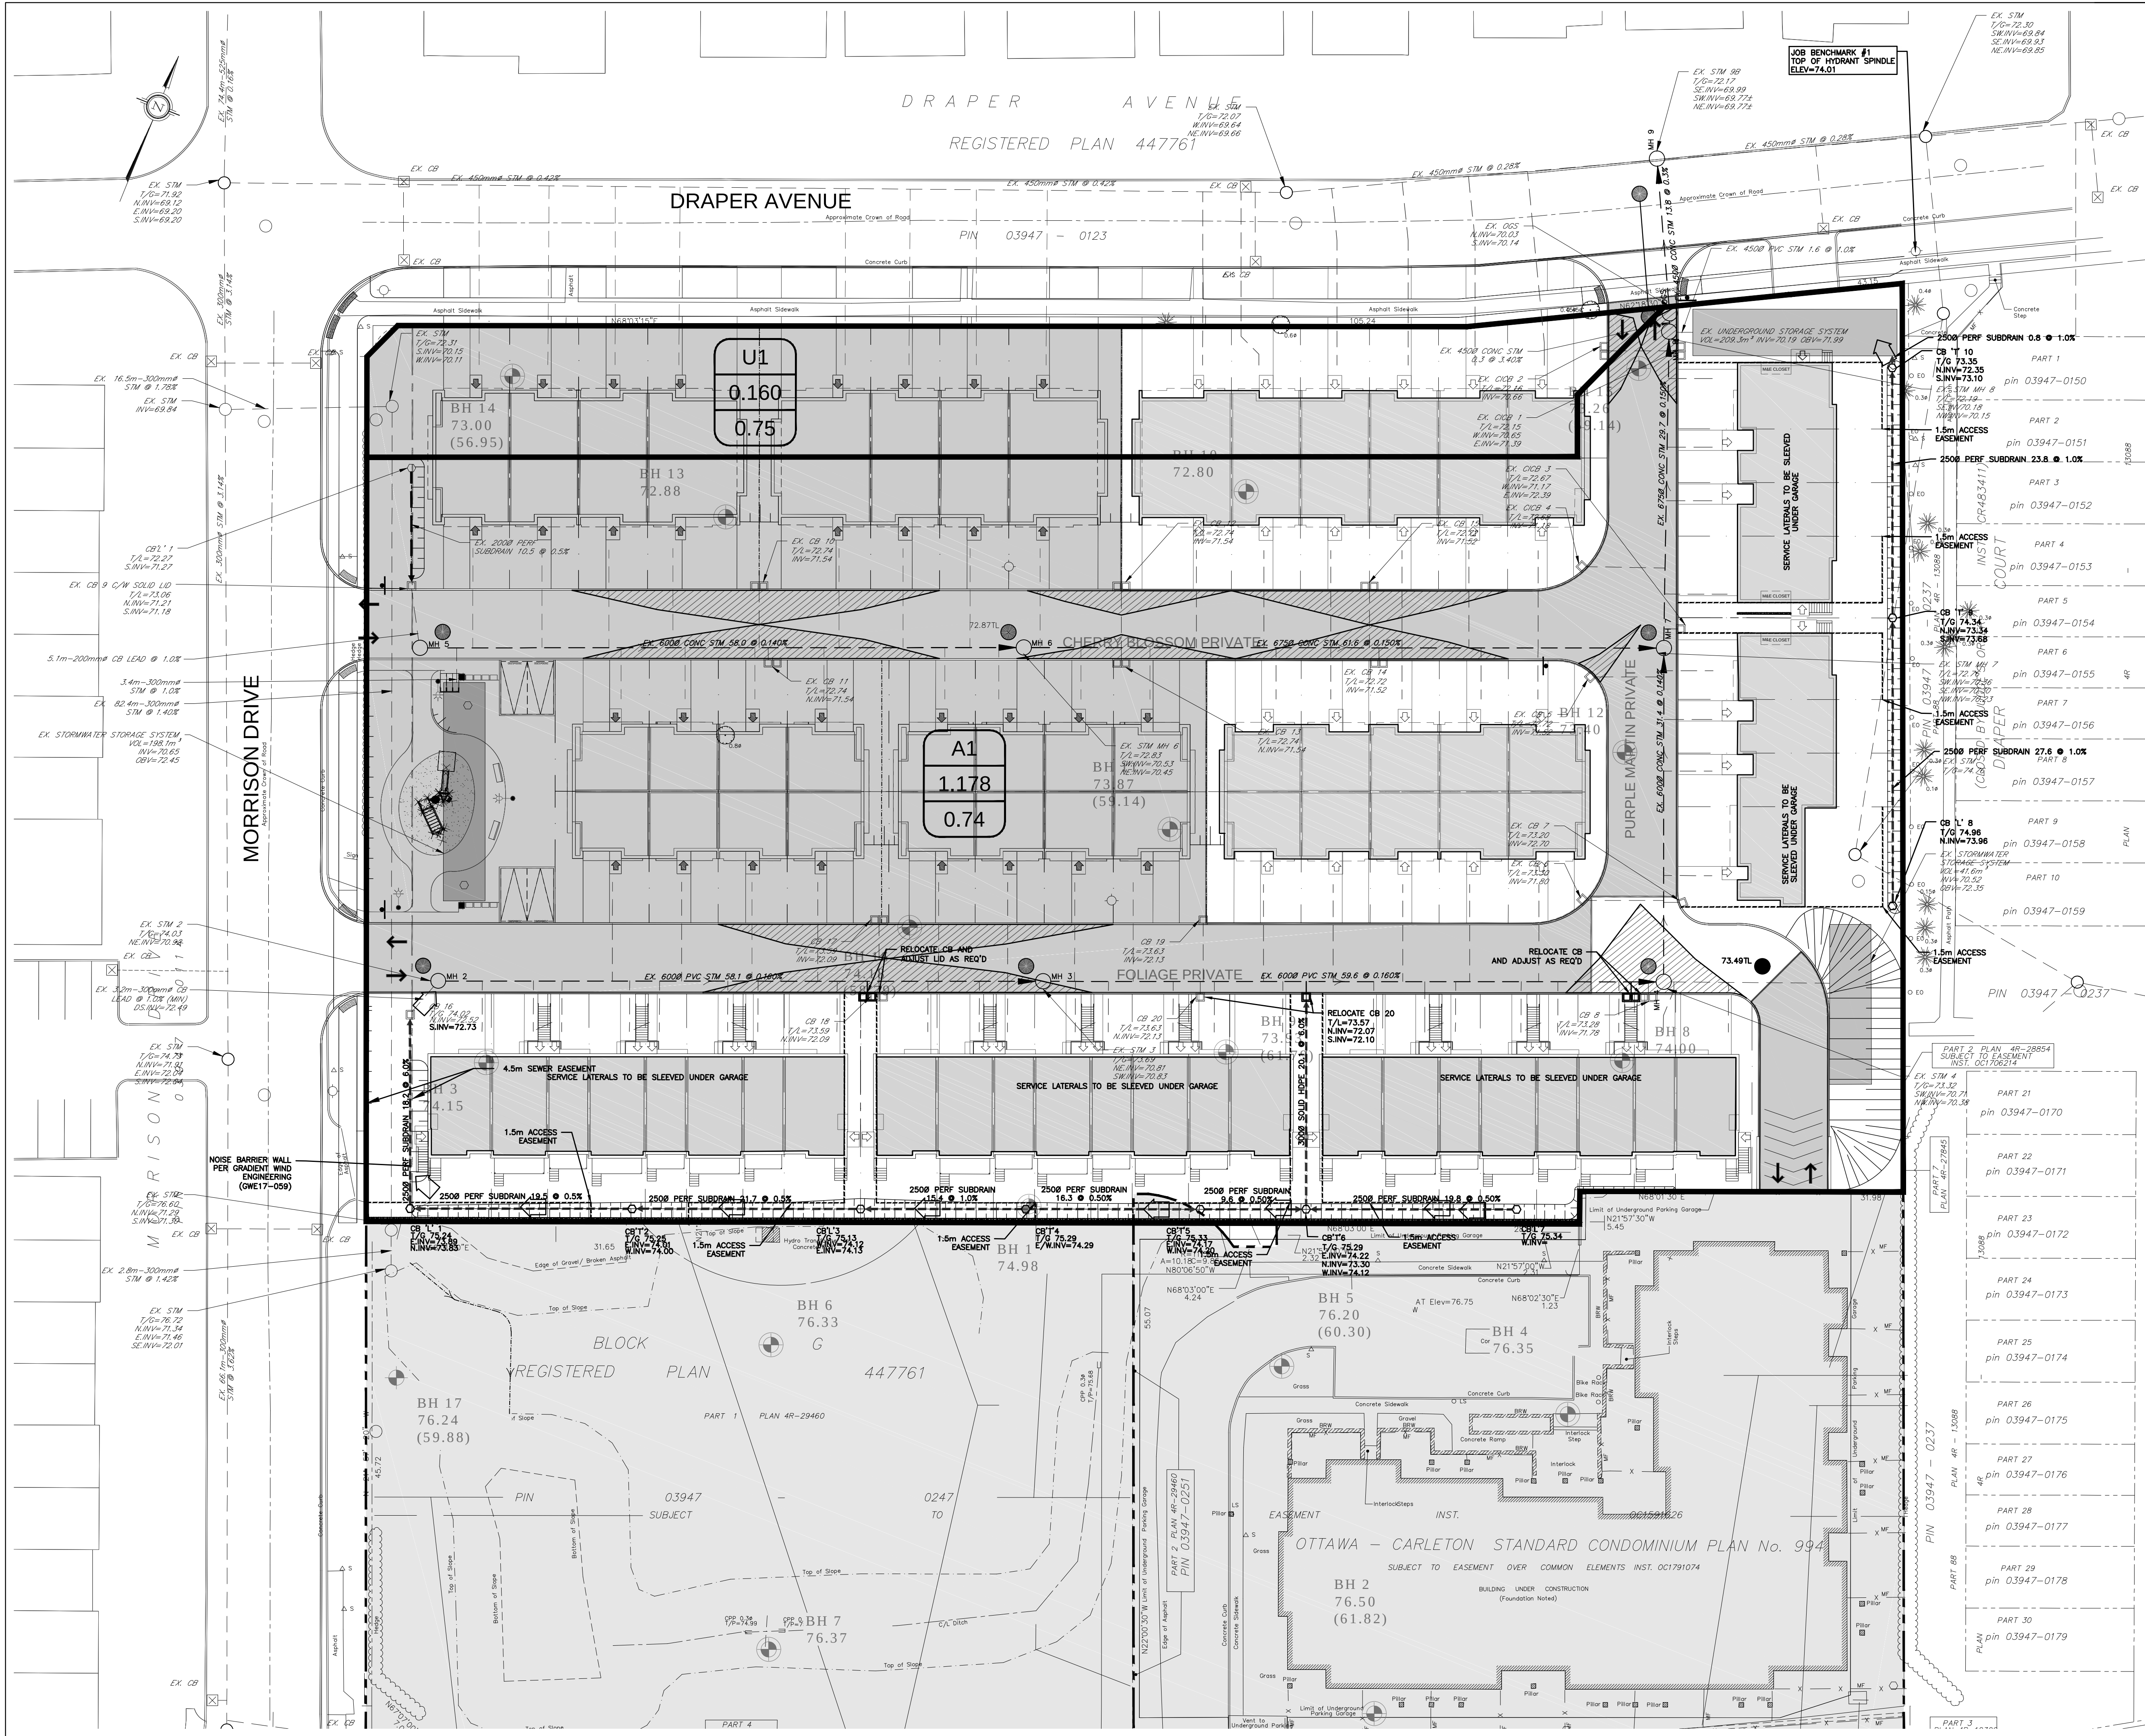

LEGEND

- PROPERTY LINE
- PROPOSED STORM SEWER
- DRAINAGE DIVIDE
- PROPOSED SWALE
- PROPOSED PERFORATED SUBDRAIN
- MAJOR SYSTEM FLOW ROUTE
- PROPOSED STORM MANHOLE
- PROPOSED CATCH BASIN
- PROPOSED CB "T" OR CB "L"

EX6
4.010
0.19

DRAINAGE AREA ID
AREA IN Ha
RATIONAL METHOD RUNOFF COEFFICIENT

NOT FOR CONSTRUCTION

TOPOGRAPHIC INFORMATION
TOPOGRAPHIC INFORMATION PROVIDED BY ANNIS, O'SULLIVAN, VOLLEBEKK LTD.
PROJ. NO. 19336-17
DATED MAY 16, 2017

SITE PLAN INFORMATION
SITE PLAN PROVIDED BY RODERICK LAHEY ARCHITECTS
PROJ. NO. 1020
ISSUED NOVEMBER 30, 2018

GEOTECHNICAL STUDY
GEOTECHNICAL RECOMMENDATIONS PROVIDED BY PATERSON GROUP INC.
PROJ. NO. PG1630-3
DATED SEPTEMBER 20, 2018 REVISION 6

SITE SERVICING AND STORMWATER MANAGEMENT STUDY
SERVICING AND STORMWATER MANAGEMENT RECOMMENDATIONS PROVIDED BY DSEL
DATED DECEMBER 2018

BENCHMARK
TOP OF FIRE SPINDLE LOCATED NORTH EAST OF THE SUBJECT SITE
ELEV=74.01m

1	A.J.G.	18.12.07	ISSUED FOR MUNICIPAL REVIEW
No.	BY	YY.MM.DD	DESCRIPTION

PROJECT No. 17-927

STORMWATER MANAGEMENT PLAN - SUBCATCHMENTS
FRESH TOWNS - 2710 DRAPER AVENUE PHASE 3-2 © DSEL

GREATWISE DEVELOPMENT
333 Wilson Avenue, Suite 200
Toronto, Ontario, M3H 1T2

DSEL
david schaeffer engineering ltd.
SMART SUBDIVISIONS™

120 Ibro Road Unit 103
Stittsville, Ontario, K2S 1E9
Tel. (613) 836-0856
Fax. (613) 836-1183
www.DSEL.ca

DRAWN BY: R.D.F. CHECKED BY: A.D.F. DRAWING NO. SHEET NO.
DESIGNED BY: A.J.G. CHECKED BY: R.D.F.
SCALE: 1:300 DATE: DECEMBER 2018 SWM-1 1 of 3