

REFER TO NOTES &
DETAILS ON DRAWING C-5


LEGEND

DRAINAGE AREA

AREA SIZE (sq.m.)

5-YEAR RUNOFF COEFFICIENT

7697
0.27

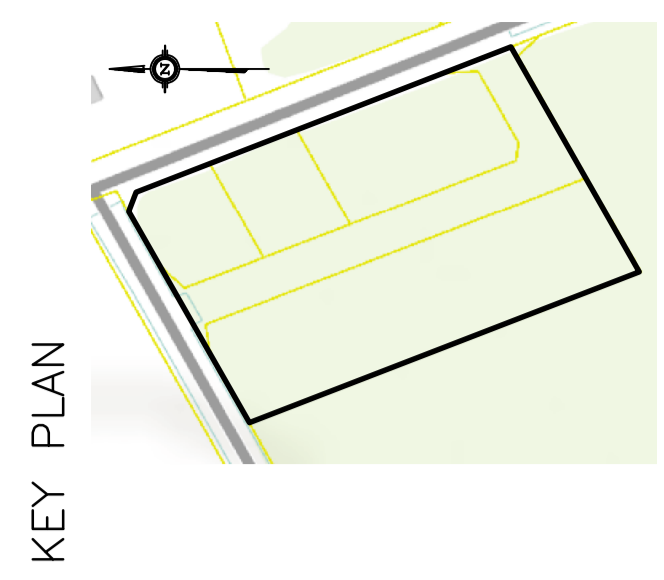

| No. | Date | REVISION |
|-----|-----------|----------------------------------|
| 3 | DEC 19-18 | ISSUED FOR APPROVAL |
| 2 | DEC 13-18 | ISSUED TO OSSO FOR SEPTIC PERMIT |
| 1 | JUN 9-18 | ISSUED FOR CLIENT REVIEW |

D. B. GRAY ENGINEERING INC.
 Professional Engineering & Planning - Storm & Sanitary Sewers - Estimation
 700 Long Point Circle
 Ottawa, Ontario K1T 4E9
 Tel: 613-425-8044
 dgray@engrs.com

**PROPOSED
CROSS DOCK FACILITY
MITCH OWENS ROAD /
BOUNDARY ROAD**
OTTAWA, ONTARIO

DRAINAGE PLAN

Engineer's Seal

PROFESSIONAL ENGINEER
D.B. GRAY
17016502
1997-19-18
NOT VALID UNLESS SIGNED & DATED

Drawn: D.B.G.
 Hdr. Scale: 1:400
 Vert. Scale:
 Date: JUN 9-18
 Job No.: 18029
 Drawing No.:
C-6
 of 6