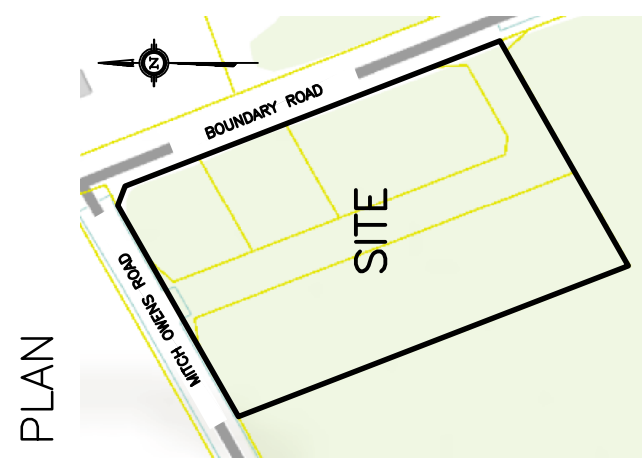


[illegible]

D. B. GRAY ENGINEERING INC.
Stormwater Management • Grading & Drainage • Storm & Sanitary Sewers • Hvac/roofs
7700 Long Point Circle
Ottawa, Ontario K1T 4E9
Tel: 613-425-8044
dbgray@rogers.com

PROPOSED
CROSS DOCK FACILITY
MITCH OWENS ROAD /
BOUNDARY ROAD
OTTAWA, ONTARIO


rawing Title

GRADING PLAN

Engineer's Seal

Drawn	D.B.G.
Hor. Scale	1:400
Vert. Scale	
Date	JUN 9-18
Job No.	18029

Drawing No.
C-1
of 6

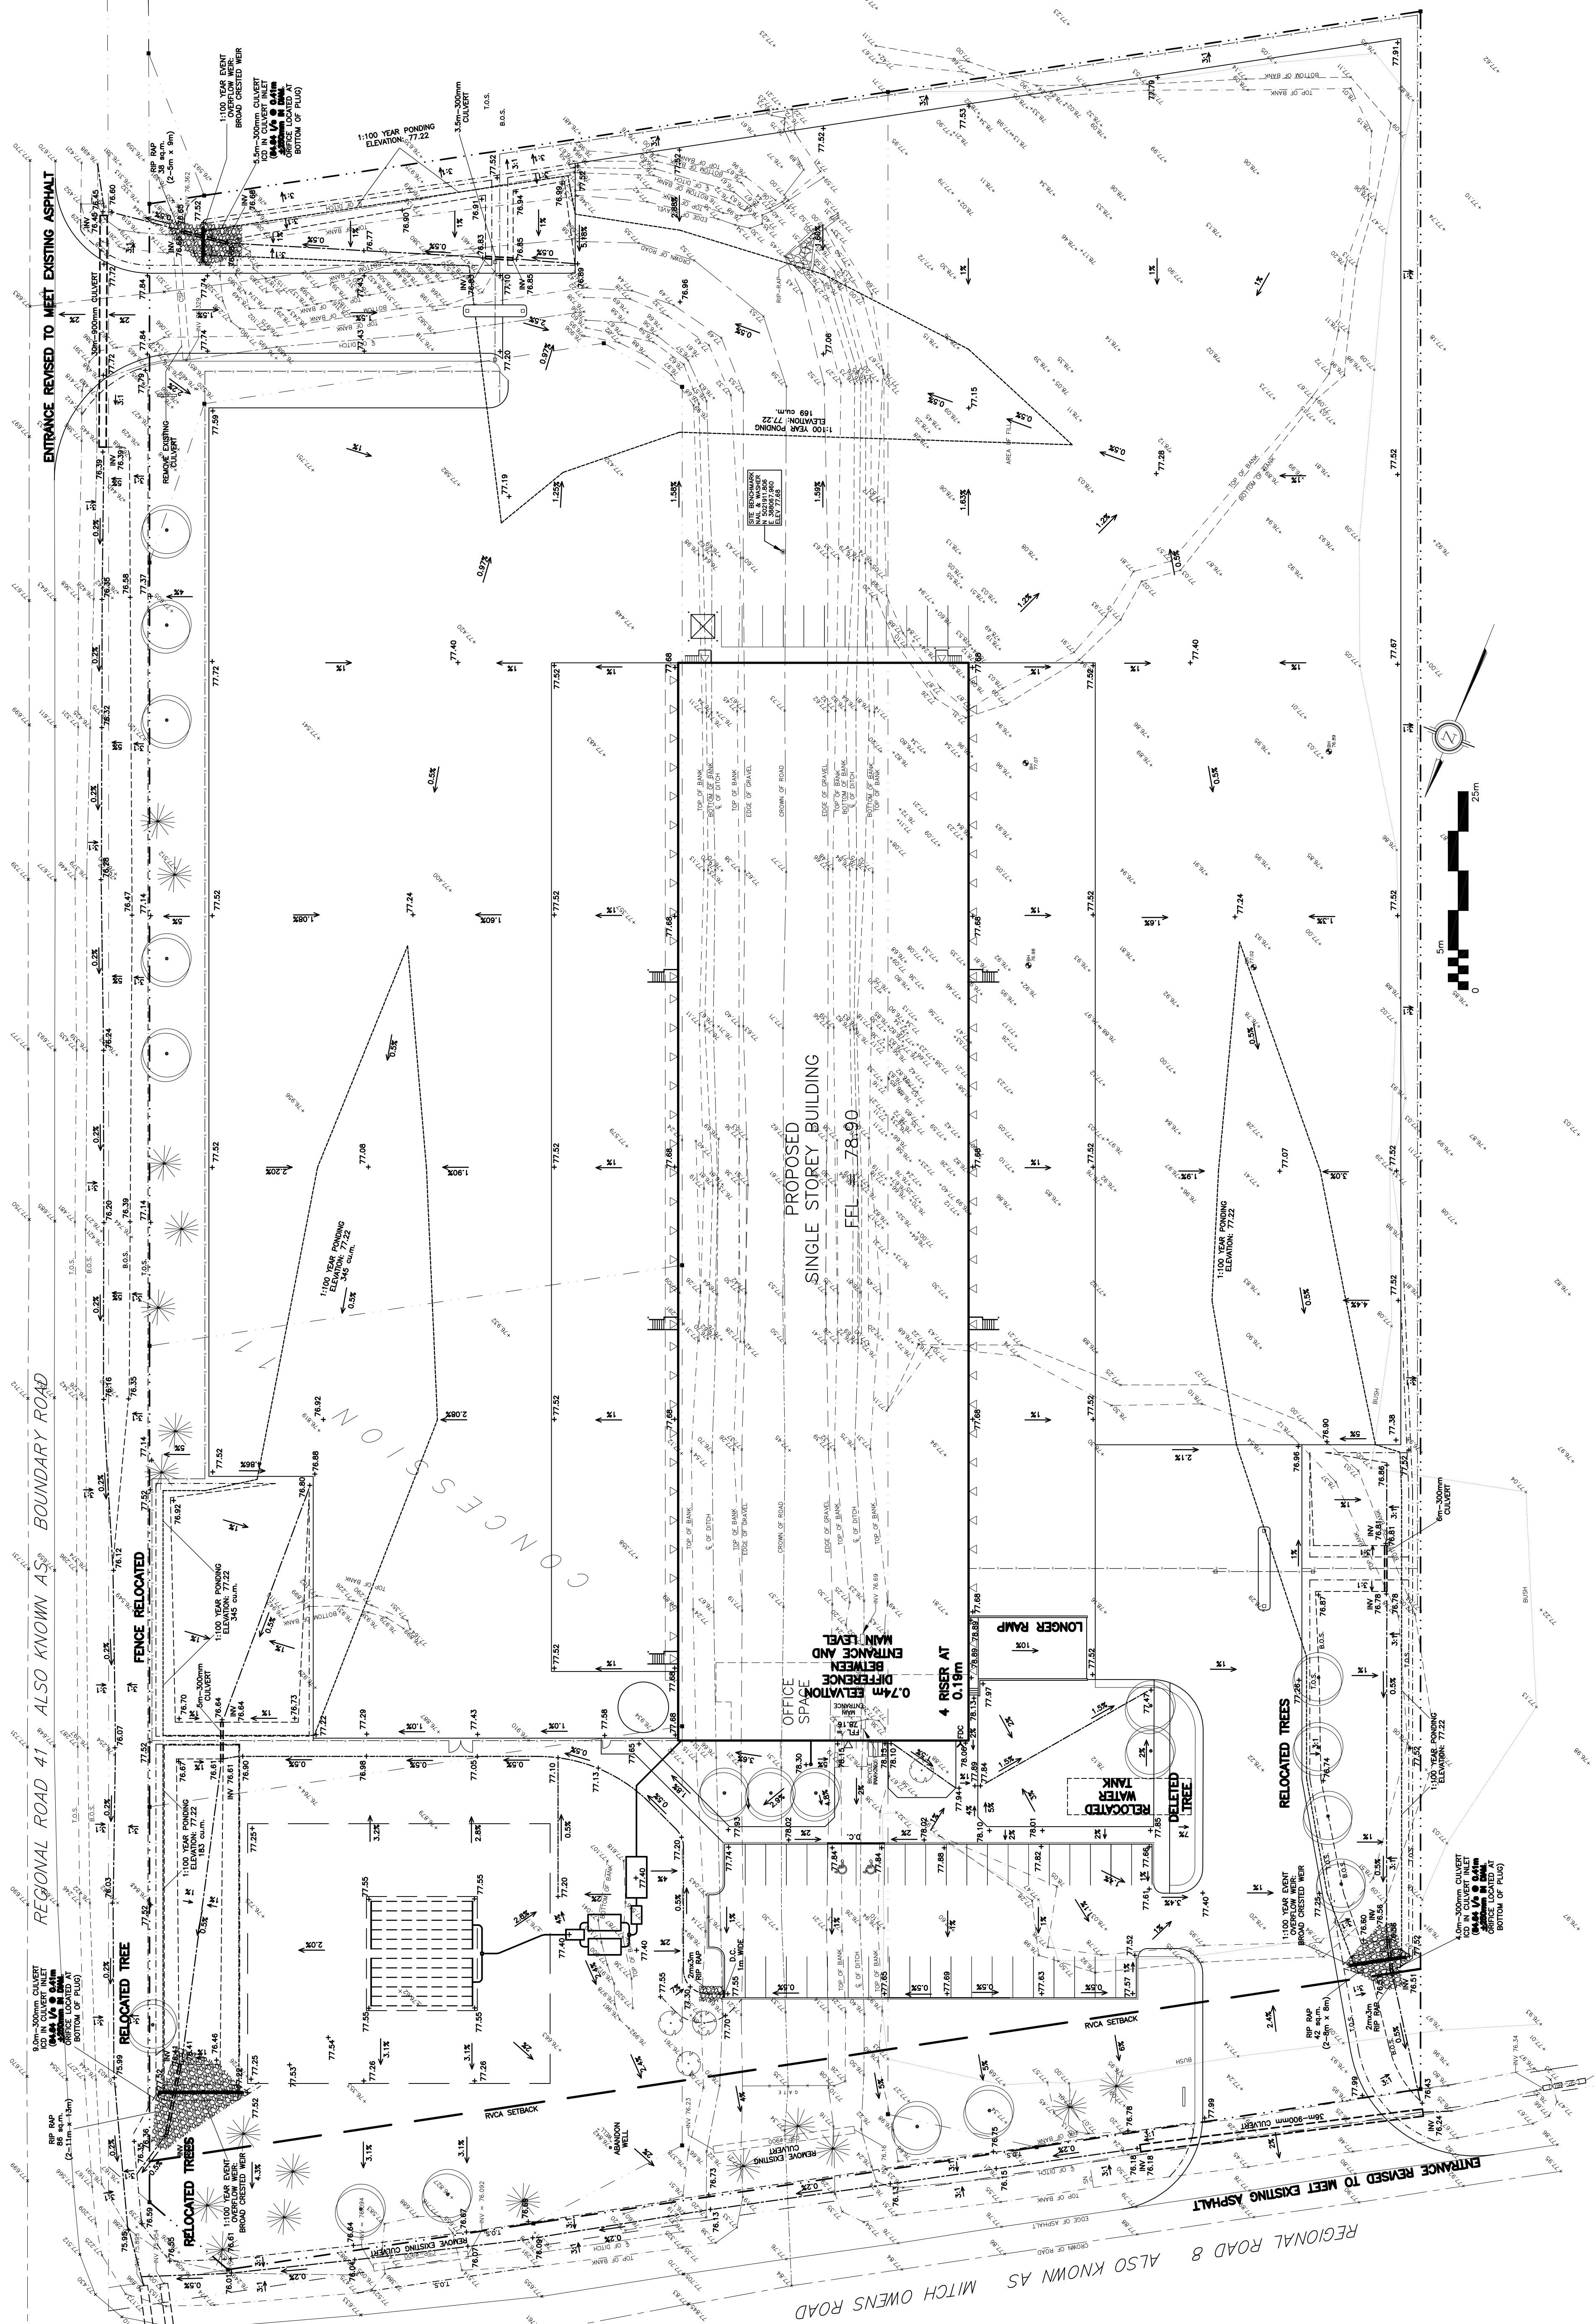

REFER TO NOTES &
DETAILS ON DRAWING C-5