

11			
10			
09			
08			
07			
06			
05			
04			
03	ISSUED FOR REVIEW	PE	JAN 24 2019
02	ISSUED FOR COORDINATION	PE	JAN 16 2019
01	ISSUED FOR COORDINATION	PE	SEPT 10 2018
No.	REVISIONS	BY	DATE

NOT AUTHENTIC UNLESS SIGNED AND DATED

CONSULTING ENGINEERS

STRUCTURAL

MECHANICAL

ELECTRICAL

DESIGNED BY: P.E.

DRAWN BY:

APPROVED BY: P.E.

PROJECT

99 PINHEY

DRAWING TITLE


LOWER & MAIN LEVEL FLOOR PLANS

PROJECT NO. 0293


DATE JAN 24, 2019

A-1

PLAN #17795

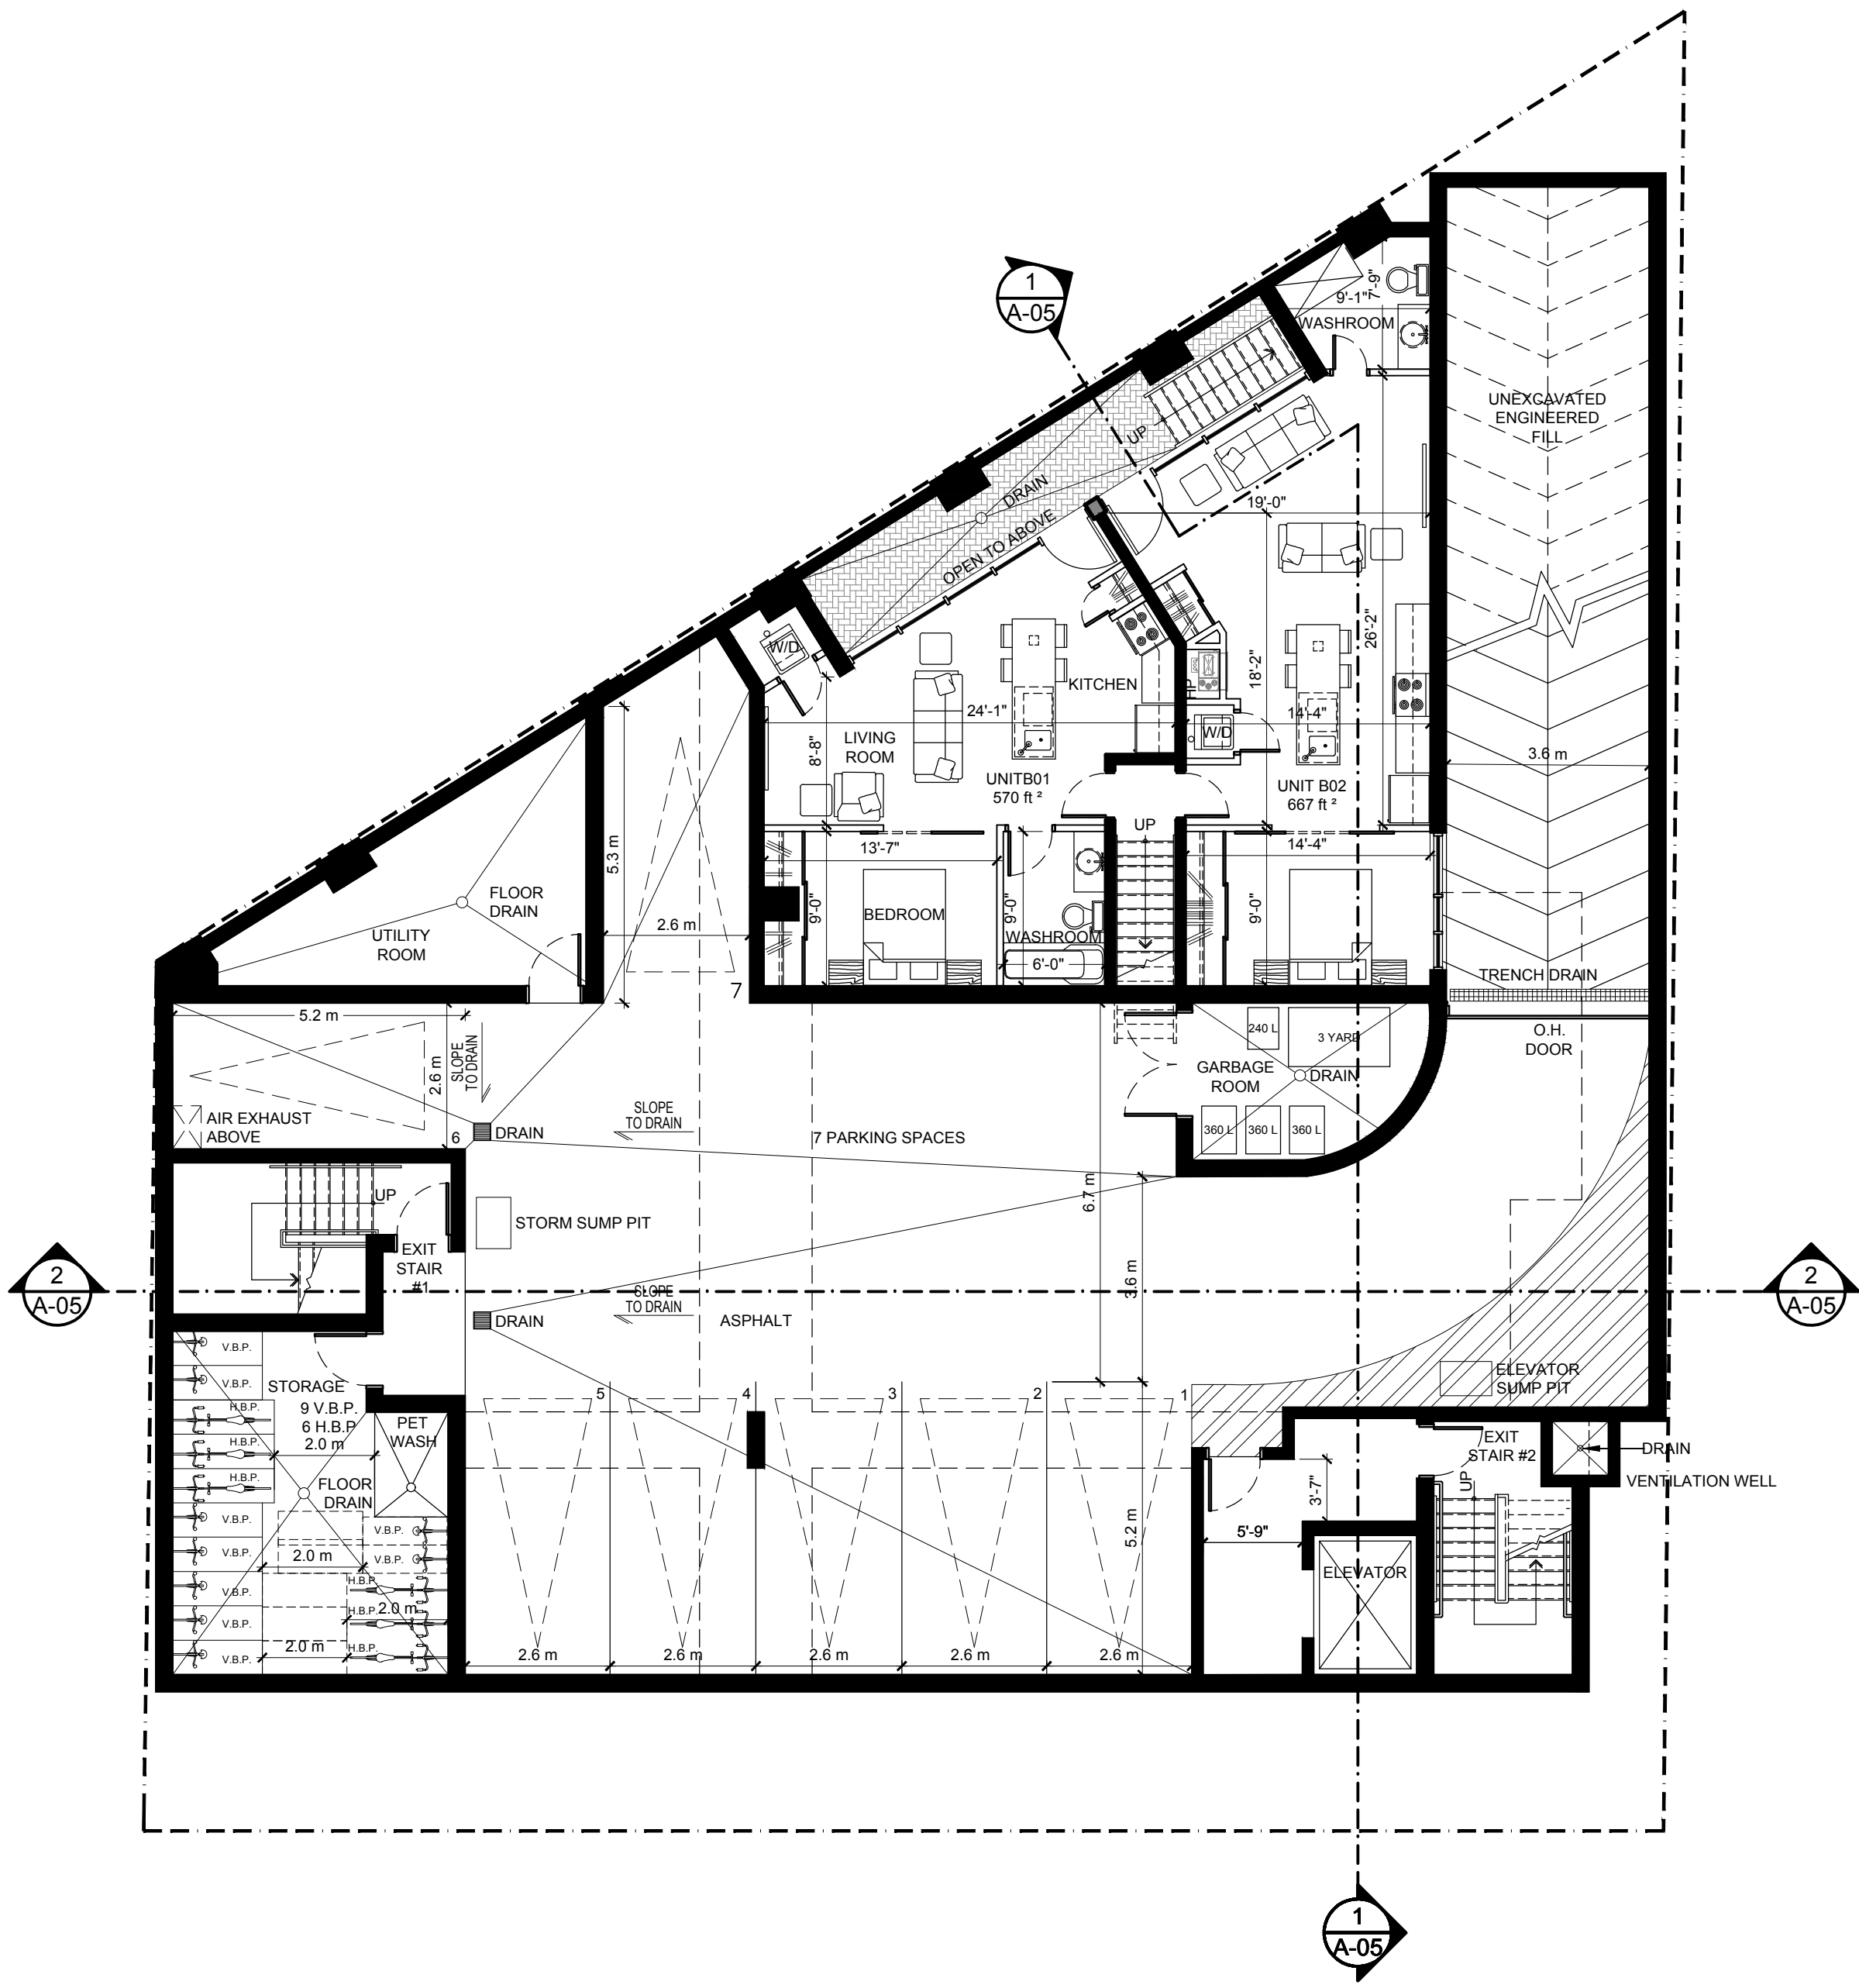

1 LOWER LEVEL FLOOR PLAN
A-1 SCALE: 1:100

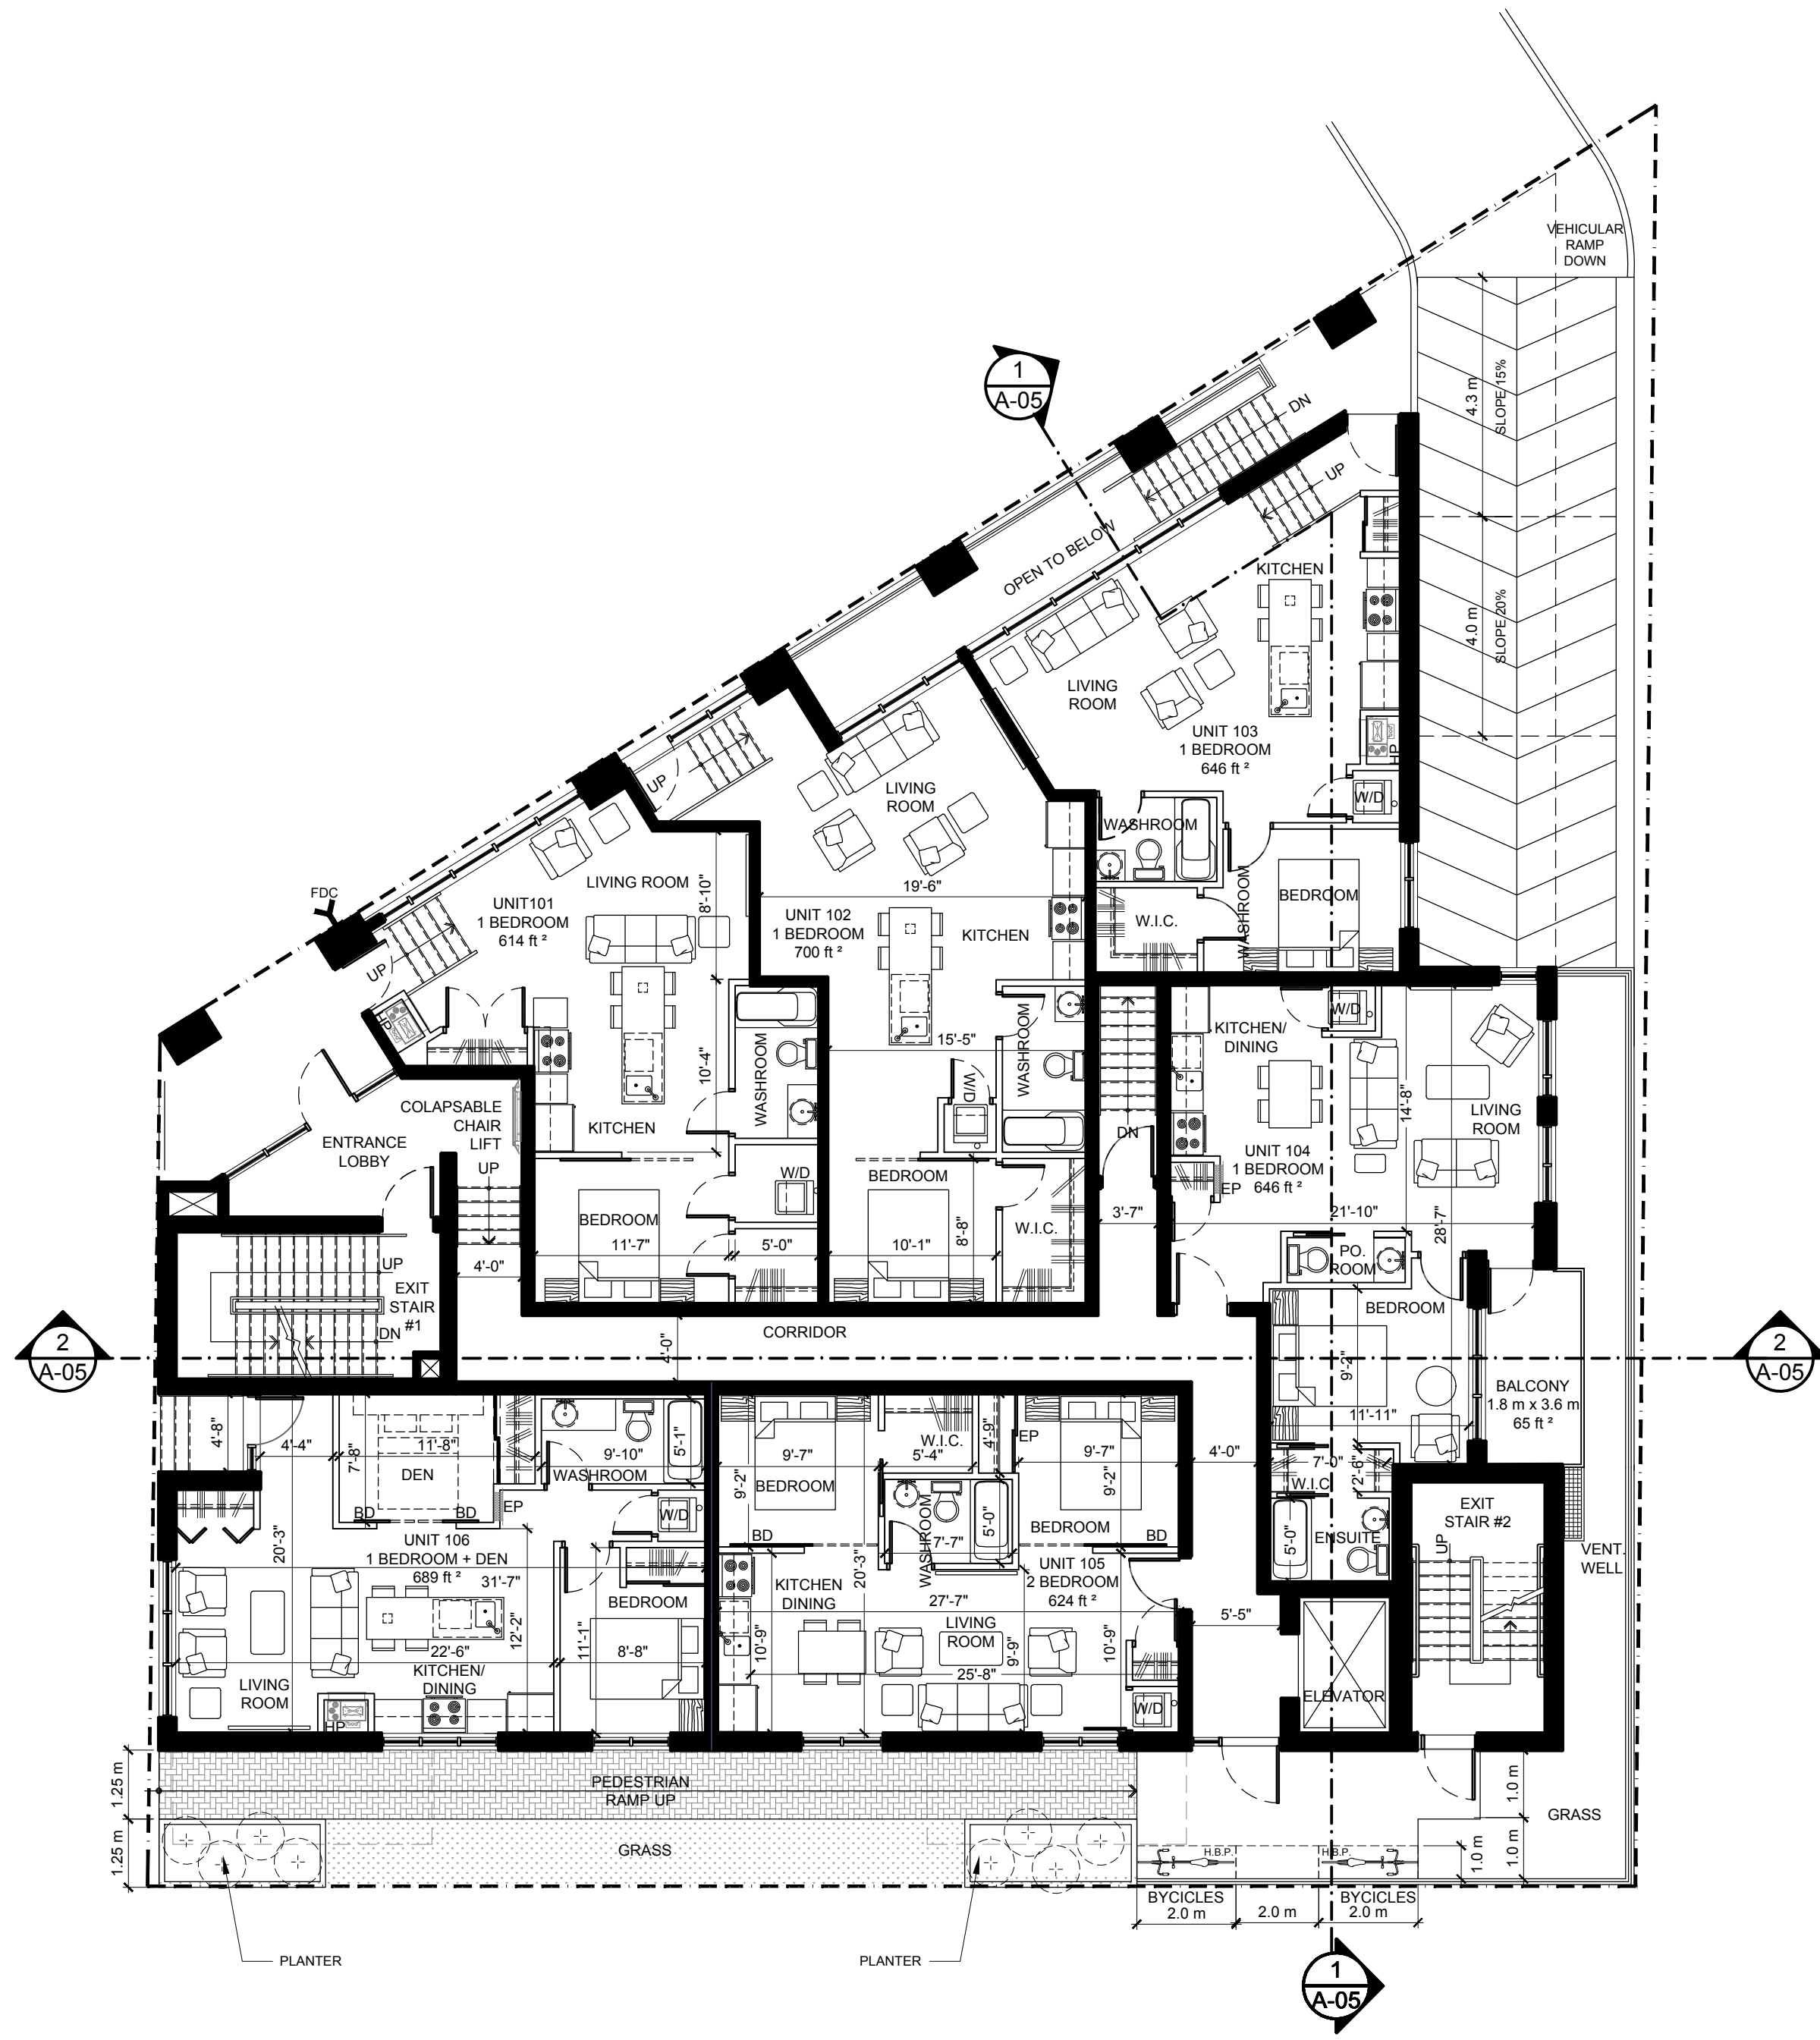

2 MAIN LEVEL FLOOR PLAN
A-1 SCALE: 1:100

D07-12-17-0102