



\\01\4501\c500\14501\451\Selection\Renaste - Orleans\design\drawing\C500 STORM DRAINAGE PLAN.dwg
2017/03/23 4:25 PM By: Stantec Mike

ORIGINAL SHEET - A1

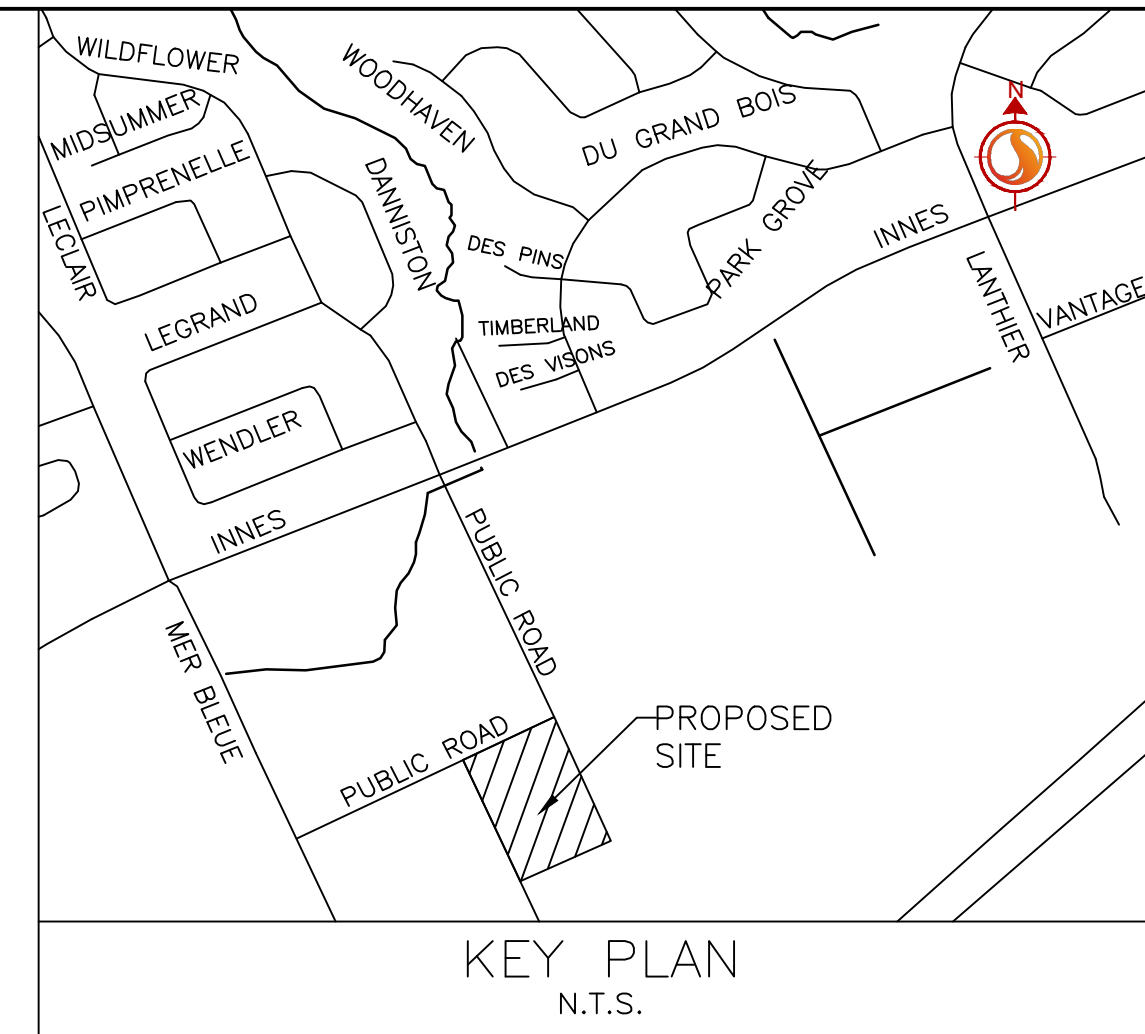

SCHEDULE OF INLET CONTROL DEVICES				
AREA ID	STRUCTURE ID	TYPE	100YR HEAD (m)	100YR RELEASE RATE (l/s)
PRKG	STM1001	130mm VERTICAL SLIDING ORPICE	1.53	44.4
PRKG	CBMH1003	125mm VERTICAL SLIDING ORPICE	1.70	43.2

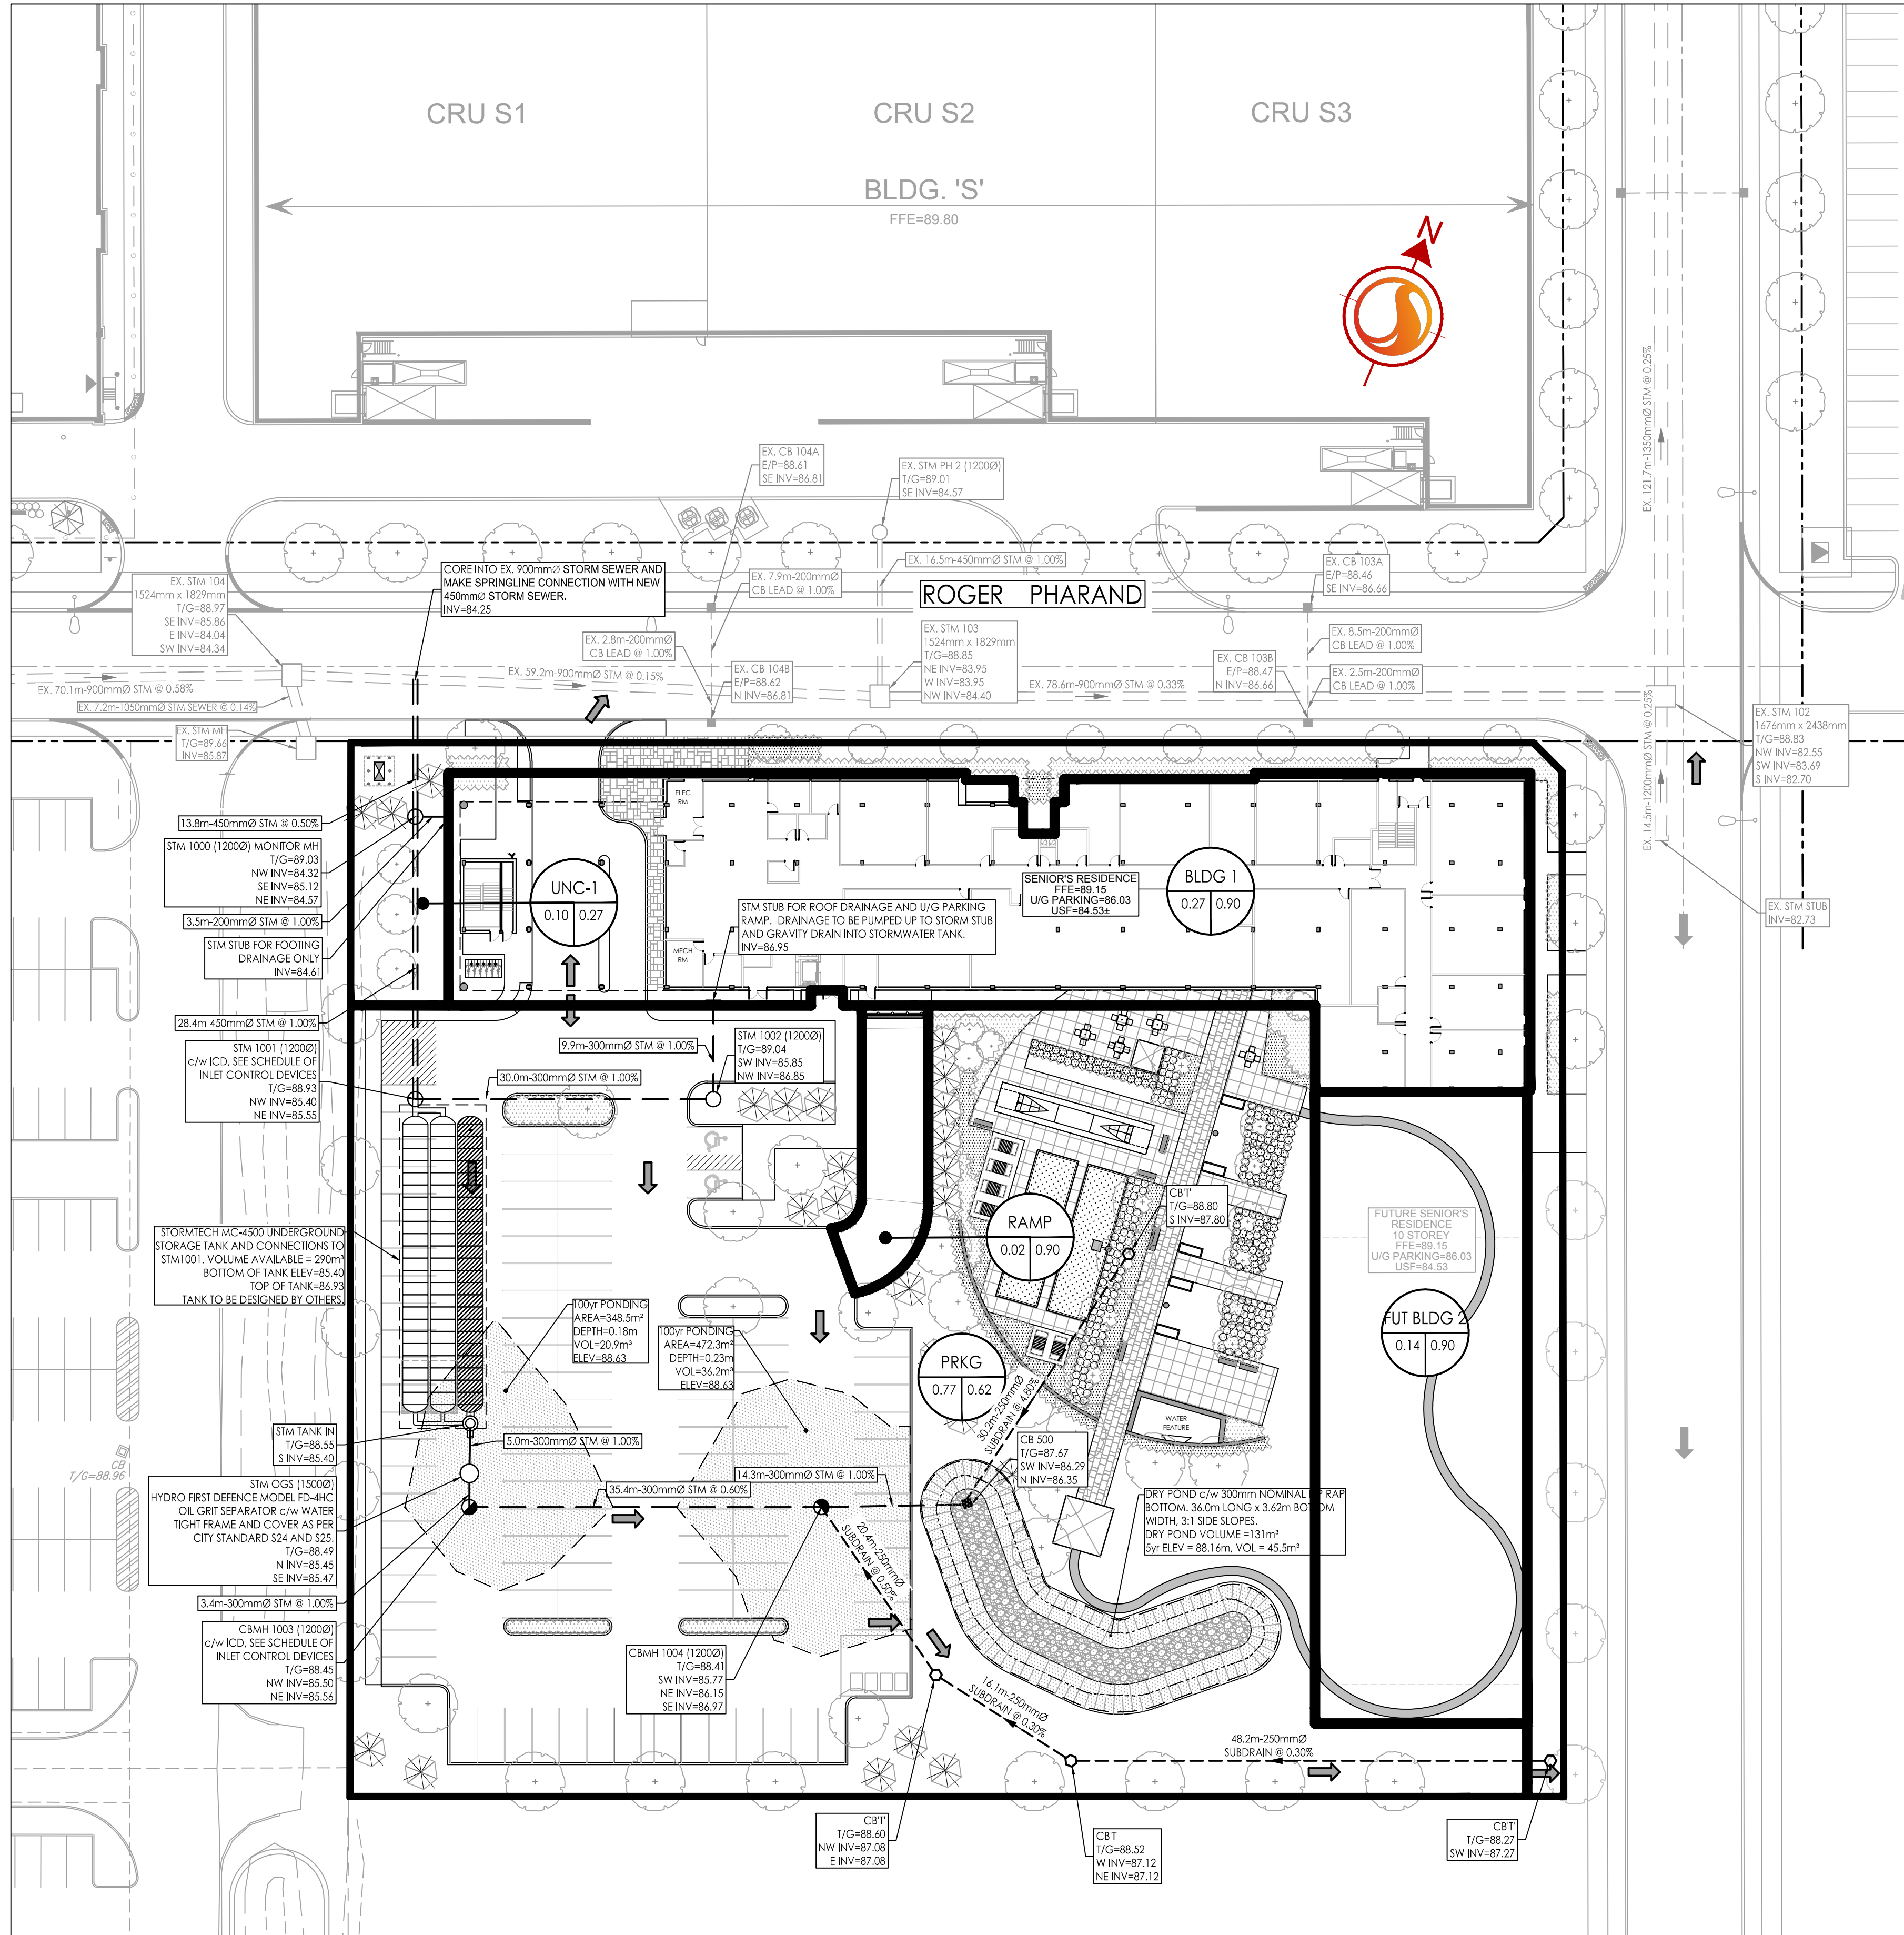

Stantec Consulting Ltd.
400 - 1331 Clyde Avenue
Ottawa ON
Tel. 613.722.4420
www.stantec.com


Copyright Reserved

The Contractor shall verify and be responsible for all dimensions. DO NOT scale the drawing - any errors or omissions shall be reported to Stantec without delay.
The Copyrights to all designs and drawings are the property of Stantec. Reproduction or use for any purpose other than that authorized by Stantec is forbidden.

Consultants



Legend

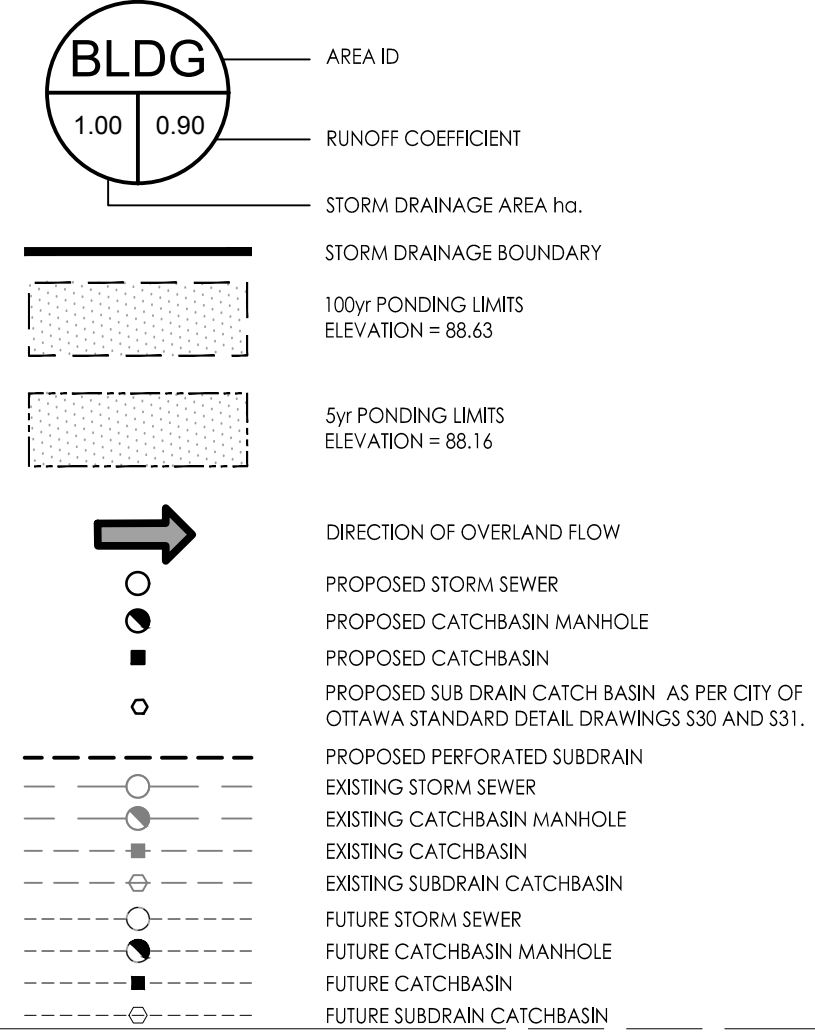

1	REVISED AS PER CITY COMMENTS	MJS	DT	19.03.26
0	ISSUED TO CITY FOR SPA	MJS	DT	18.11.23

Revision By Appd. YY.MM.DD

File Name:	C500 STORM DRAINAGE PLAN.dwg	MJS	KS	MJS	18.11.13
		Dwn.	Chkd.	Dsgn.	YY.MM.DD

Permit-Seal

Client/Project
RÉSEAU SÉLECTION DÉVELOPPEMENT
HORS QUÉBEC INC.
2400 BOUL DANIEL JOHNSON
LAVAL, QUÉBEC H7T 3A4
RÉSEAU SÉLECTION ORLÉANS
SENIOR'S RESIDENCE
OTTAWA, ON

Title
STORM DRAINAGE PLAN

Project No.	160401451	Scale	0 4 12 20m 1:400
Drawing No.	Sheet	Revision	1

C500 5 of 6 1 PLAN# 17819

D07-12-18-0179