


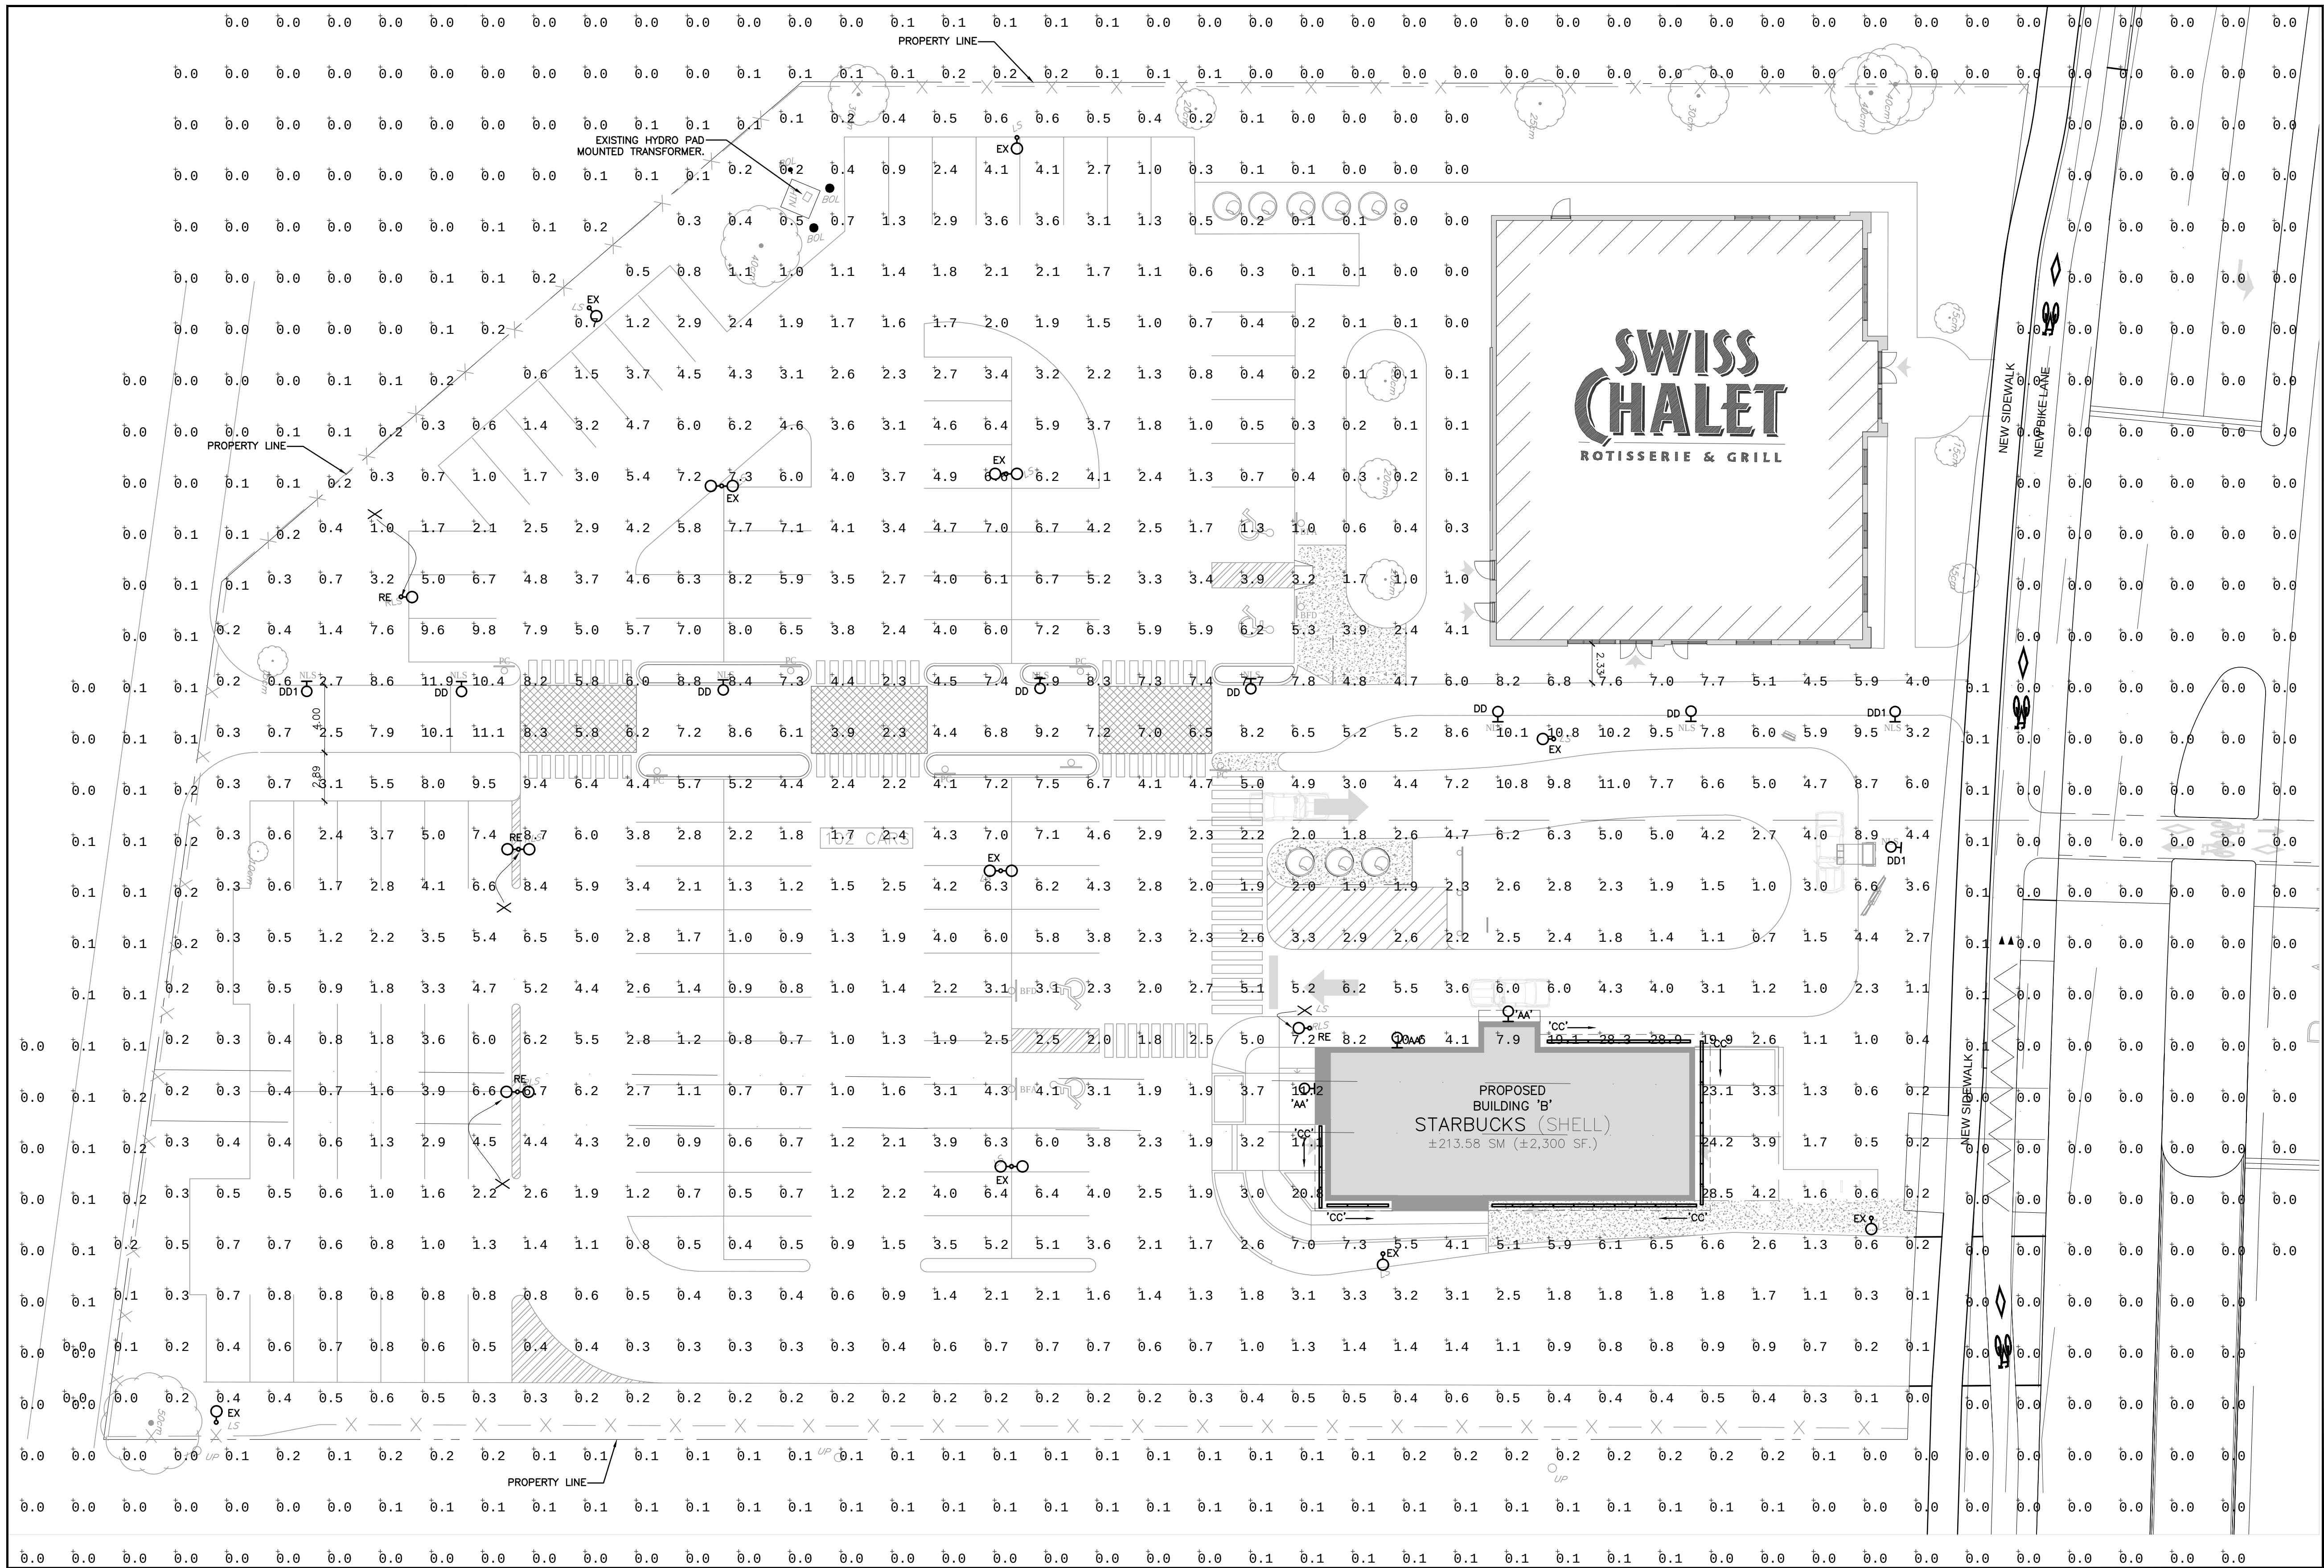


1 SITE PLAN
SPA SCALE: 1 :200

Luminaire Schedule								
Scene: Street light								
Symbol	Qty	Label	Arrangement	Total Lamp Lumens	LLF	Description	Tag	Lum. Watts Lum. Lumens
	7	EH14-FM-150PSMH	SINGLE	12500	0.850	EH14-FM-150PSMH	EX (EXISTING)	185 7337
	6	EH14-FM-150PSMH-2H	BACK-BACK	12500	0.850	EH14-FM-150PSMH	EX (EXISTING)	185 7337
	3	XTOR3B-W	SINGLE	N.A.	0.900	XTOR3B-W	AA	25.5 2710
	32	VIA5-AR02-LED-80-375-35-4FT	SINGLE	N.A.	0.900	VIA5-AR02-LED-80-375-35-4FT	CC	11.13 1499
	3	2MB-E	SINGLE	5588	0.900	For use with Series E Edge, Edge High Output	DD1	66 5588
	6	5S-E	SINGLE	12806	0.900	For use with Series E Edge, Edge High Output	DD	132.4 12806
	1	EH14-1-150PSMH_1	SINGLE	12500	0.850	EH14-1-150PSMH	EX (EXISTING)	185 8800

Calculation Summary								
Scene: Street light								
Label	CalcType	Units	Avg	Max	Min	Avg/Min	Max/Min	
Beyond Property Line	Illuminance	Fc	0.03	0.2	0.0	N.A.	N.A.	
Site Plan Overall	Illuminance	Fc	3.25	28.8	0.0	N.A.	N.A.	

NOTES:
ALL LIGHTING FIXTURES ARE FULLY CUT OFF

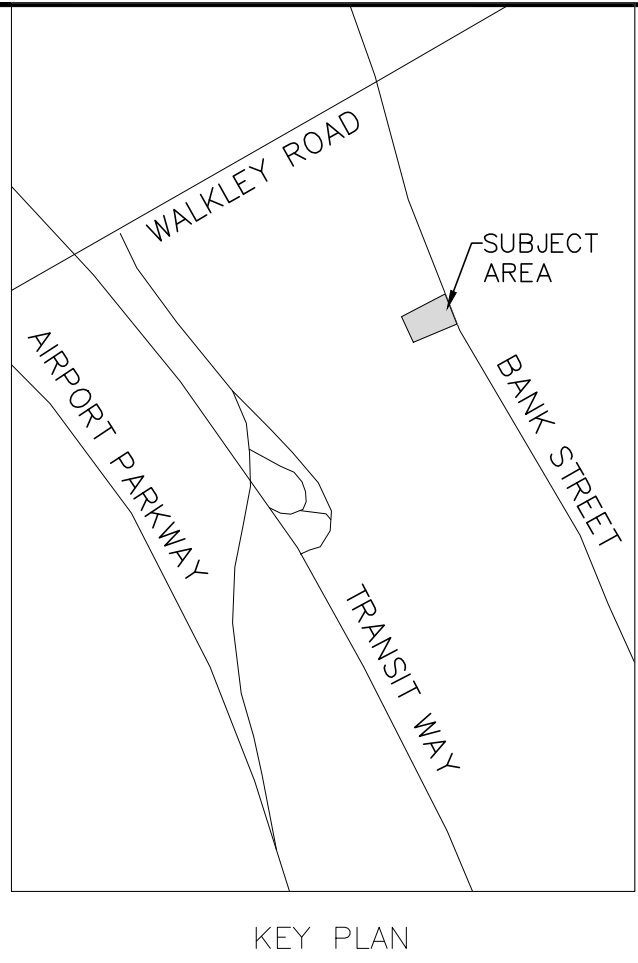

NO	BY	DESCRIPTION	DATE
2	Q.V.	REVISED PER CITY COMMENTS	26.APR.2019
1	Q.V.	ISSUED FOR SPA	23.NOV.2018

REVISIONS

CONTRACTOR SHALL CHECK AND VERIFY
ALL DIMENSIONS ON SITE
DO NOT SCALE DRAWINGS

HAMMERSCHLAG & JOFFE INC.

69 Lesmill Road, Toronto, Ontario
Canada M3B 2T8
T: (416) 444-9263
F: (416) 444-1463
E: dwg@hamjof.com

PROJECT PROPOSED REDEVELOPMENT AT
1910 BANK STREET
STARBUCKS

1910 BANK STREET OTTAWA, ON

DRAWING TITLE

**ELECTRICAL
SITE PLAN**

DESIGNED BY	B.B.	COMM. NO.	18-085-014
CHECKED	Q.V./B.B.	DRAWING NO.	
SCALE	1 : 200		
DATE	OCTOBER 2018		

SPA