


LEGEND

- SB - STANDARD IRON BAR
- CB - CATCH BASIN
- MB - MANHOLE
- WMH - WATER MANHOLE
- LS - LAMP STANDARD
- UP - UTILITY POLE
- WV - WATER VALVE
- FH - FIRE HYDRANT
- W - WELL
- GA - GUY WIRE AND ANCHOR
- OW - OVERHEAD UTILITY WIRES
- UH - UNDERGROUND HYDRO
- UB - UNDERGROUND BELL
- GM - GAS MAIN
- C - CABLE (ROGERS)
- SL - STREET LIGHT
- SS - STORM SEWER
- CS - CURB
- PC - PROPOSED CURB
- PW - PROPOSED WATERMAIN
- PS - PROPOSED STORM SEWER
- PSW - PROPOSED SANITARY SEWER
- PSM - PROPOSED SANITARY MANHOLE
- PSMH - PROPOSED STORM MANHOLE
- PSMCH - PROPOSED STORM CATCHBASIN MANHOLE
- PSFC - PROPOSED FIRE HYDRANT
- PSV - PROPOSED VALVE & VALVE BOX
- PSSC - PROPOSED SIAMESE CONNECTION
- PSMTR - PROPOSED WATER METER
- PSRMTM - PROPOSED REMOTE WATER METER
- PHDP - PROPOSED HEAVY DUTY PAVEMENT
- PLDP - PROPOSED LIGHT DUTY PAVEMENT
- PCSW - PROPOSED CONCRETE SIDEWALK

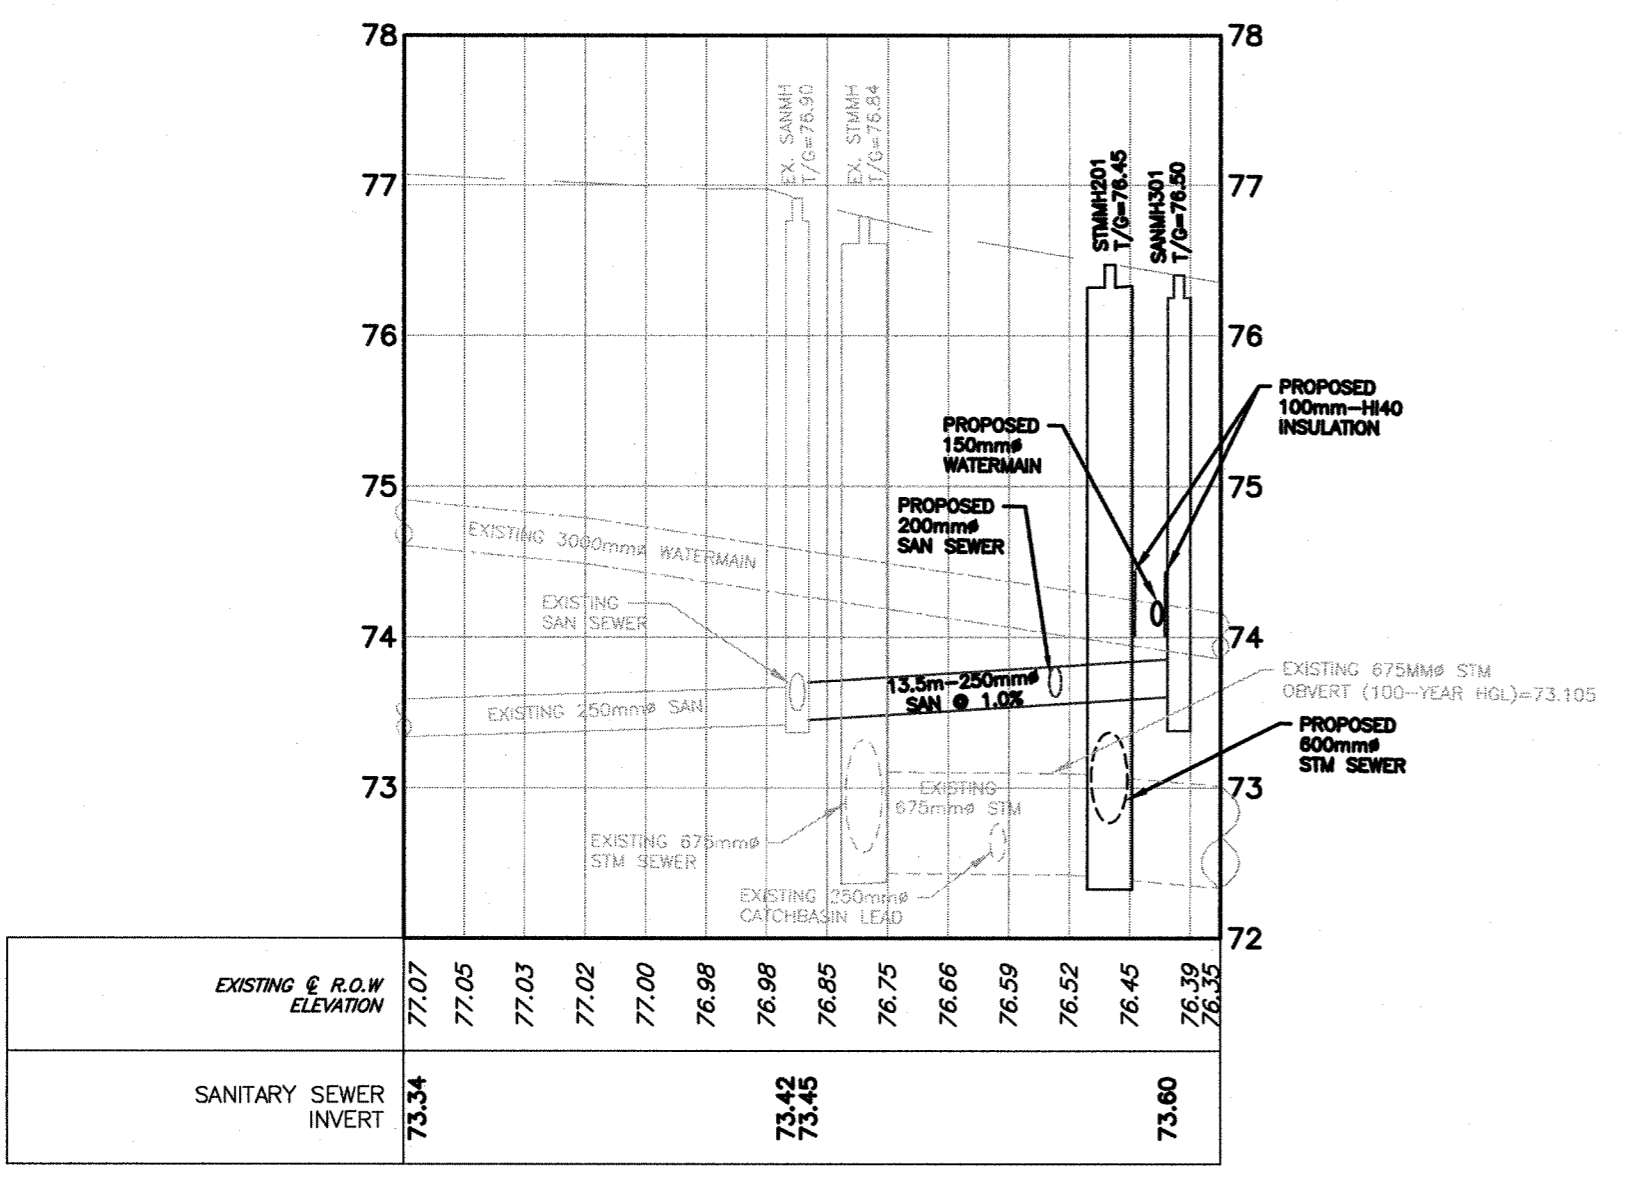

SANDHILL ROAD SANITARY EXTENSION
SCALE: HORIZ 1:250 VERT 1:50



Derrick Moodie

DERRICK MOODIE
MANAGER
PLANNING, INFRASTRUCTURE & ECONOMIC
DEVELOPMENT DEPARTMENT, CITY OF OTTAWA

APPROVED
By Derrick Moodie at 10:48 am, Jun 12, 2019

CAUTION
THE POSITION OF ALL POLE LINES, CONDUITS, WATERMANS, SEWERS AND OTHER UNDERGROUND AND OVERGROUND UTILITIES AND STRUCTURES IS NOT NECESSARILY SHOWN ON THE CONTRACT DRAWINGS, AND WHERE SHOWN, THE ACCURACY OF THE POSITION OF SUCH UTILITIES AND STRUCTURES IS NOT GUARANTEED. BEFORE STARTING WORK, DETERMINE THE EXACT LOCATION OF ALL SUCH UTILITIES AND STRUCTURES AND ASSUME ALL LIABILITY FOR DAMAGE TO THEM.

NO.	REVISION DESCRIPTION	DATE	BY	APPD
3	REVISED AS PER CITY COMMENTS	16/04/19	AE	AA
2	REVISED AS PER CITY COMMENTS	19/02/19	AE	AA
1	ISSUED FOR SITE APPLICATION	02/11/18	AE	AA

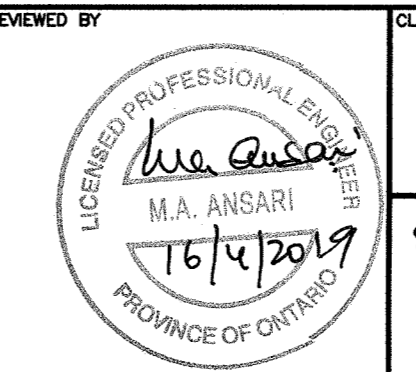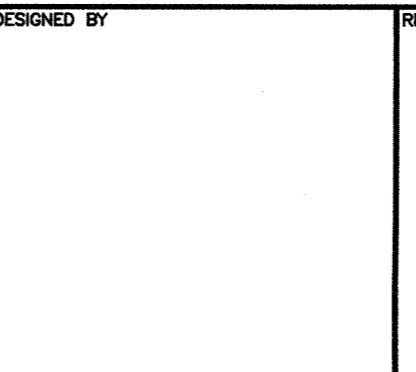

CLIENT: **KANATA MUSLIM ASSOCIATION**
832 MARCH ROAD, OTTAWA, ON.
K2W 0C9
613.973.5000

exp. **exp. Services Inc.**
1-813-688-1811 • 1-813-225-7330
2850 Queenway Drive, Unit 100
Ottawa, ON K2B 9R9
www.exp.com

• BUILDINGS • EARTH & ENVIRONMENT • ENERGY •
• INDUSTRIAL • INFRASTRUCTURE • SUSTAINABILITY •

DESIGN	AE	PROJECT	KMA MOSQUE AND COMMUNITY CENTRE 351 SANDHILL ROAD, OTTAWA, ON
CHECKED	AE	TITLE	MUNICIPAL SANITARY EXTENSION PLAN AND PROFILE
CAD	AE	PROJECT NO.	OTT-00238504-A0
PROJECT MANAGER	AA	SURVEY	F M & W
APPROVED	AA	DATE	2018-11-12
		DRAWING NO.	PP