



LEGEND

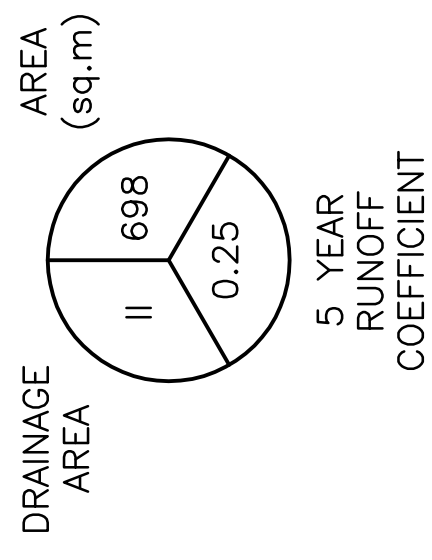

KEY PLAN

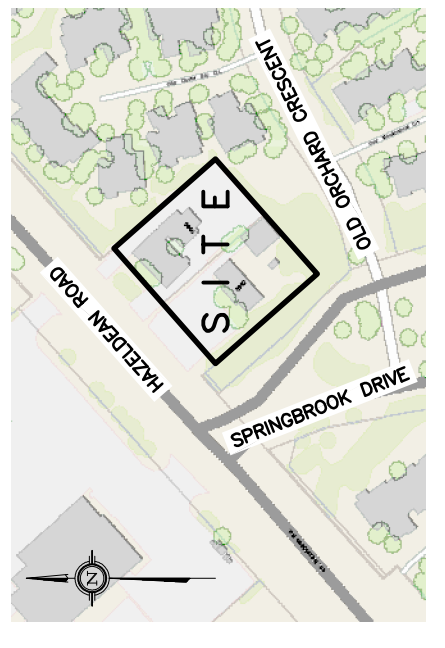

No.	DATE	REVISION
2	SEP 5-19	ISSUED FOR APPROVAL
1	AUG 30-19	ISSUED FOR COORDINATION


D. B. GRAY ENGINEERING INC.
Stormwater Management - Grading & Drainage - Sewer & Sanitary Sewer - Stormwater
 700 Long Point Circle
 Ottawa, Ontario
 613-425-8044
 d.gray@dbgrayengineering.com

PROPOSED MIXED-USE BUILDING
 5986-5992 HAZELDEAN RD
 OTTAWA, ONTARIO

DRAINAGE PLAN

Engineer's Seal

 Drawn: D.B.G.
 Hor. Scale: 1:250
 Vert. Scale:
 Date: AUG 30-19
 Job No.: 19042
 Drawing No.: **C-6**
 of **6**
 NOT VALID UNLESS SIGNED & DATED

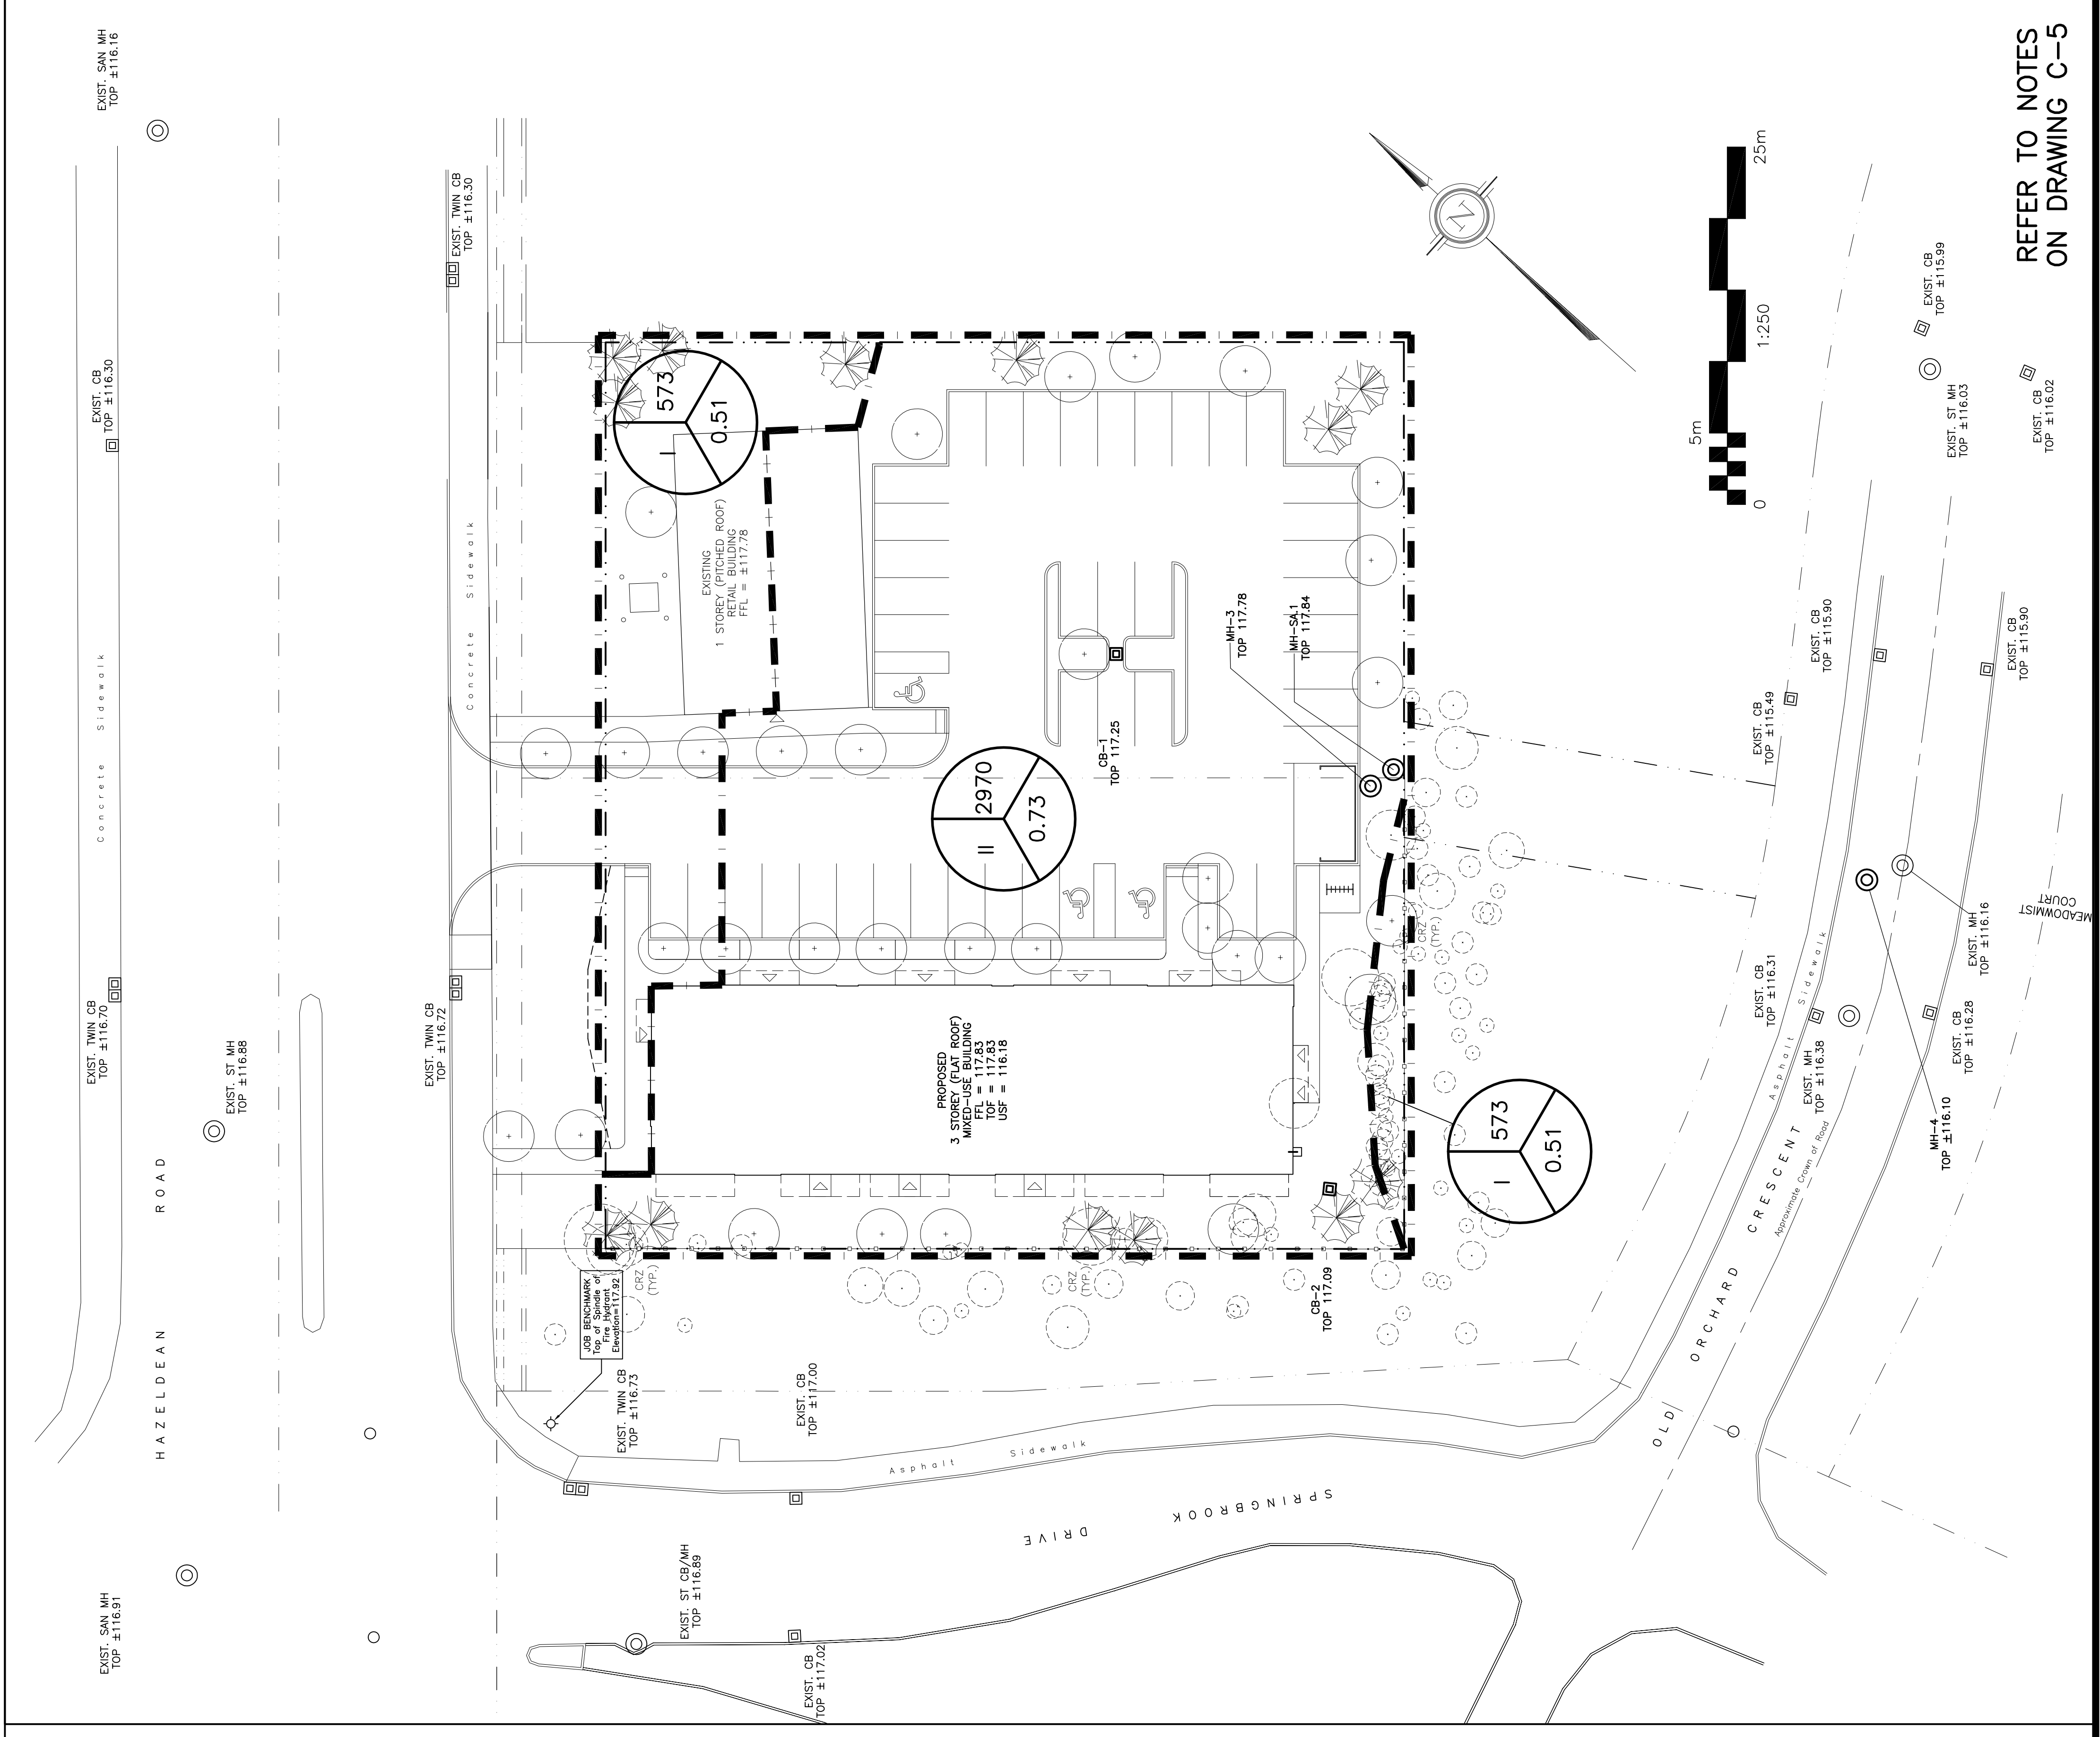

REFER TO NOTES ON DRAWING C-5