



LEGEND

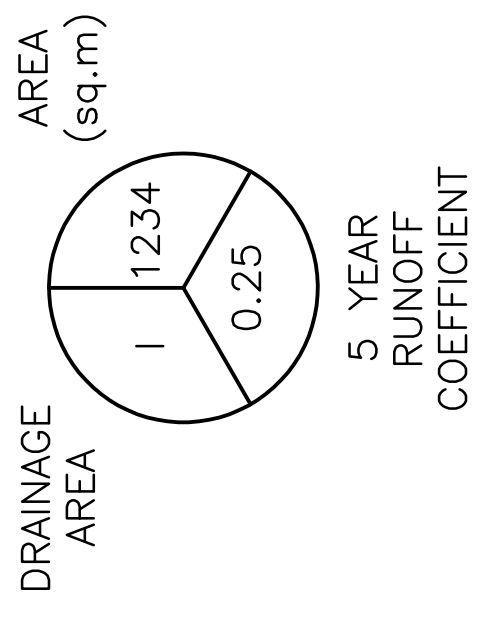

KEY PLAN

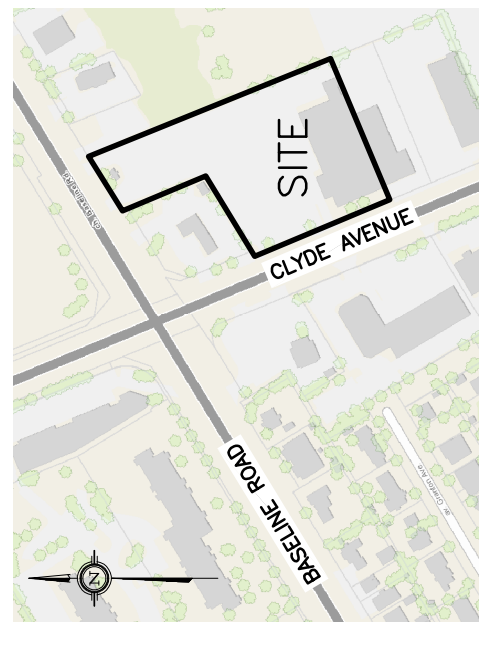

No.	DATE	REVISION
2	JAN 8-20	ISSUED FOR APPROVAL
1	DEC 12-19	ISSUED FOR COORDINATION


D. B. GRAY ENGINEERING INC.
 Structural Management - Consulting & Drainage - Storm & Sanitary Sewers - Firewater
 700 Long Point Circle
 Ottawa, Ontario
 613-425-8044
 dgray@dbgrayengineering.com

**PROPOSED 6 STOREY
 STORAGE FACILITY &
 1 STOREY RESTAURANT
 1375 CLYDE AVENUE
 OTTAWA, ONTARIO**

DRAINAGE PLAN

Engineer's Seal

 Drawing No. **C-8**
 of **8**

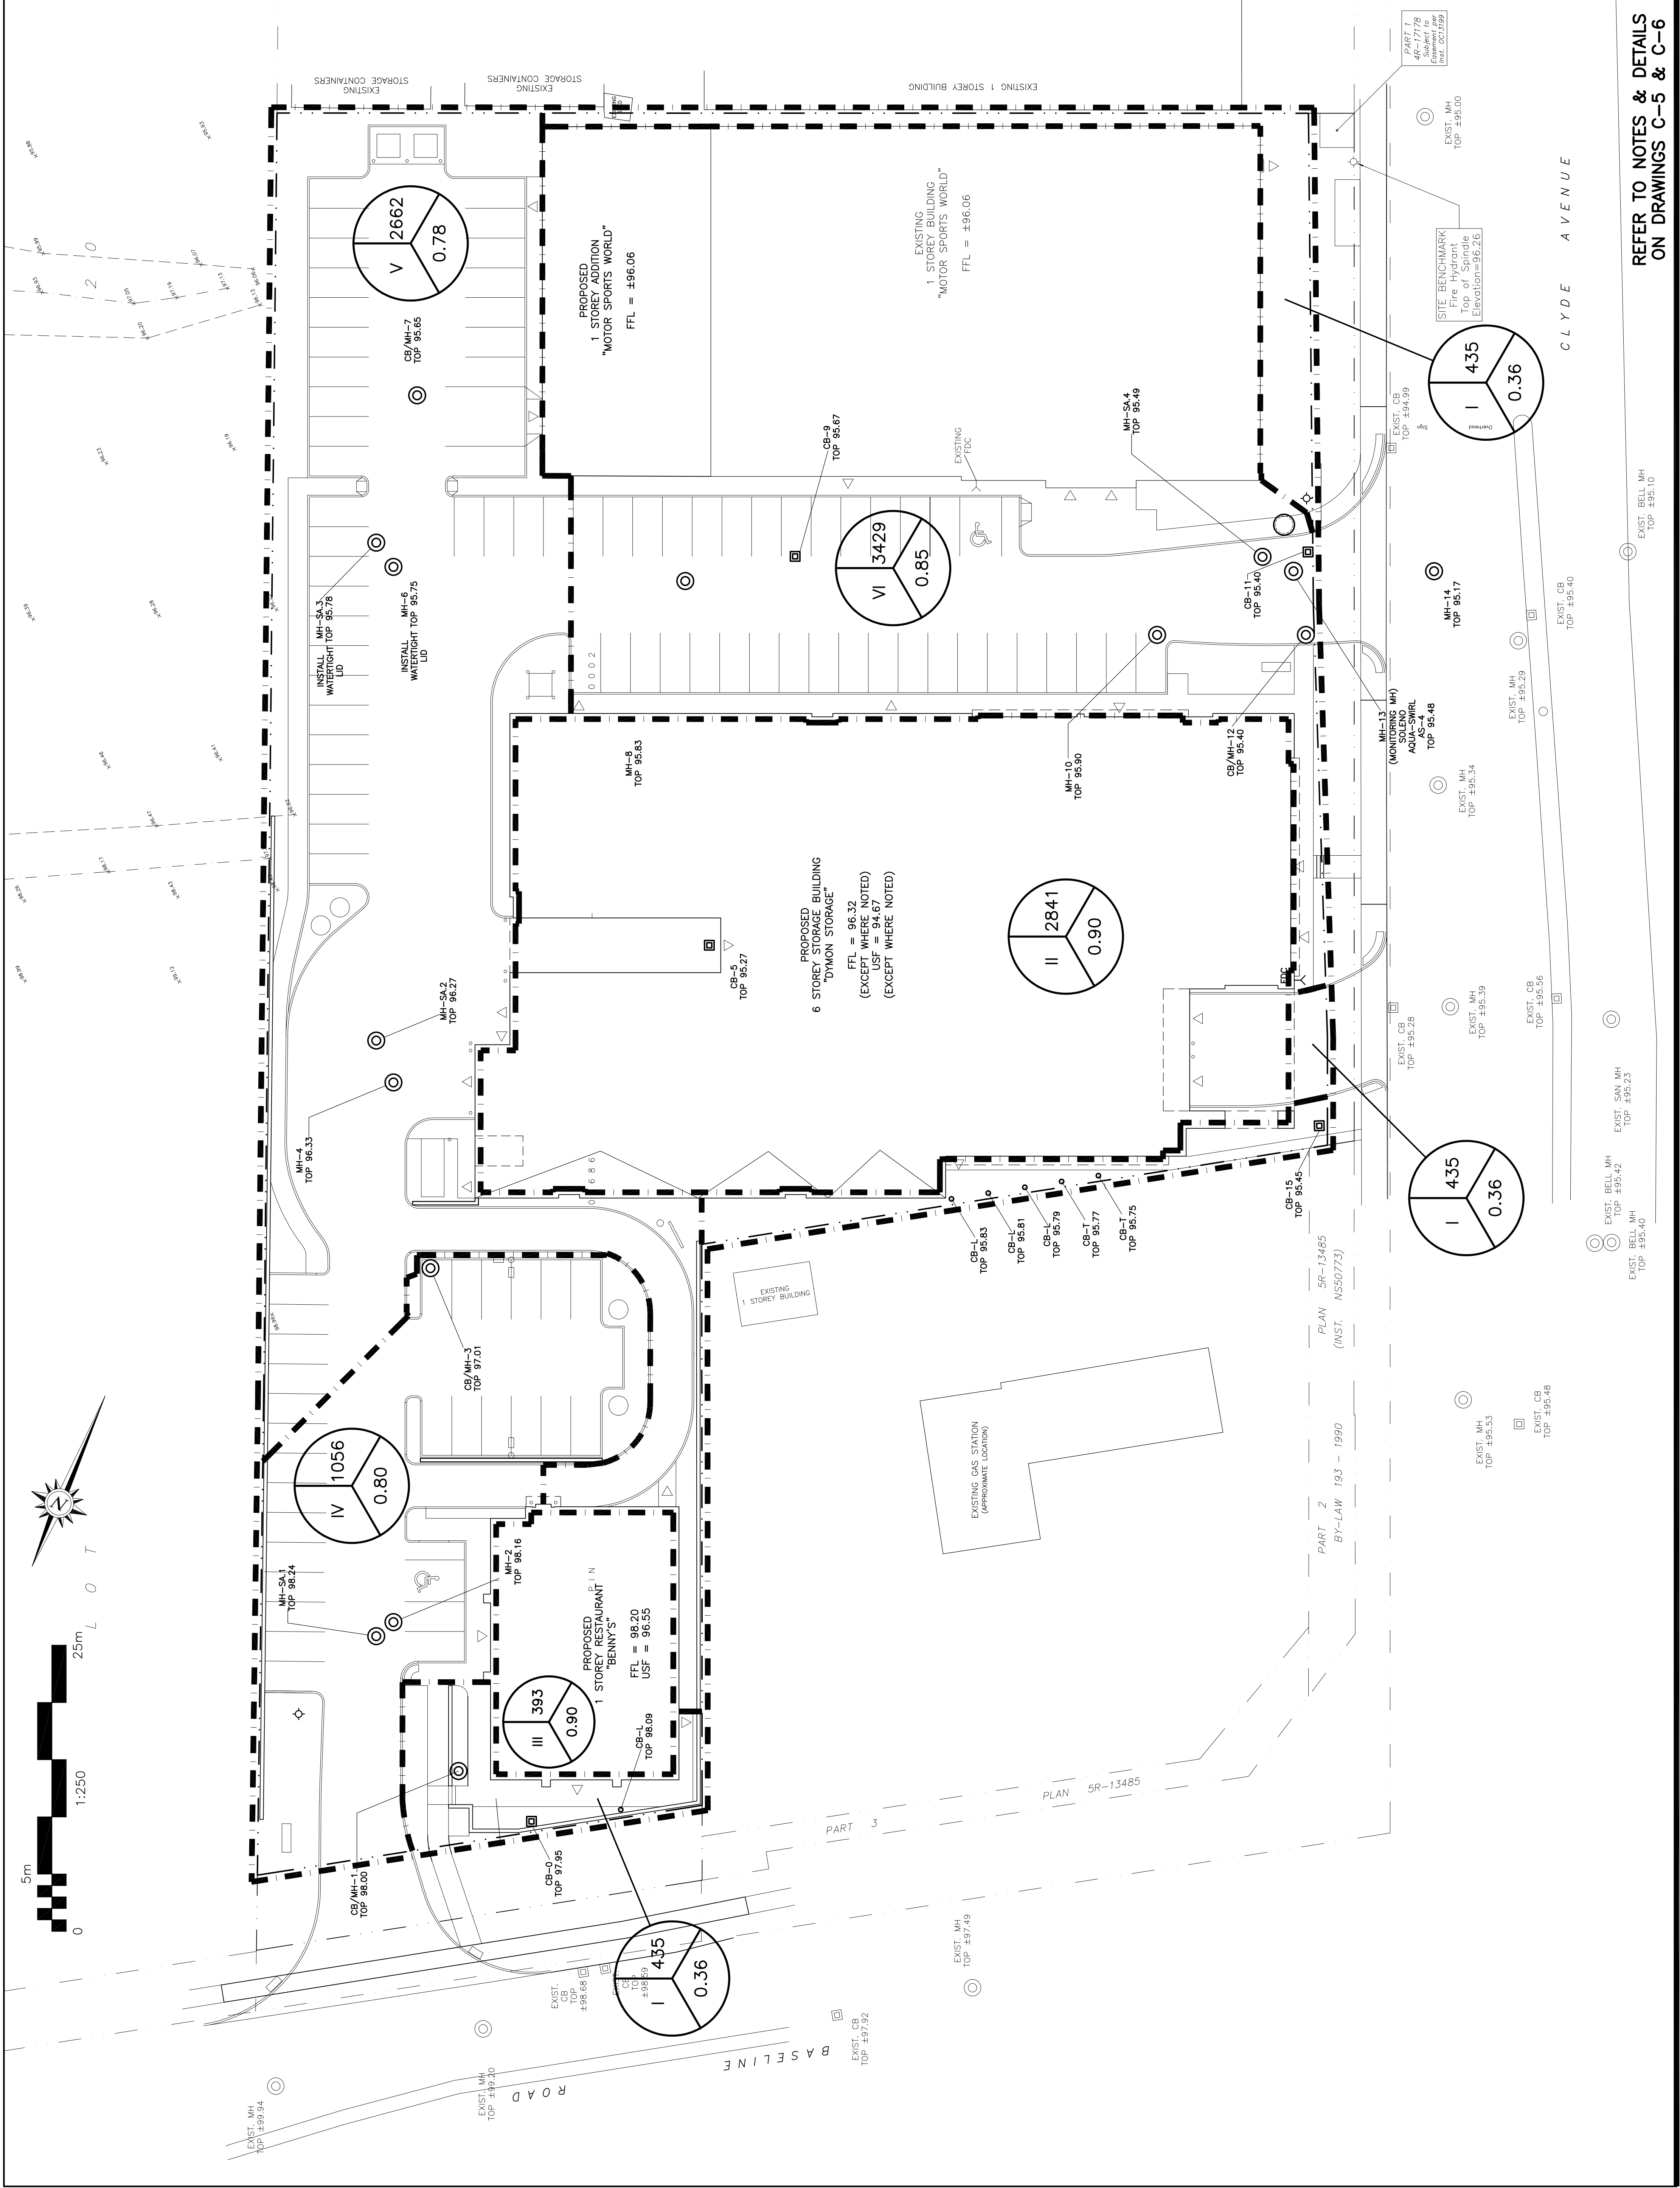

REFER TO NOTES & DETAILS
 ON DRAWINGS C-5 & C-6