


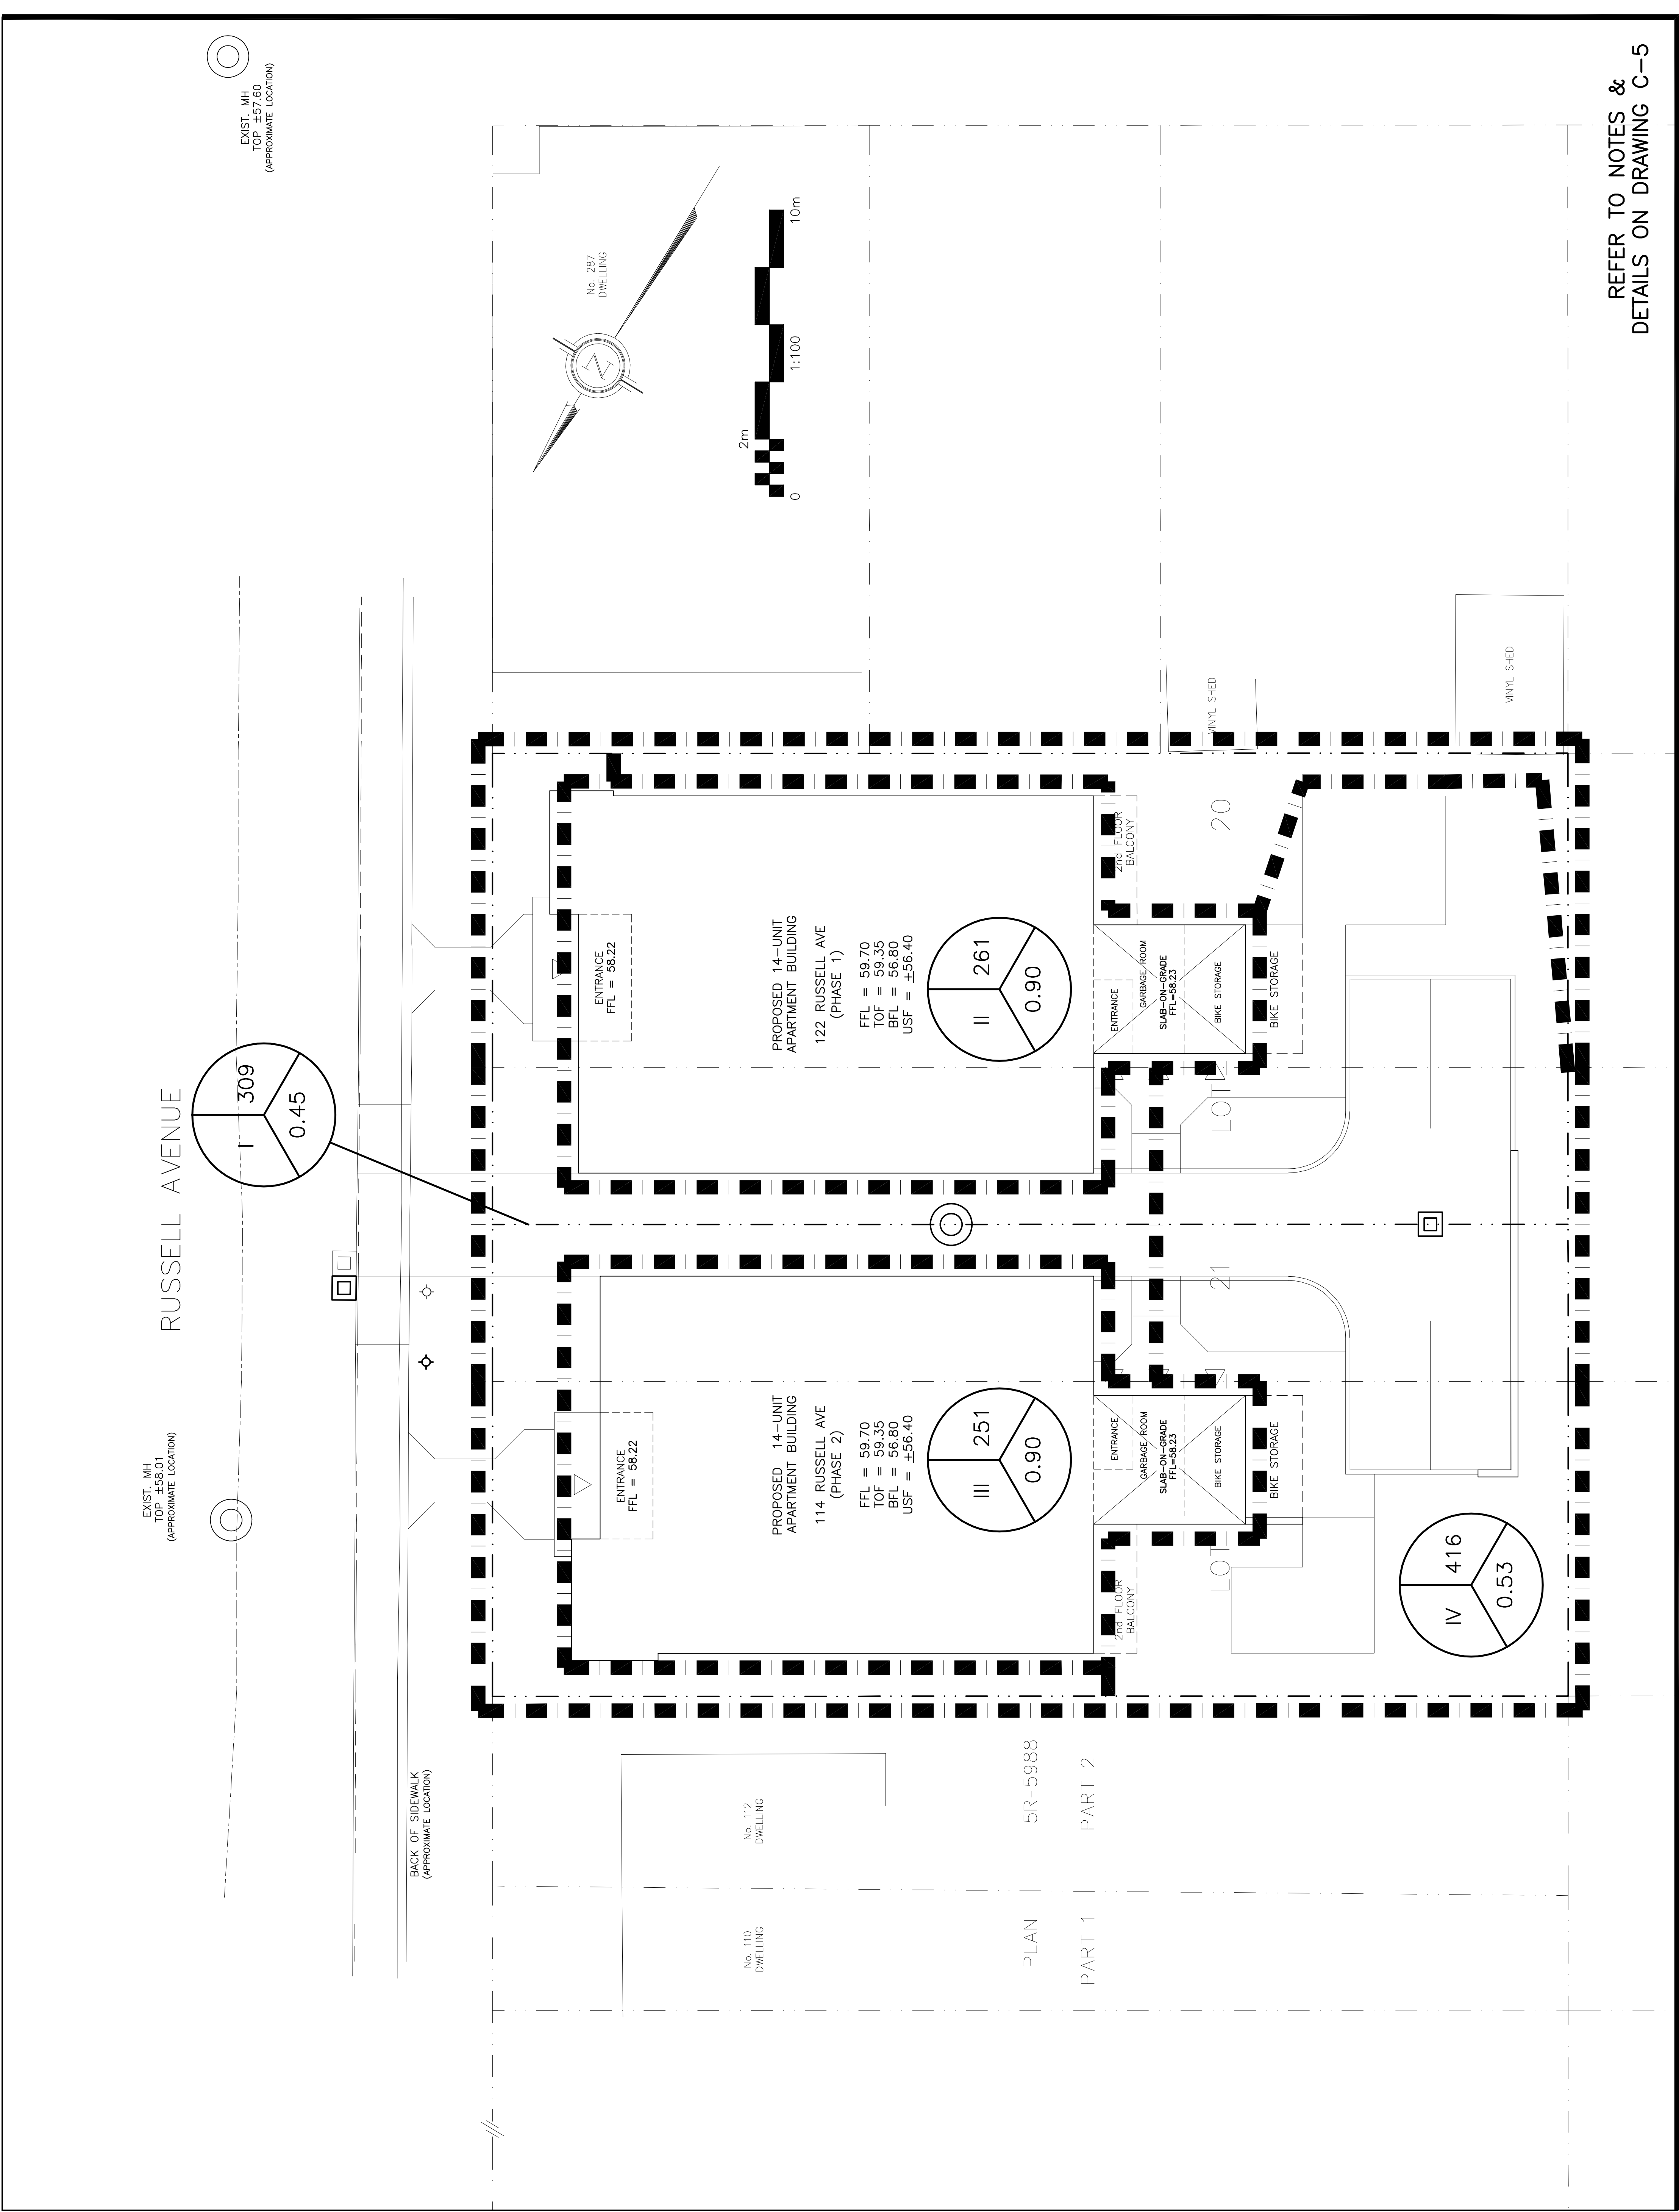

REFER TO NOTES &
DETAILS ON DRAWING C-5

Engineer's Seal

Drawn

D.B.G.

Hor. Scale

1:100

Vert. Scale

1:100

Date

OCT 17-19

Job No.

19078

Drawing No.

C-5

of 6

DRAINAGE PLAN

PROPOSED
APARTMENT BUILDINGS
114-122 RUSSELL AVENUE
OTTAWA, ONTARIO

D. B. GRAY ENGINEERING INC.
Sustainable Management • Grading & Drainage • Storm & Sanitary Sewers • Pavements
700 Long Point Circle
Ottawa, Ontario
613-425-8044
d.gray@dbgrayengineering.com

No.	DATE	REVISION
3	JAN 27-20	RE-ISSUED FOR APPROVAL
2	OCT 30-19	ISSUED FOR APPROVAL
1	OCT 17-19	ISSUED FOR COORDINATION

LEGEND

Drainage Area

Area (sq.m)

5 Year Runoff Coefficient

KEY PLAN