



LEGEND

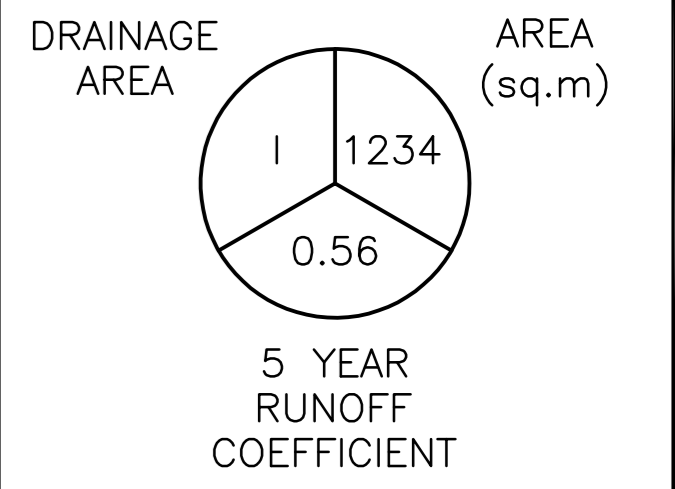

KEY PLAN

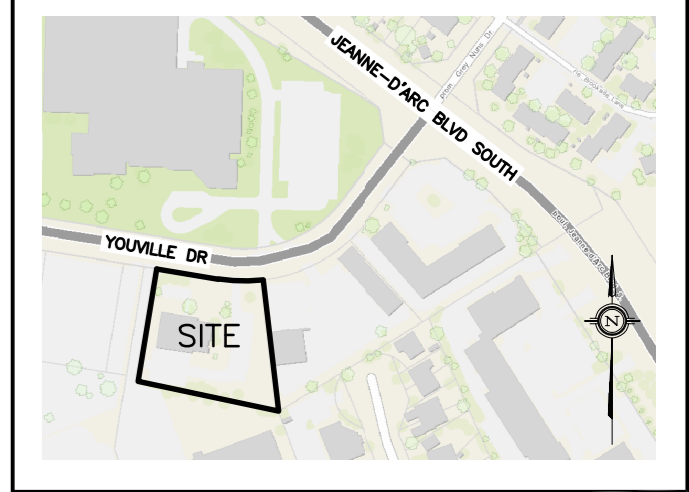


No.	DATE	REVISION
2	JUL 23-20	ISSUED FOR APPROVAL
1	JUN 9-20	ISSUED FOR CLIENT REVIEW

D. B. GRAY ENGINEERING INC.
 Stormwater Management - Grading & Drainage - Storm & Sanitary Sewers - Watermain
 700 Long Point Circle 613-425-8044
 Ottawa, Ontario d.gray@dbgrayengineering.com

Project
**PROPOSED
 PARKING LOT PAVING
 1479 YOUVILLE DRIVE
 OTTAWA, ONTARIO**

Drawing Title
DRAINAGE PLAN

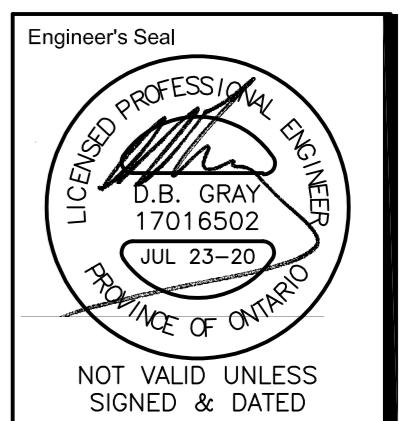

Drawn D.B.G.
 Hor. Scale 1:200
 Vert. Scale
 Date JUN 9-20
 Job No. 18090

Drawing No.
**C-7
 of 7**