

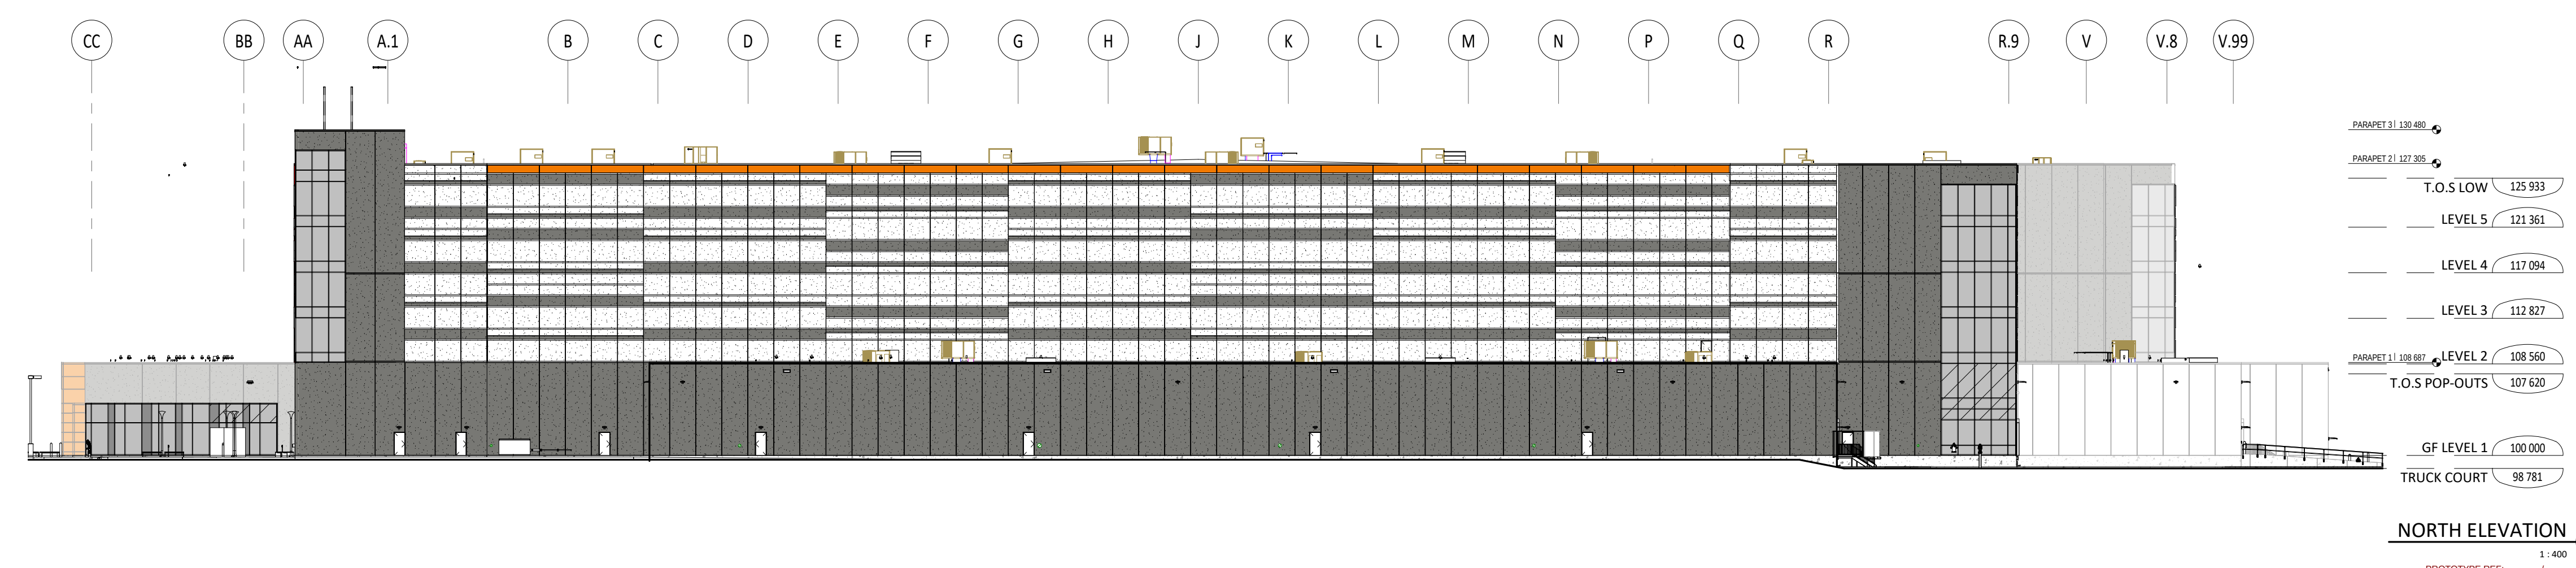
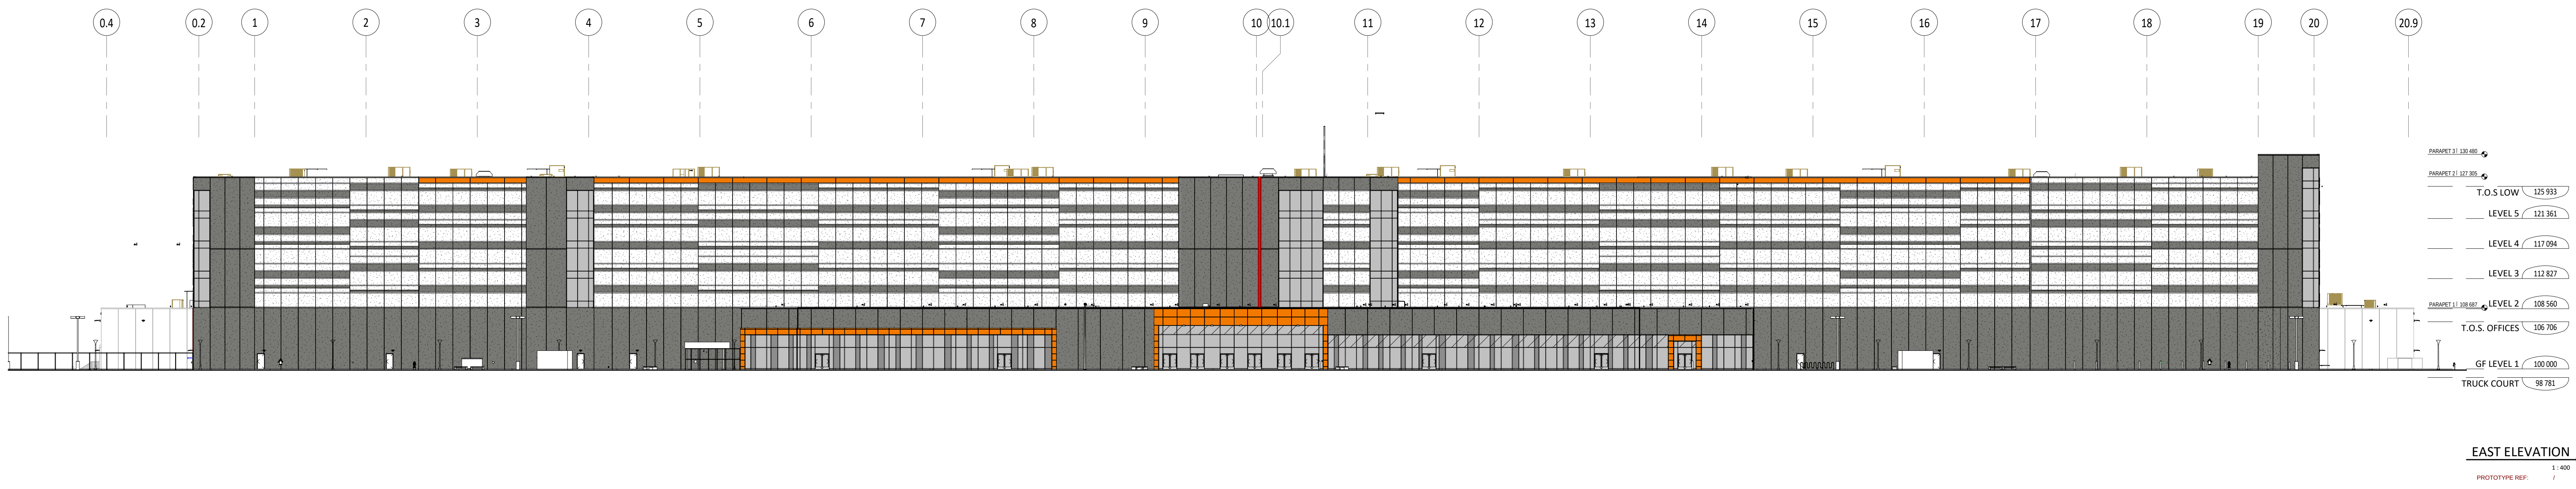


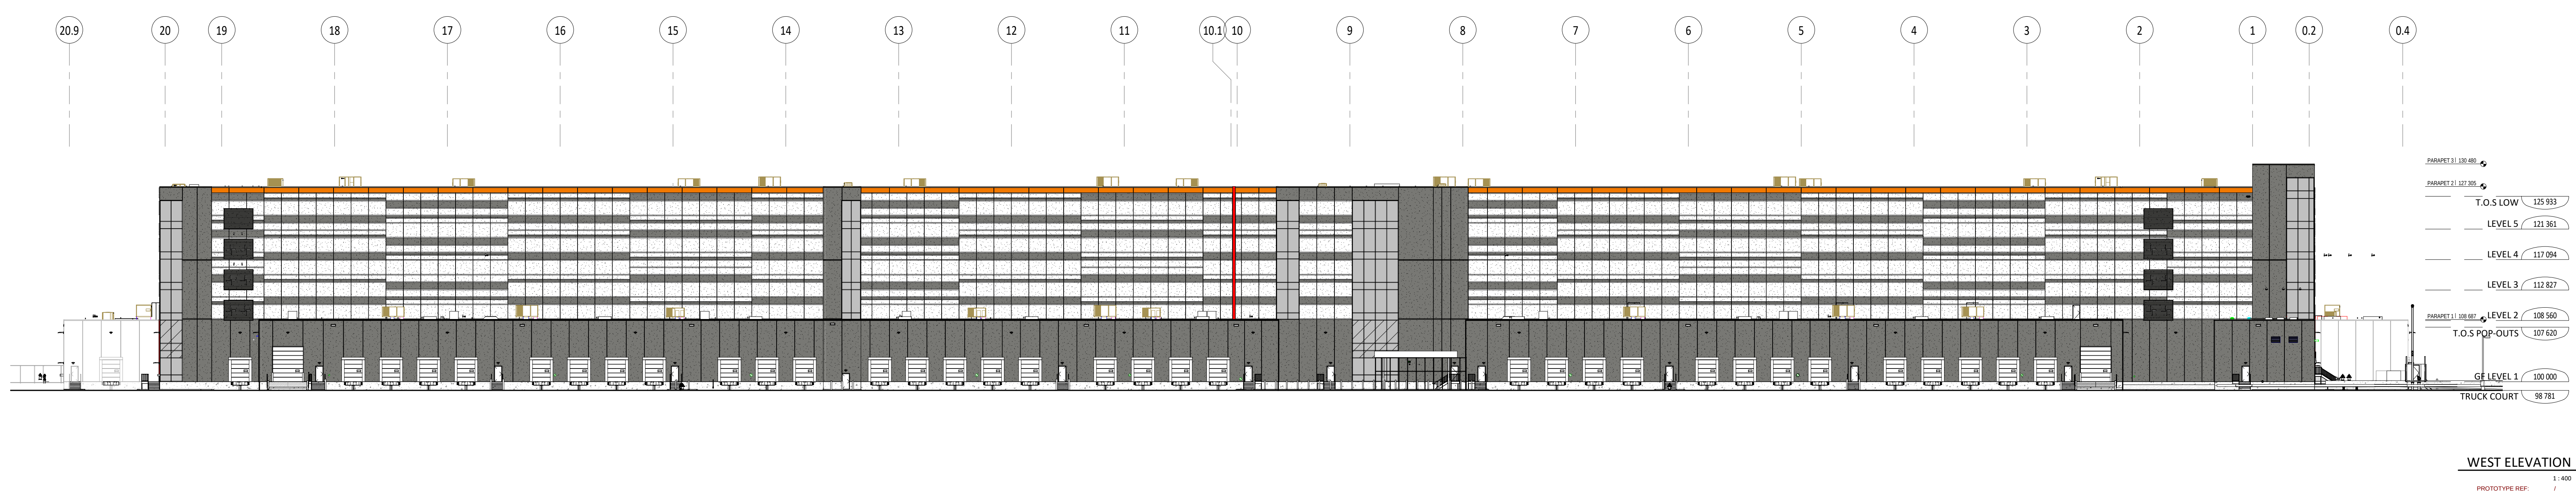

FINISHES LEGEND - EXTERIOR ELEVATIONS			
A- INSULATED SANDWICH CONCRETE PRECAST		E- ALUMINUM PANEL	
	CONCRETE COLOR : SW 7646 (FIRST STAR)		NOT APPLICABLE
	CONCRETE (sand in textured panel can be stained to match) COLOR : SW 7069 (IRON ORE)		ALUMINUM PANEL COLOR : FF6703 (Blaze Orange)
B- n/a		CURTAIN WALL LEGEND	
C- INSULATED METAL PANEL			SILICONE JOINT SEE SPECIFICATIONS
	EXTERIOR : KINGSFAN CHARCOAL / NORBEC FUSAN INTERIOR : IMPERIAL WHITE		ALUMINUM CAP SEE SPECIFICATIONS
D- PREFINISHED METAL FLASHING			GLAZING SEE DETAIL AND SPECIFICATIONS
	COLOR : COLOR TO MATCH WALL FINISH		CURTAINWALL TAG- REFER TO A410 FOR CURTAINWALL ELEVATION
NOTE: PROVIDE ALUMINUM FLASHING AT CURTAINWALL AND ALUMINUM PANEL FINISH.			T = TEMPERED GLASS
			TH = THERMAL UNIT
			THT = THERMAL UNIT WITH TEMPERED GLASS
			TY = TYMPAN THERMAL GLASS UNIT ON INSULATED GALVANIZED PAN
			S = SECURITY FILM- SEE SPEC
			SSI = STRUCTURAL SILICONE JOINT
			GLASS TYPE 1 CLEAR VISION SEE SPEC
			GLASS TYPE 2 TINTED GREY VISION SEE SPEC
			GLASS TYPE 3A CLEAR TYMPAN SEE SPEC
			GLASS TYPE 3A TINTED GRAY TYMPAN SEE SPEC

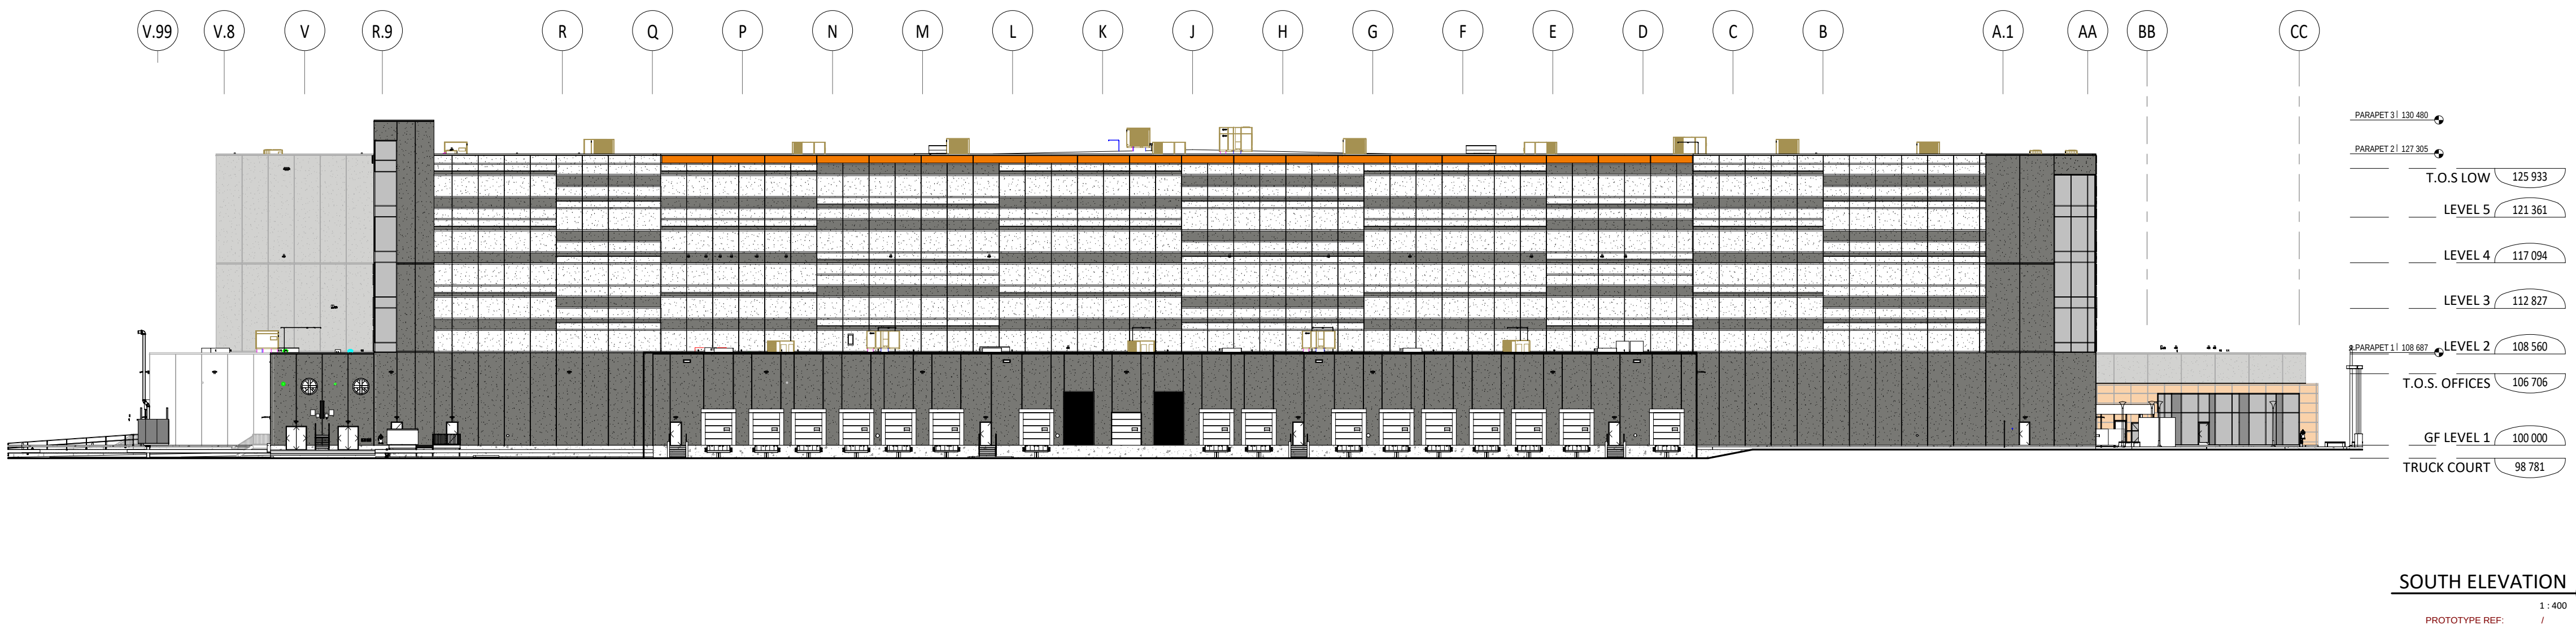

THIS PLAN IS APPROVED BY THE CITY OF OTTAWA
UNDER SECTION 41 OF THE PLANNING ACT THIS
9 DAY OF JULY, 2020.

LILY XU, MCIP, RPP, MANAGER
DEVELOPMENT REVIEW SOUTH
PLANNING, INFRASTRUCTURE AND ECONOMIC
DEVELOPMENT DEPARTMENT, CITY OF OTTAWA



PRELIMINARY
NOT TO BE USED
FOR CONSTRUCTION

No.	Date	Revision	By
2	2020.06.01	SPA REVISION	
1	2020.05.19	ISSUED FOR INTERNAL REVIEW	
6	2020.04.20	APRIL 20TH ISSUED FOR DESIGN REVIEW	
E	2020.03.24	PRECAST DIMENSIONS REVISION	
D	2020.03.18	ISSUED FOR OVERALL 33% DESIGN REVIEW	

2020-06-01 7:58:10 AM

PROJECT PYTHON



Copyright GKC Architects: Not to be used for any other project
without the architect's written consent. All dimensions and coordinates must be
verified on site. Do not scale drawings. Any discrepancies or omissions in the
drawing shall be reported to the architect immediately in writing. All work is
subject to most recent applicable norms, bylaws and codes for all given trades.

ARCHITECTURE

ELEVATIONS

DRAWN BY: MB CHECKED BY: NC

SCALE: As indicated

FOLO: 20010 A400 R2