


Hydro First Defense® - HC

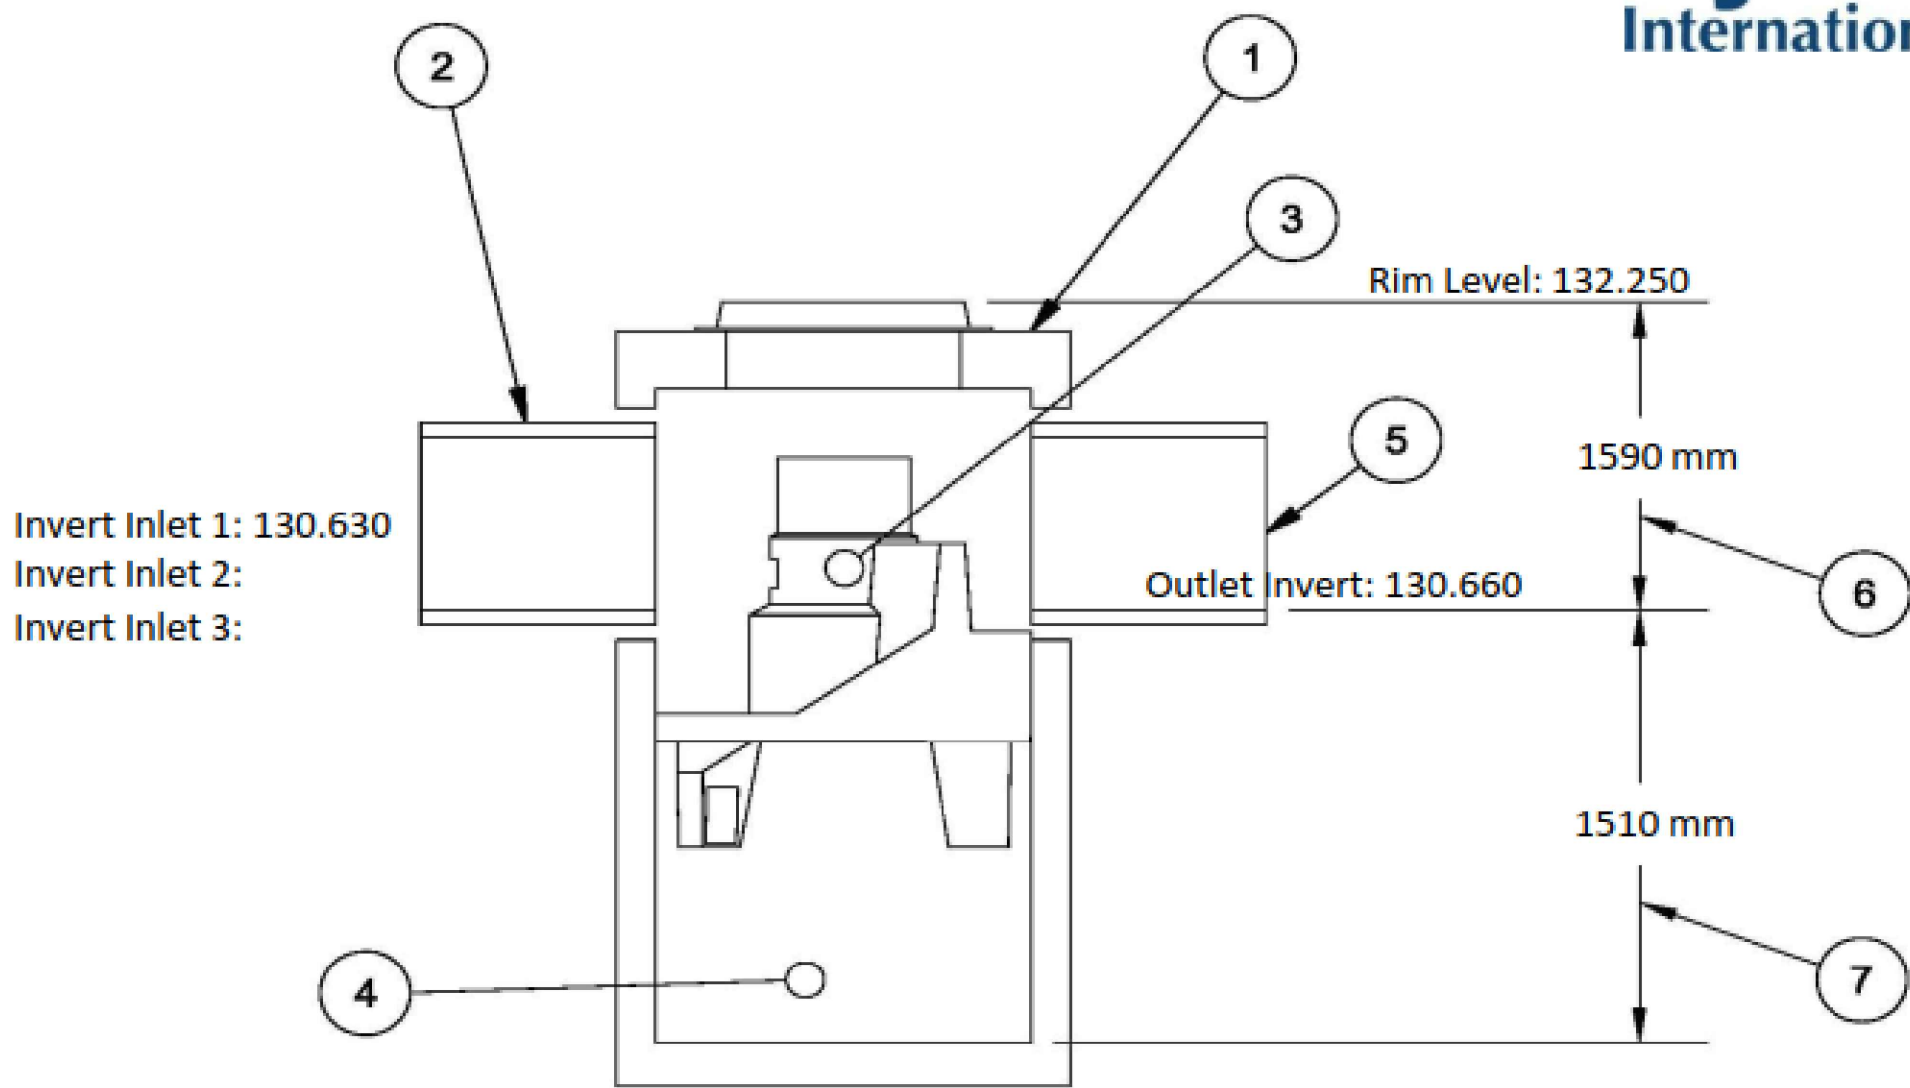


All drawing elevations are metres.


FD-4HC Specification

1	Vortex Chamber Diameter	1200 mm
2	Inlet Pipe Diameter	600 mm
3	Oil Storage Capacity	723.00 L
4	Min. Provided Sediment Storage Capacity	0.54 m ³
5	Outlet Pipe Diameter	600 mm
6	Height(Final Grade to Outlet Invert)	1590 mm
7	Sump Depth(Outlet Invert to Sump)	1510 mm
Total Depth		3100 mm

Notes:

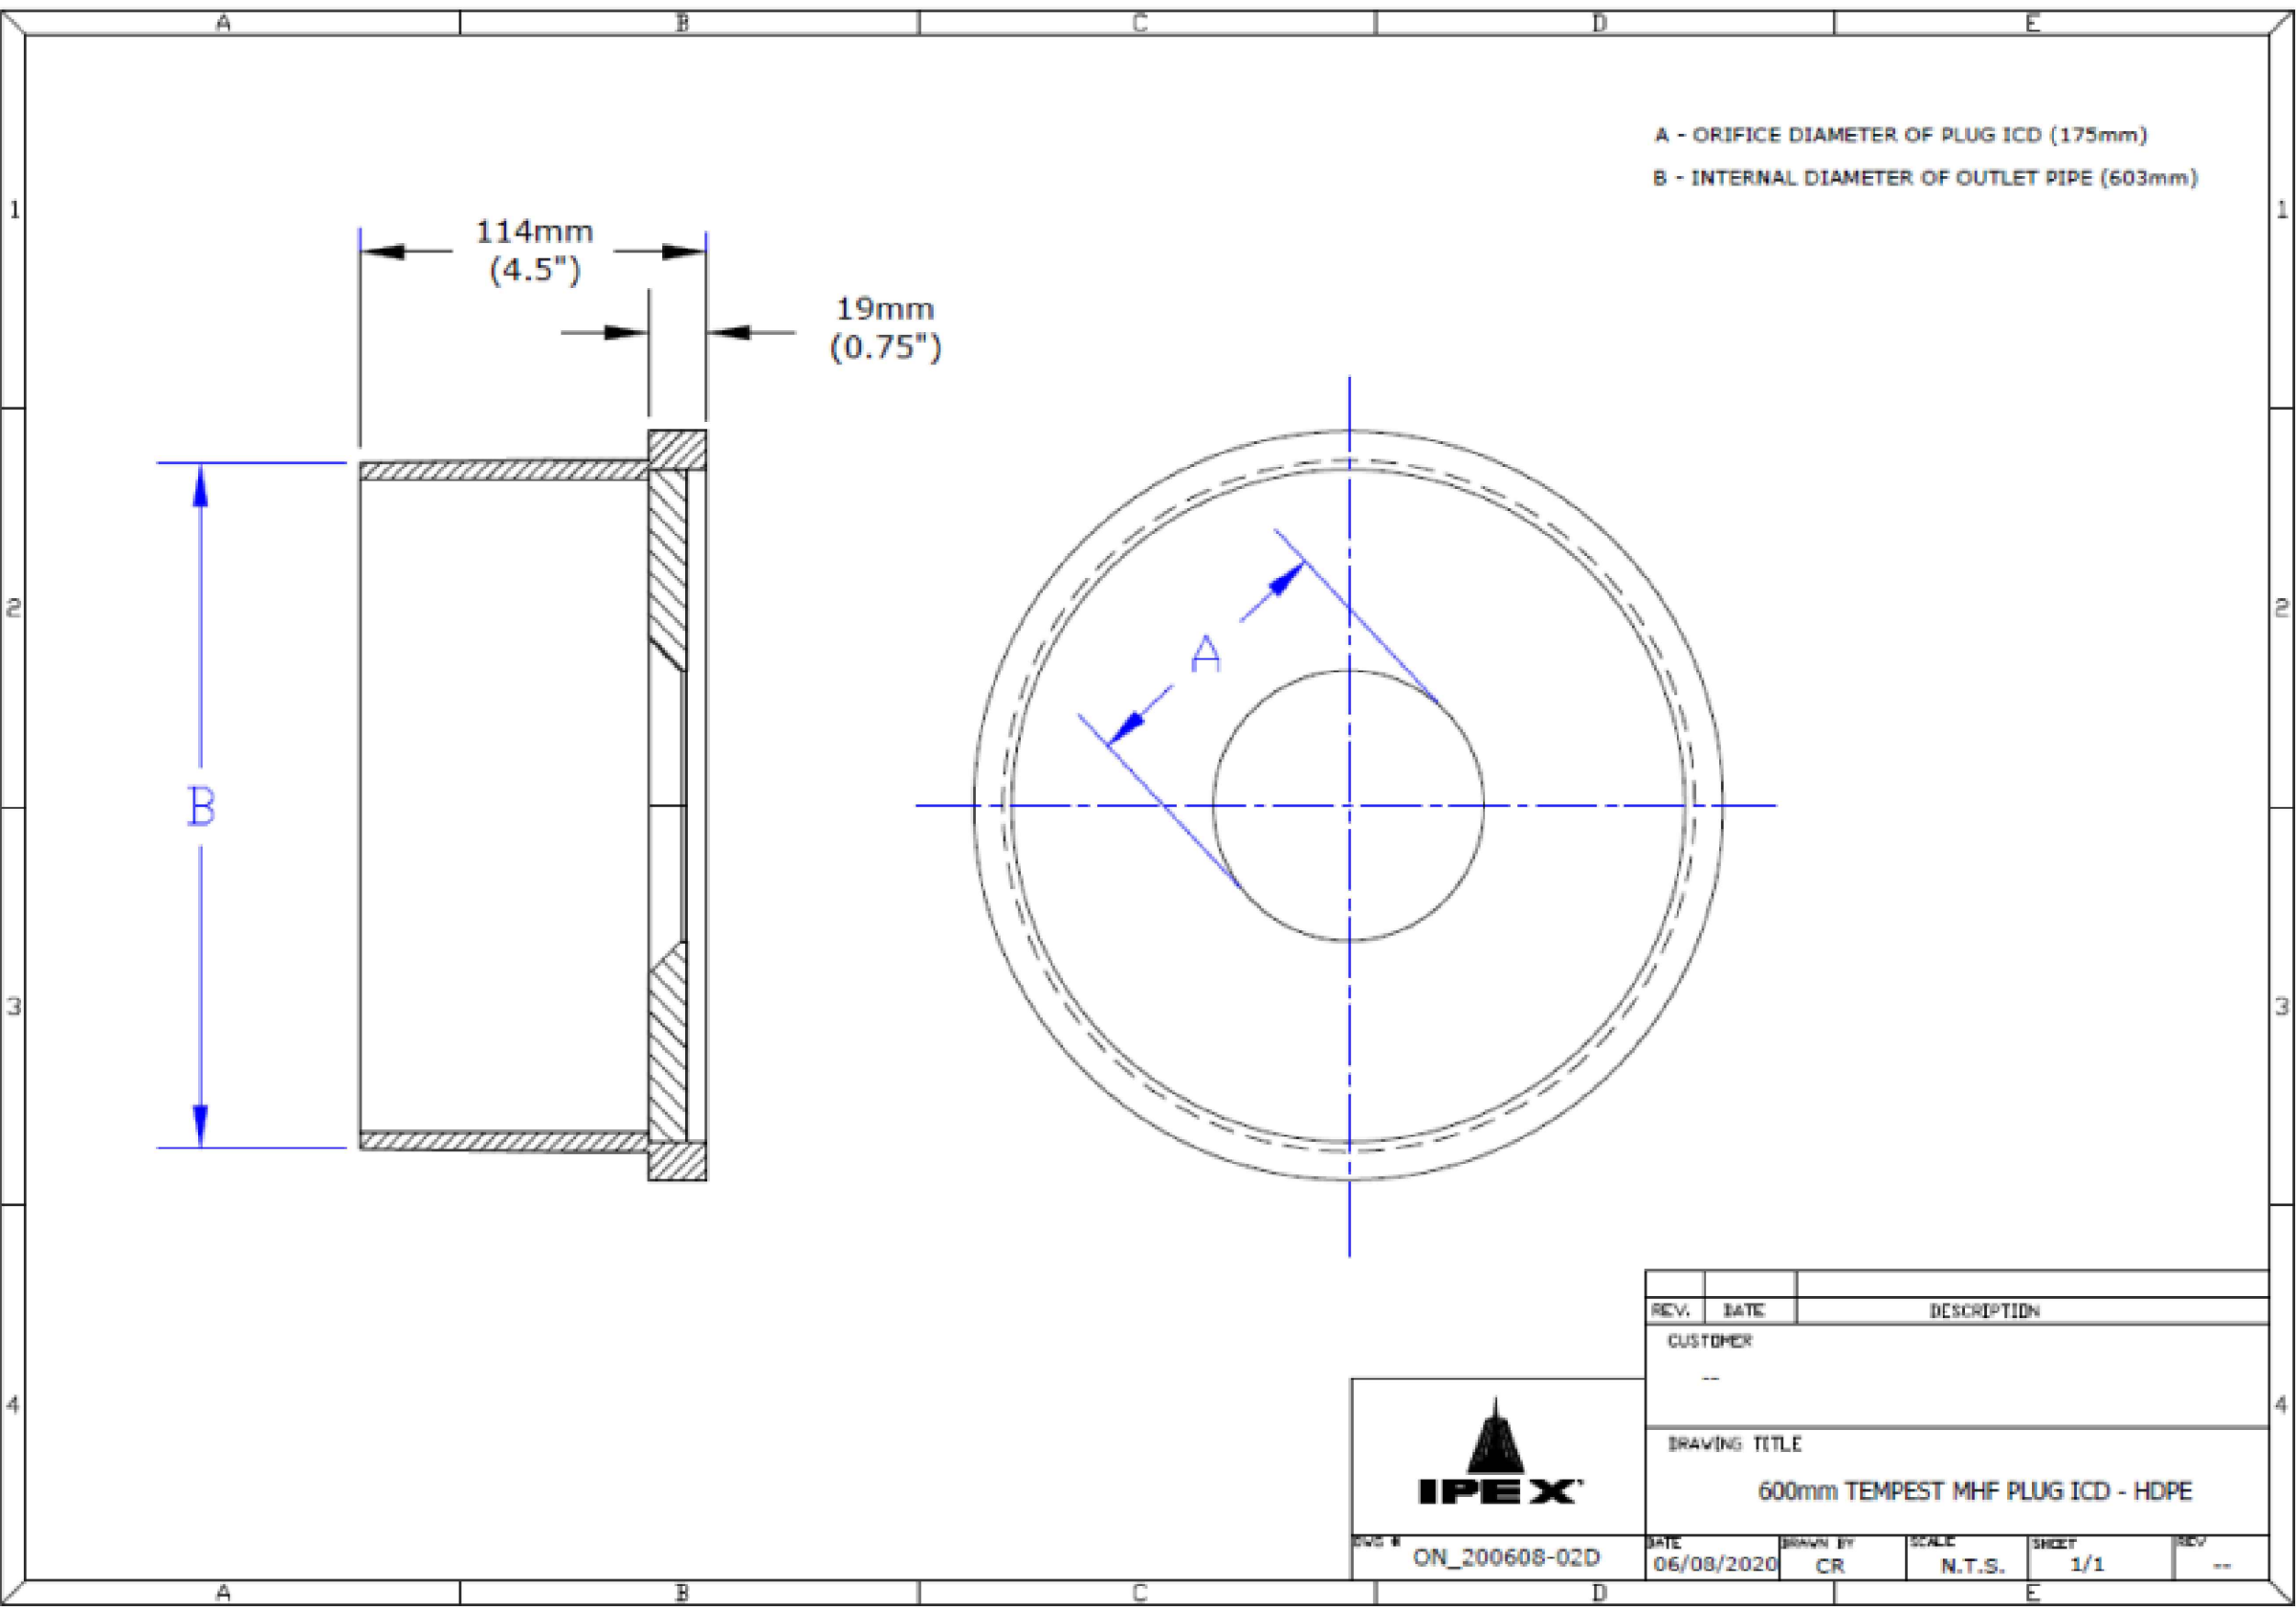

Hydro First Defense® - HC


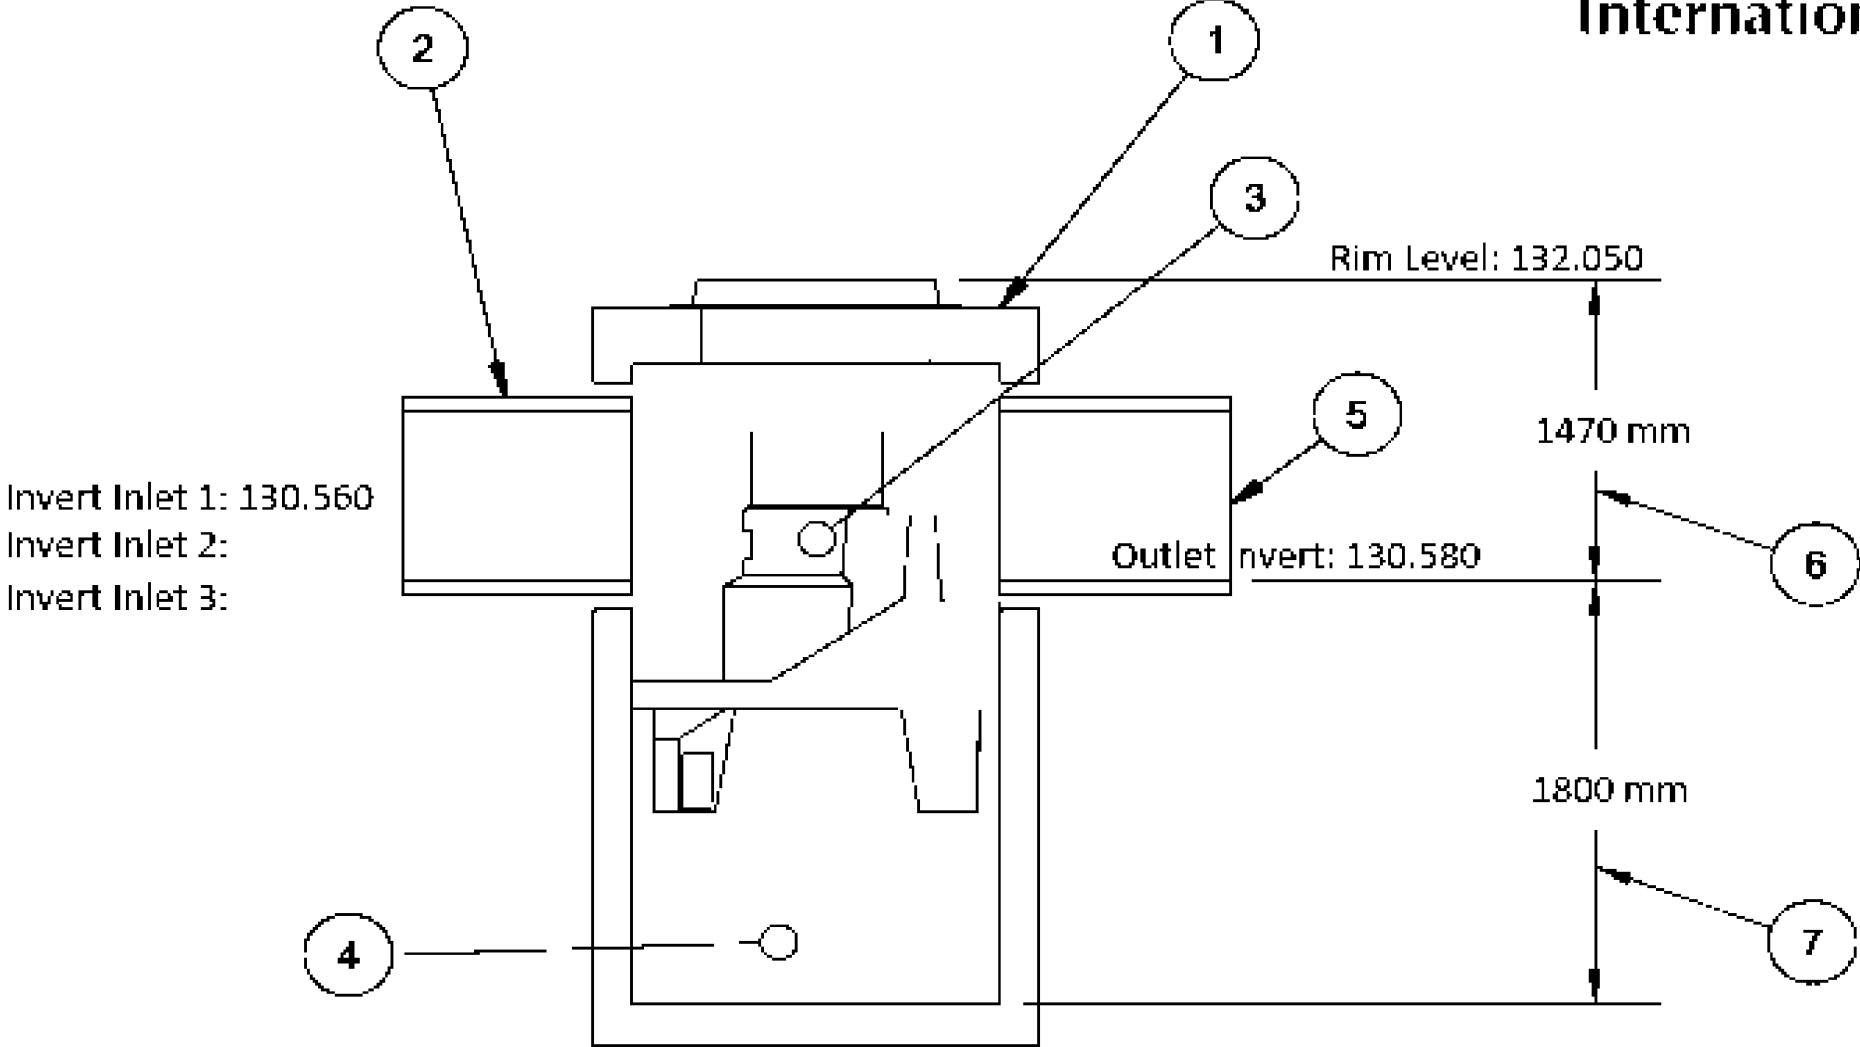


All drawing elevations are metres.

FD-5HC Specification

1	Vortex Chamber Diameter	1500 mm
2	Inlet Pipe Diameter	750 mm
3	Oil Storage Capacity	1136.00 L
4	Min. Provided Sediment Storage Capacity	0.84 m ³
5	Outlet Pipe Diameter	750 mm
6	Height(Final Grade to Outlet Invert)	1470 mm
7	Sump Depth(Outlet Invert to Sump)	1510 mm
Total Depth		2980 mm

Notes:

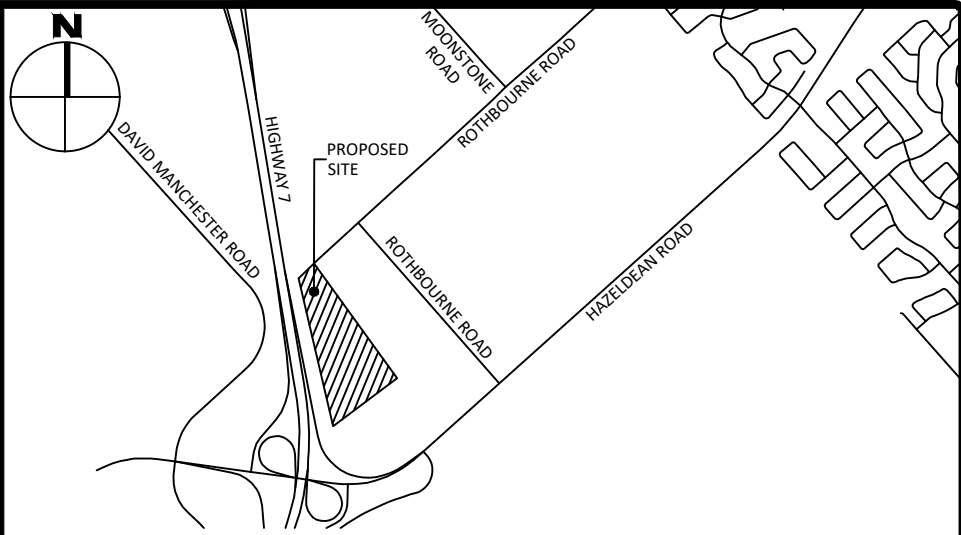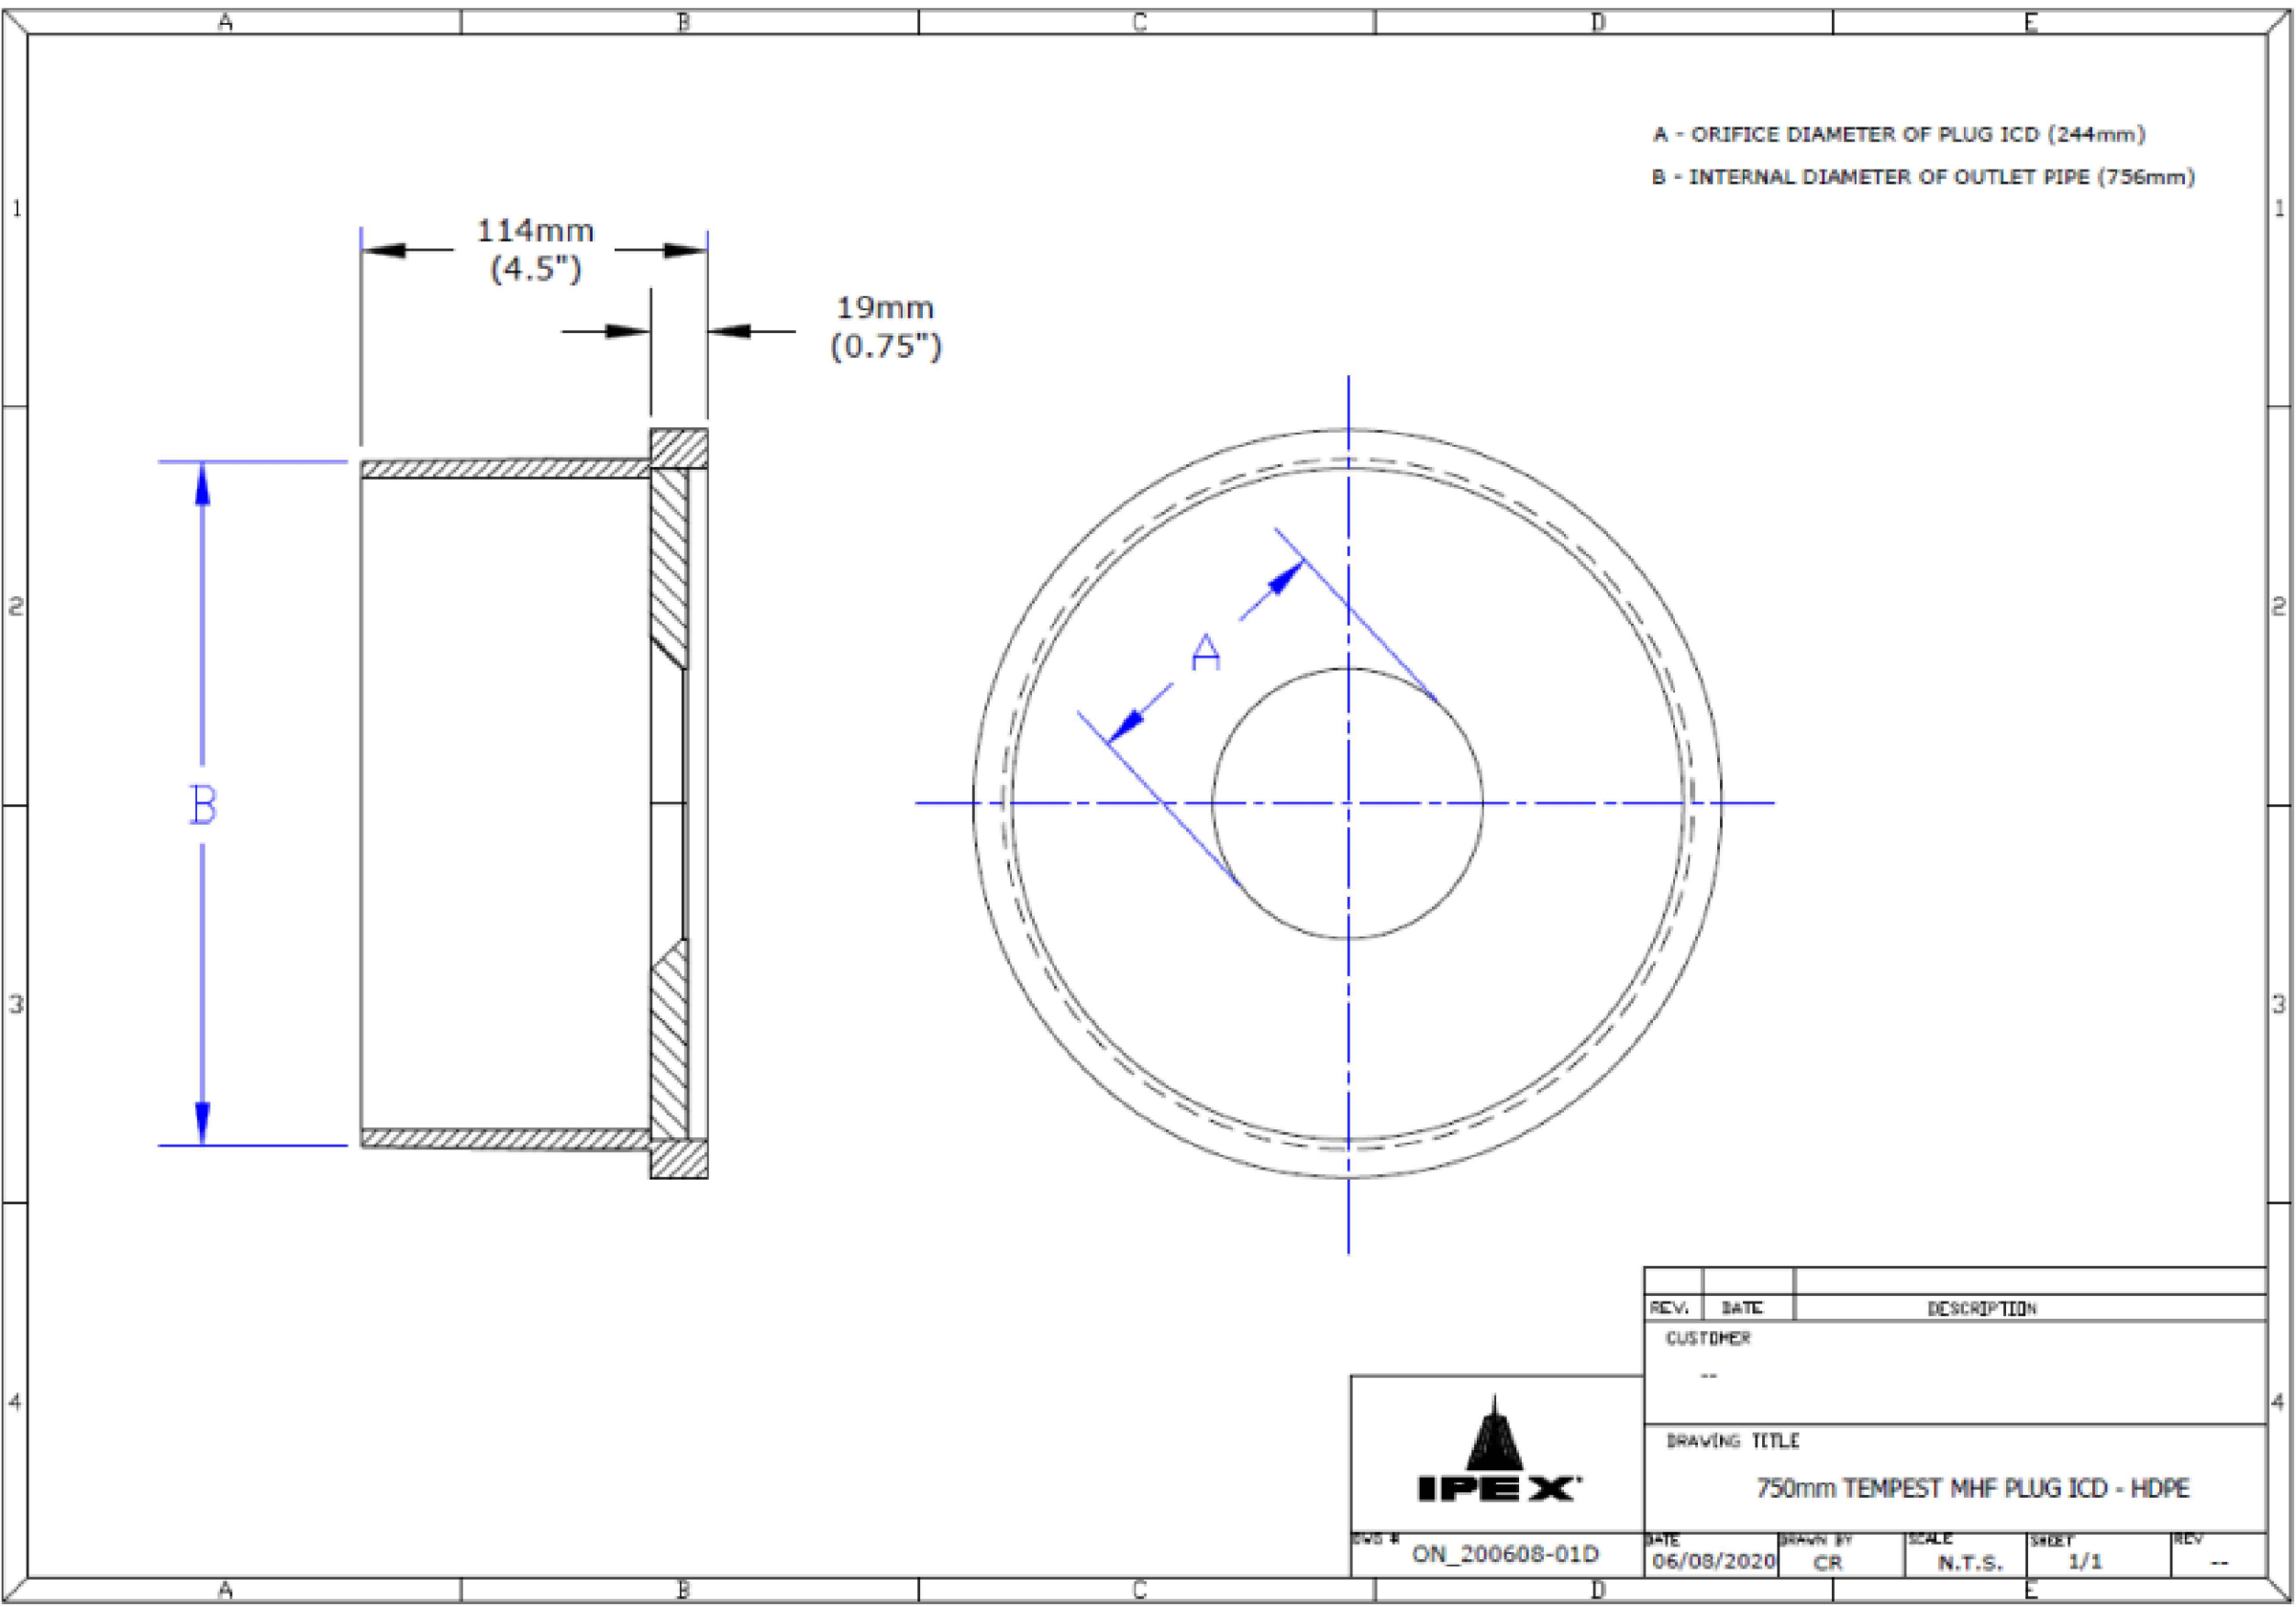

FOR REVIEW ONLY
NOT FOR CONSTRUCTION

No.	Revisions	Date
3	REVISED AS PER COMMENTS	AUG. 14, 2020
2	REVISED AS PER COMMENTS	DEC. 17, 2019
1	ISSUED FOR SITE PLAN CONTROL	JULY 17, 2019
Check and verify all dimensions before proceeding with the work. Do not scale drawings.		

McINTOSH PERRY
115 Walgreen Road, RR3, Carp, ON K0A 1L0
Tel: 613-836-2184 Fax: 613-836-3742
www.mcintoshperry.com

Client: METRO TOWING
2759 LANCASTER ROAD
OTTAWA, ON K1B 4V8

Project: METRO TOW TRUCK
WAREHOUSE BUILDING
6776 ROTHBOURNE RD.
OTTAWA, ON

Drawing Title: DETAILS

Scale: Project Number: CP-17-0381

Drawn By: C.D.H.

Checked By: R.P.K.

Designed By: C.D.H.

Drawing Number: DETAILS3

FILENAME: C:\Users\j.mcclellan\OneDrive - McIntosh Perry\Documents\CP-17-0381-115 - Drawing\CP-17-0381-115 - Presentation.dwg
LAST SAVED: Monday, August 17, 2020 1:20:00 PM
LAST SAVED BY: C.D.H.
LAST PLOTTED: Monday, August 17, 2020 1:20:00 PM
C:\Users\j.mcclellan\OneDrive - McIntosh Perry\Documents\CP-17-0381-115 - Drawing\CP-17-0381-115 - Presentation.dwg

D07-12--XX-XXXX
#XXXXX