


DRAWING LEGEND

CB	CATCH BASIN
MH	MANHOLE
CB/MH	CATCH BASIN/MANHOLE
SPL	SPRINGLINE OF PIPE
INV	INVERT OF PIPE
SAW	SANITARY SEWER
ST	STORM SEWER
WS/WN	WATER SERVICE/WATERMAIN
VF	VALVE & VALVE BOX
FD	FIRE HYDRANT
FDC	FIRE DEPARTMENT CONNECTION
WM	WATER METER
WMR	REMOTE WATER METER HEADOUT
EGE	EXISTING GRADE ELEVATION
+86.75	PROPOSED GRADE ELEVATION
0.5%	EXISTING SLOPE OF GRADE
0.5%	PROPOSED SLOPE OF GRADE
→	EMERGENCY OVERLAND FLOW
-T.O.S.	TOP OF SLOPE
-B.O.S.	BOTTOM OF SLOPE
-	PROPERTY LINE
D.C.	150mm CURB/DEPRESSED CURB
GR	GRAVEL
LP	LIGHT-DUTY PAVEMENT
HP	HEAVY-DUTY PAVEMENT
CON	CONCRETE
LAN	LANDSCAPE
FL	FIRST FLOOR ELEVATION
USF	UNDERSIDE OF FOOTING

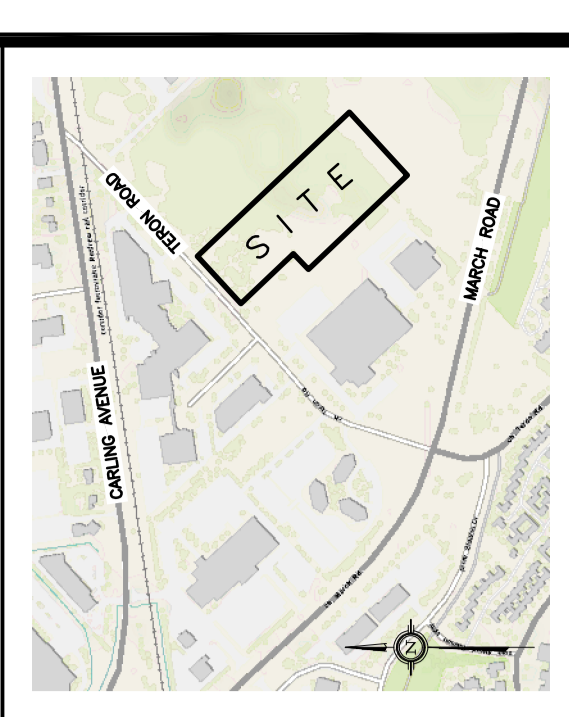

No.	DATE	REVISION
5	SEP 1-20	RE-ISSUED FOR APPROVAL
4	JUL 13-20	RE-ISSUED FOR APPROVAL
3	MAY 13-20	RE-ISSUED FOR APPROVAL
2	FEB 13-20	ISSUED FOR APPROVAL
1	FEB 11-20	ISSUED FOR COORDINATION

D. B. GRAY ENGINEERING INC.
 700 Long Point Circle
 Ottawa, Ontario K1M 1A2
 613-425-8044
 dgray@dbgrayengineering.com

PROJECT
**PROPOSED
 1 STOREY
 INDUSTRIAL WAREHOUSE
 1243 TERON ROAD
 OTTAWA, ONTARIO**

Drawing Title
**SITE SERVICING PLAN
 &
 GRADING PLAN**

Engineer's Seal

 NOT VALID UNLESS SIGNED & DATED

Drawn: D.B.G.
 Hor. Scale: 1:400
 Vert. Scale: As Shown
 Date: OCT 18-19
 Job No.: 19057
 Drawing No.: **C-1**
 of **6**

#18115

D07-12-20-0017