


Sharma & Partners Inc.

Mechanical and Electrical Engineers


85 Guelph Drive, Unit 108
Toronto, Ontario, M3A 2P8

(416) 291-8802
1-888-642-7165

SP PROJECT NUMBER: 2020-1031

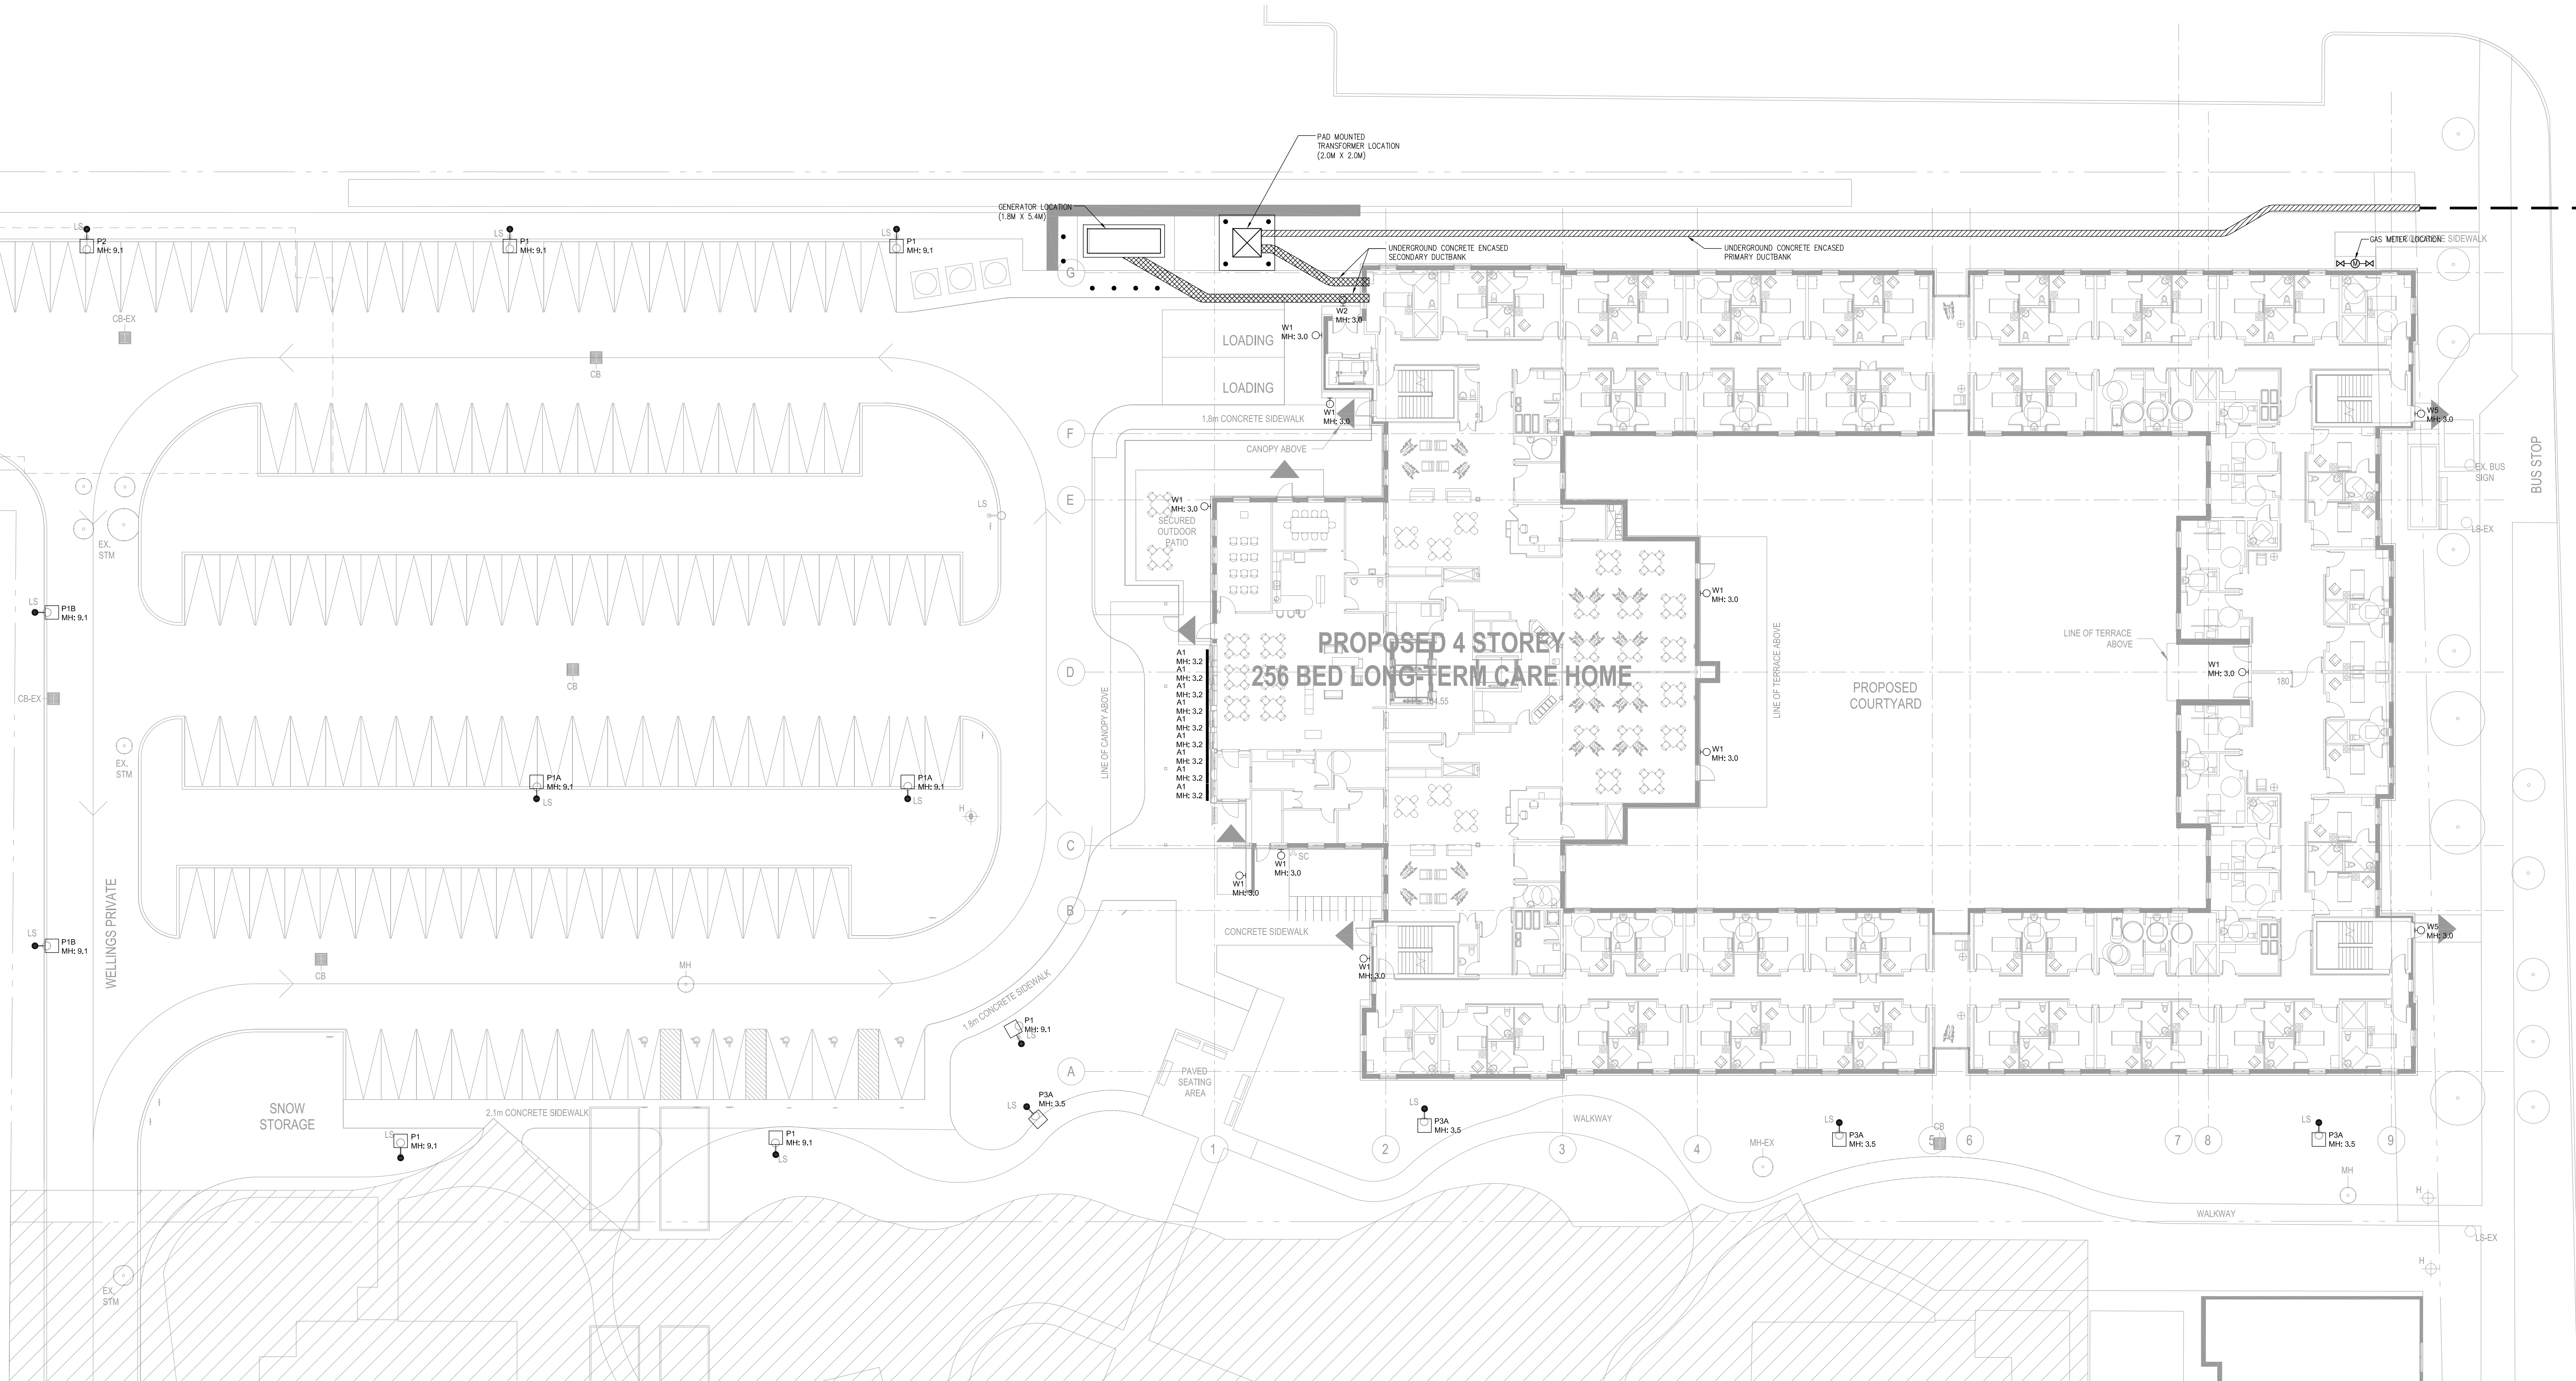

ISSUED FOR AMENDMENT TO SITE PLAN AGREEMENT		K.S.
#	DATE	REVISION
1	2020.08.20	

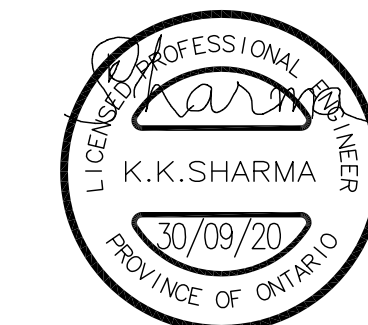

All drawing and specifications are the property of the architect. The contractor shall verify all dimensions and information on site and report any discrepancy to architect before proceeding.


EXTENDICARE STITTVILLE

2510 WELLINGS PRIVATE
STITTVILLE, ON

ELECTRICAL SITE PLAN

scale: 1/200
drawn by: L.Z.
reviewed by: K.S.
job number: 2020-1031
plot date: -
drawing number:

E002

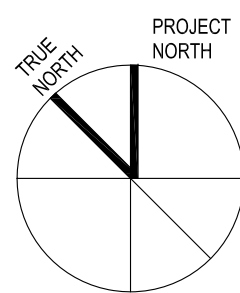

Sharma & Partners Inc.

Mechanical and Electrical Engineers

85 Guelph Drive, Unit 108
Toronto, Ontario, M3A 2P8

(416) 291-8802
1-888-842-7165


SP PROJECT NUMBER: 2020-1031

HAZELDEAN ROAD

Luminaire Schedule							
Symbol	Qty	Label	Arrangement	LLF	Description	Lum. Watts	Lum. Lumens
	1	P2	SINGLE	0.850	VP-S-36L-80-4K7-4W-BC	79.8	5722
	5	P1	SINGLE	0.850	VP-S-36L-80-4K7-4-BC	82.32	6999
	2	P1A	SINGLE	0.850	VP-S-36L-80-4K7-4	81	9052
	9	W1	SINGLE	0.850	LNC2-12L-4K-035-4	13.8	1543
	1	W2	SINGLE	0.850	LNC2-12L-4K-070-2	28.6	2763
	4	P3A	SINGLE	0.850	ALT1-28L-20-4K7-2-BC	22	1865
	2	P1B	SINGLE	0.850	VP-S-36L-80-4K7-4-BC	82.32	6999
	9	A1	SINGLE	0.850	M-A-840HO-4	35.6	4000
	2	W5	SINGLE	0.850	JE-30351-N-W40	15	1099

Calculation Summary							
Label	CalcType	Units	Avg	Max	Min	Avg/Min	Max/Min
MAIN ENTRANCE	Illuminance	Lux	57.44	106	18	3.19	5.89
PARKING LOT	Illuminance	Lux	10.71	30.1	2.5	4.28	12.04
PROPERTY LINE	Illuminance	Lux	0.52	2	0	N.A.	N.A.
PROPERTY LINE EAST	Illuminance	Lux	0.00	0	0	N.A.	N.A.
SOUTH PATHWAY	Illuminance	Lux	9.34	39.3	0.0	N.A.	N.A.

1	2020.08.20	ISSUED FOR AMENDMENT TO SITE PLAN AGREEMENT	K.S.
revisions	date	revision	by

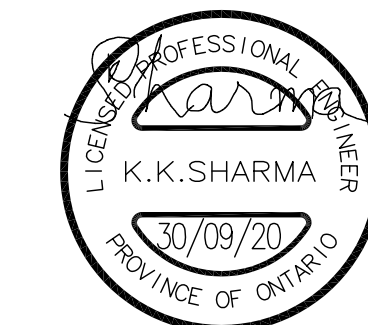

All drawing and specifications are the property of the architect. The consultant shall verify all dimensions and information on site and report any discrepancy to architect before proceeding.

EXTENDICARE STITTVILLE

2510 WELLINGS PRIVATE
STITTVILLE, ON

ELECTRICAL PHOTOMETRIC
PLAN

scale: N.T.S.
drawn by: L.Z.
reviewed by: K.S.
job number: 2020-1031
plot date: -
drawing number:

E002-A