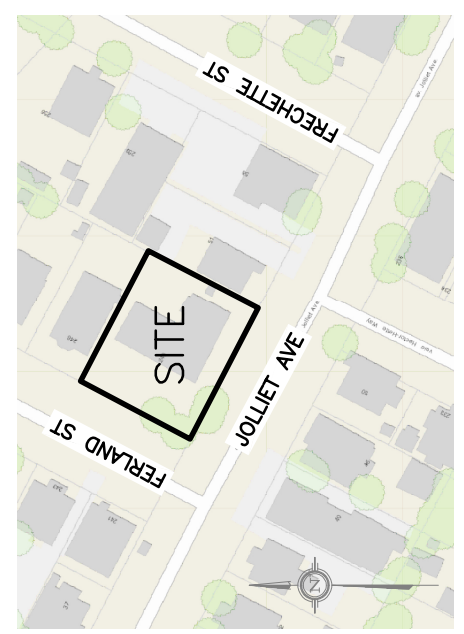


DRAWING LEGEND

CB	CH	CM	CA	CR	IR	IN	SN	ST	WS	CS	VB	RD	WM	RM	ES	PS	OS	SL	SB	PR	FC	LA	RR	CR	FL	TP	BF	UF			
CATCH BASIN	MANHOLE	CATCH BASIN/MANHOLE	SPRINGLINE OF PIPE	INVERT OF PIPE	SANITARY SEWER	STORM SEWER	WATER SEWER/WATERMAIN	CURB STOP & STANDPOST	WALK & VALVE BOX	FIRE HYDRANT	ROOF DRAIN	WATER METERS	WASTE WATER METER READOUT	EXISTING GRADE ELEVATION	PROPOSED GRADE ELEVATION	EXISTING SLOPE OF GRADE	PROPOSED SLOPE OF GRADE	EMERGENCY OVERLAND FLOW	CENTRELINE OF SIALE	PROPERTY LINE	SILT FENCE BARRIER	150mm CURB/DEPRESSED CURB	CONCRETE	INTERLOCK	LANDSCAPE	ROCK RUCK	CRITICAL ROOT ZONE	FIRST FLOOR FLOOR ELEVATION	TOP OF FOUNDATION	BASEMENT FLOOR ELEVATION	UNDERGROUND OF FOOTING

KEY PLAN


[illegible]

D. B. GRAY ENGINEERING INC.
Stormwater Management • Grading & Drainage • Storm & Sanitary Sewers • Watermain
700 Long Point Circle 613-425-8044
Ottawa, Ontario d.gray@dbgrayengineering.com

Project
PROPOSED 3 STOREY
STACKED TOWNHOMES
240 FERLAND STREET
OTTAWA, ONTARIO


GRADING PLAN

Drawing Title

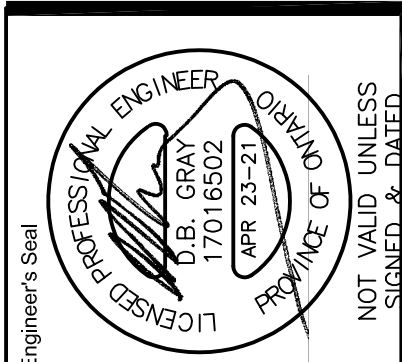

Drawing No.
C-3
of 7

#17691

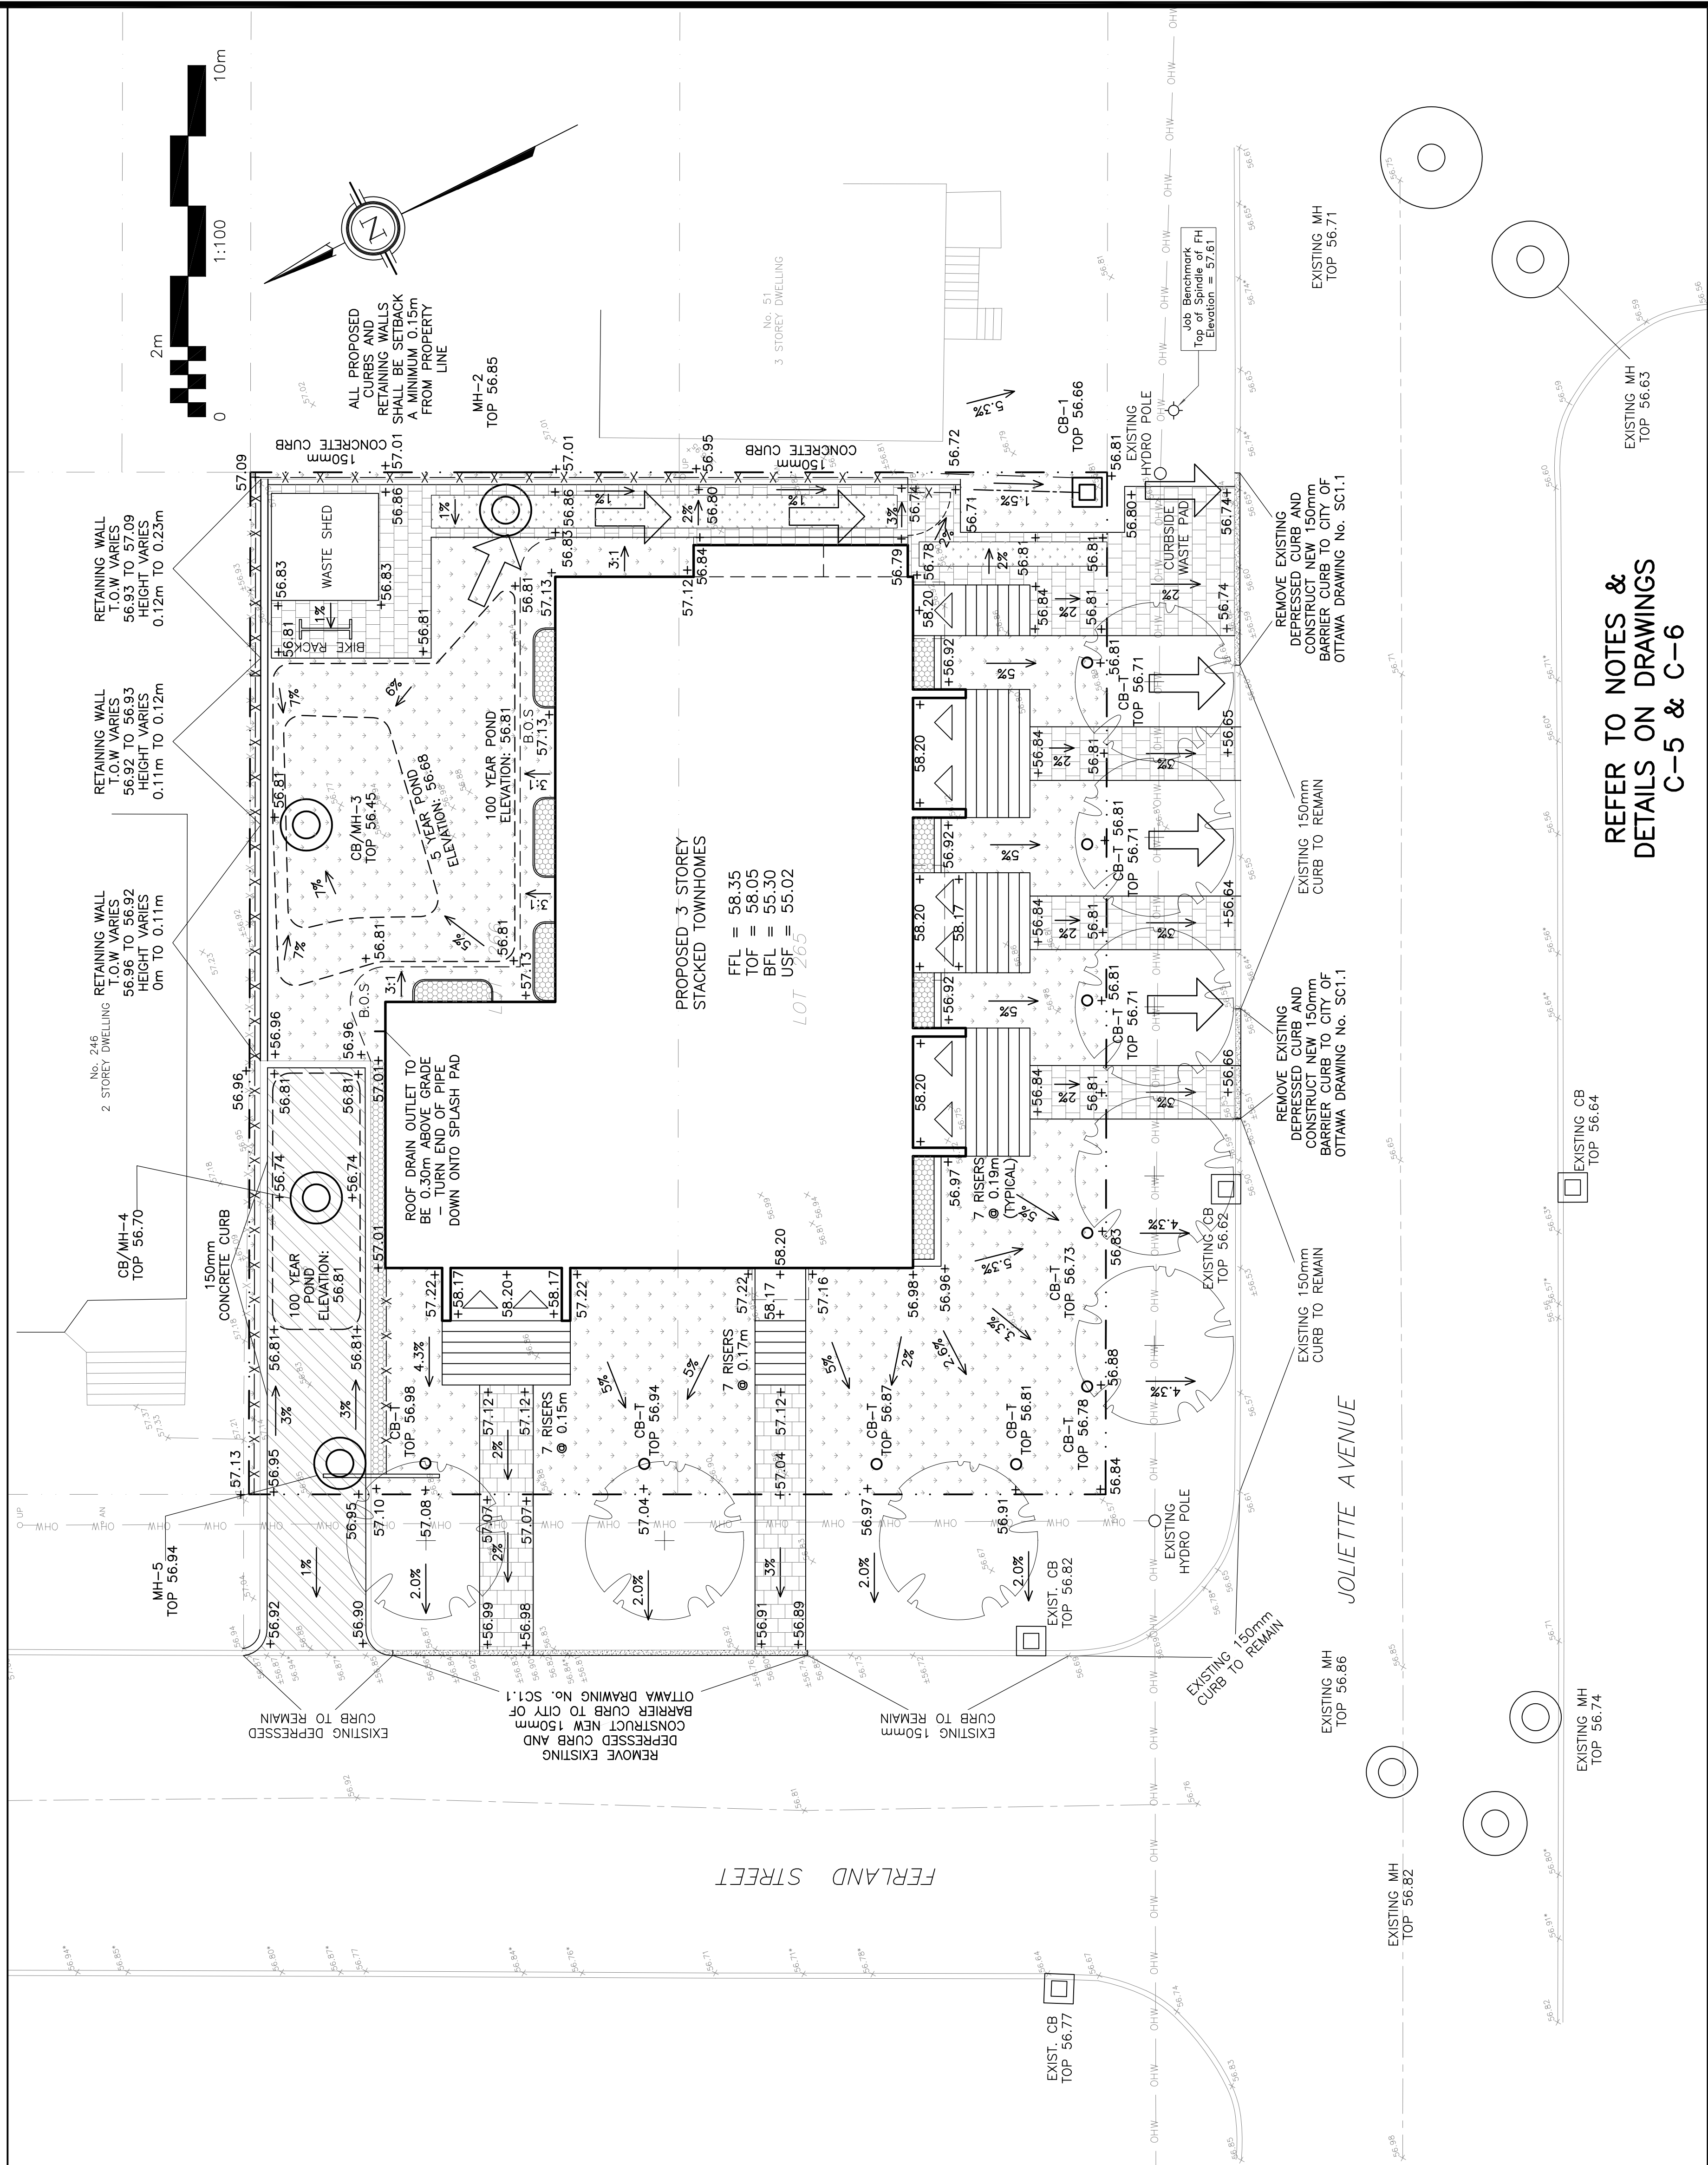

REFER TO NOTES &
DETAILS ON DRAWINGS
C-5 & C-6