


JRP ENGINEERING

Professional Engineers

9 Holgate Court, Kanata, ON, K2K 1B4
 Tel: 613-627-2462 Email: Admin@jrpeng.com

An exact copy of all working documents including, without limitations, the original of the present document or plan is kept on file by J.R.P. Engineering. Any modification carried out to this document or plan or to accompanying documents without written authorization by the engineer is prohibited.


Authorized modifications must be signed and sealed by an engineer and this engineer will be completely responsible for these modifications. J.R.P. Engineering is not and will not be responsible for the consequences of these modifications or for modifications carried out without its consent.

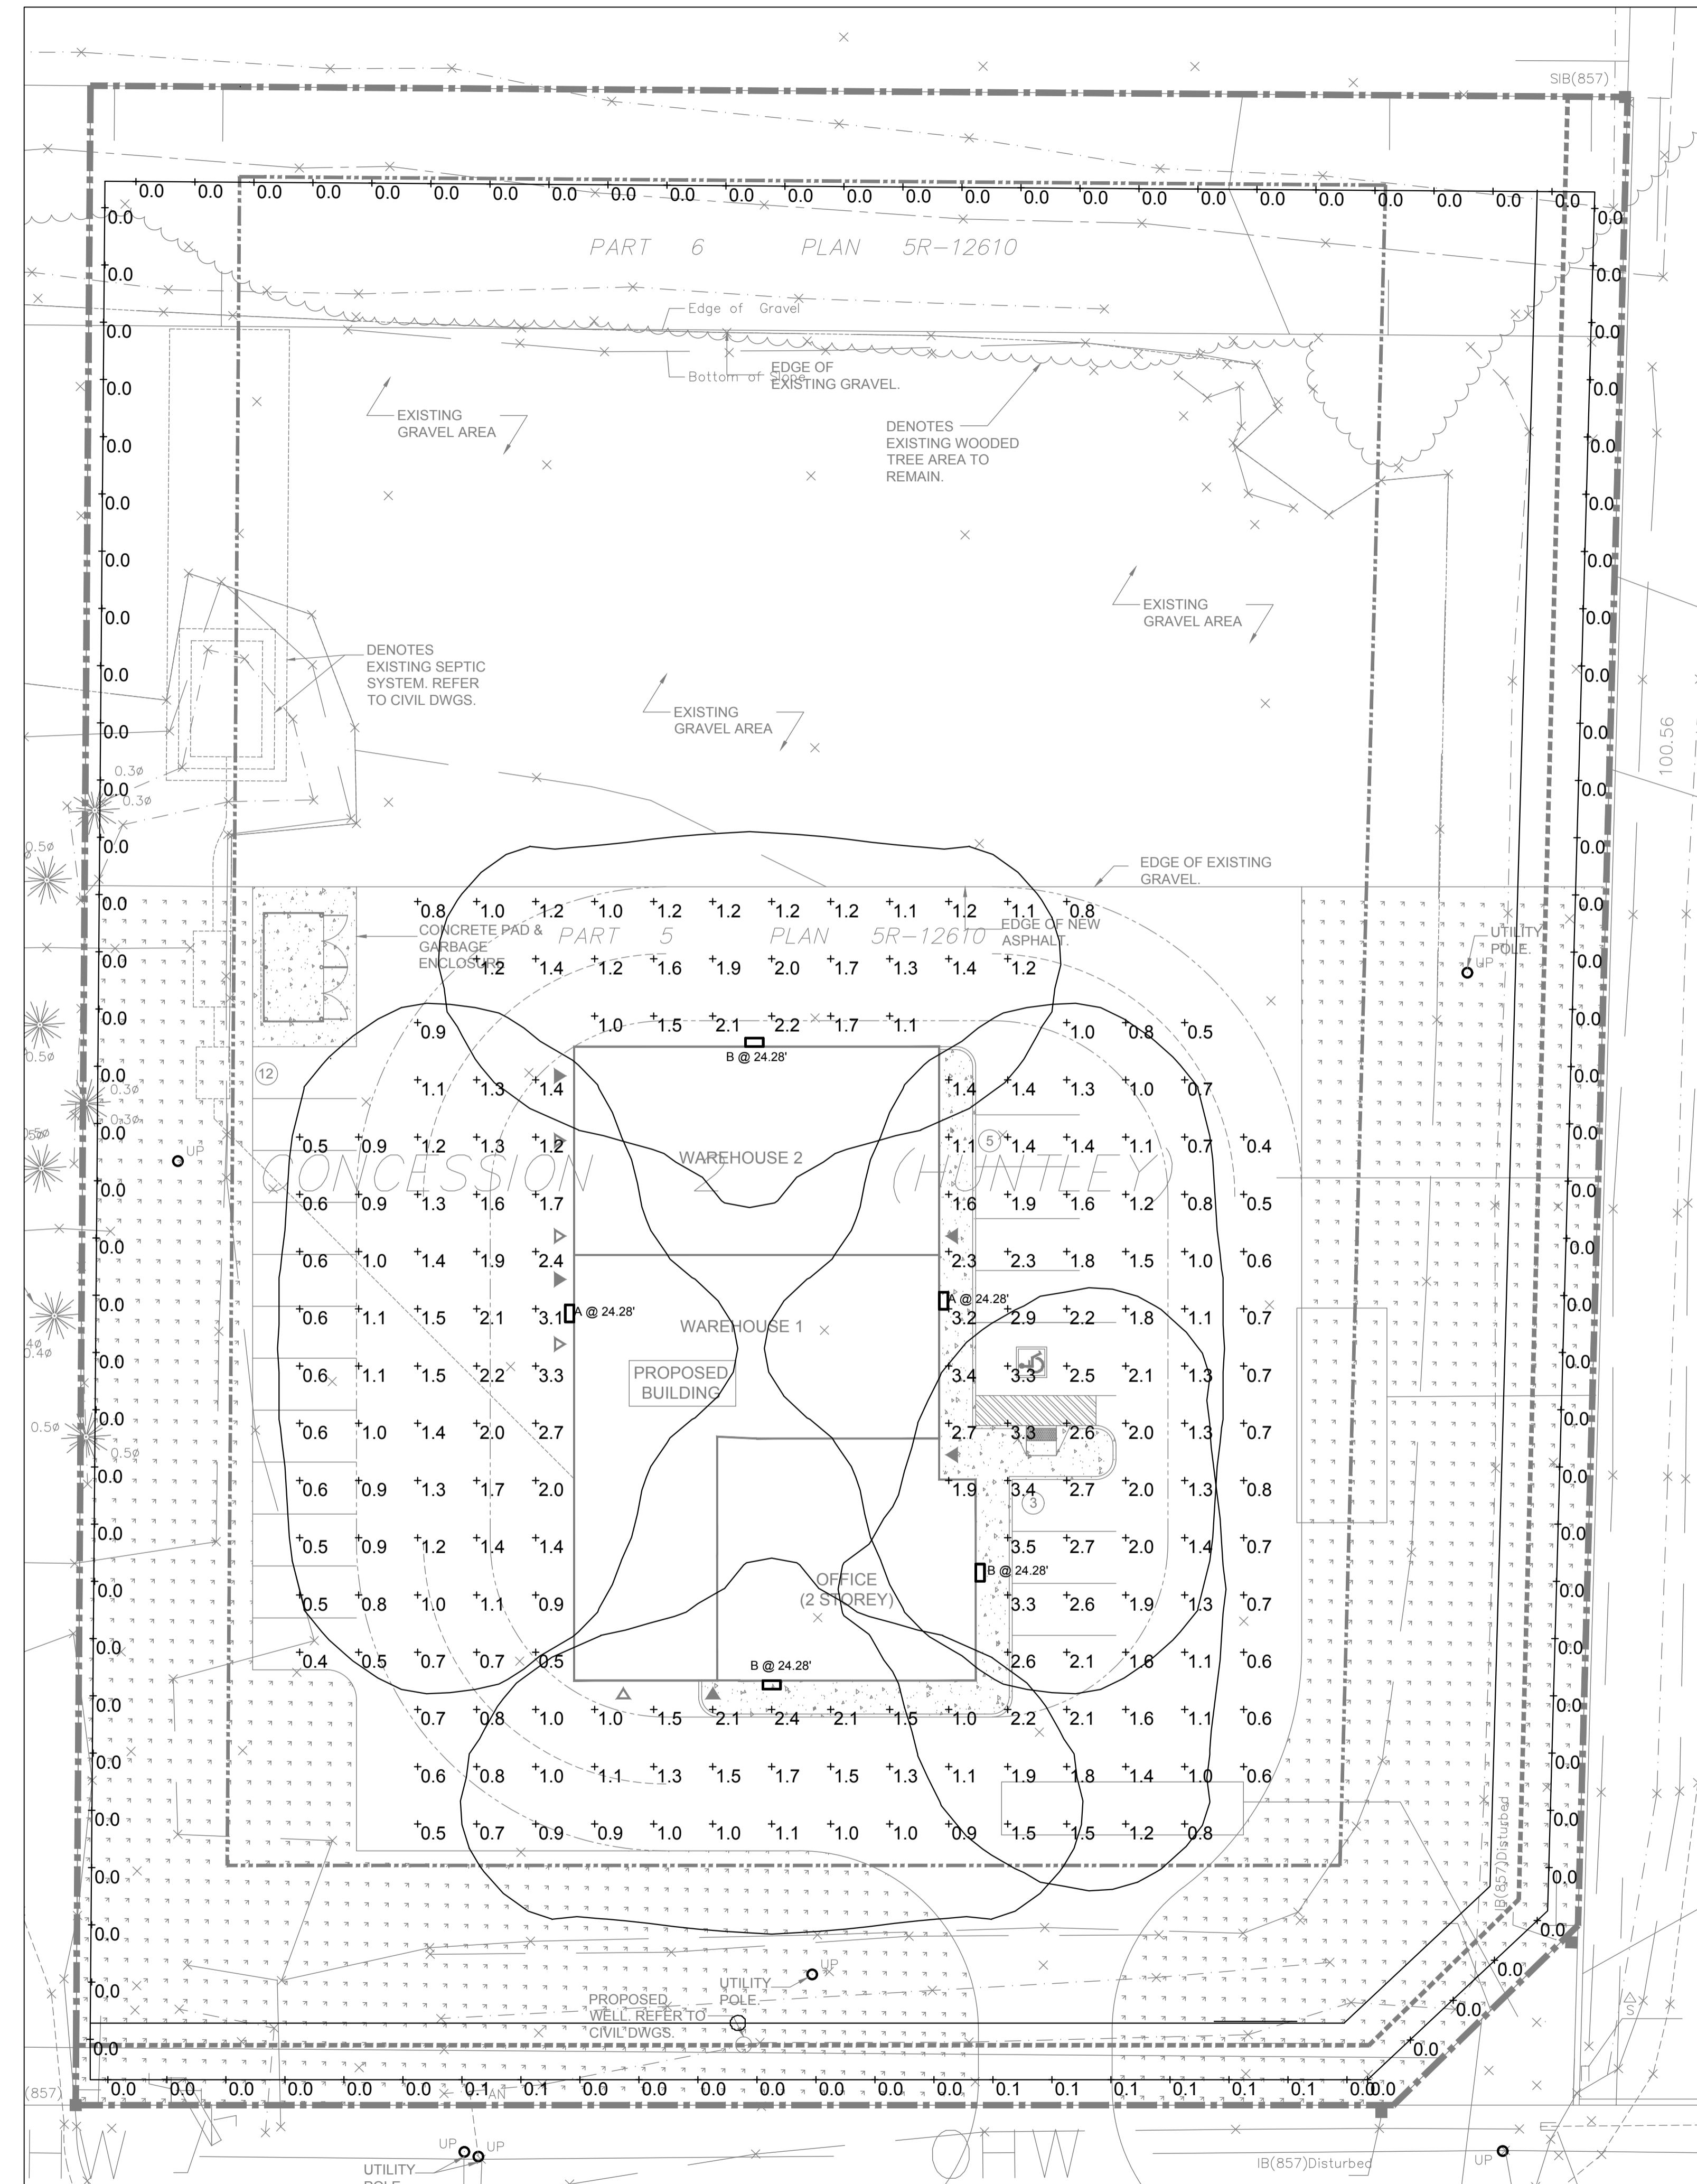

1 SITE LIGHTING PLAN
 E-1 1:200

No	DESCRIPTION	DATE
1	ISSUED FOR SITE PLAN R1	JUNE 2 2021
0	ISSUED FOR SITE PLAN	FEB 3 2021

REVISIONS

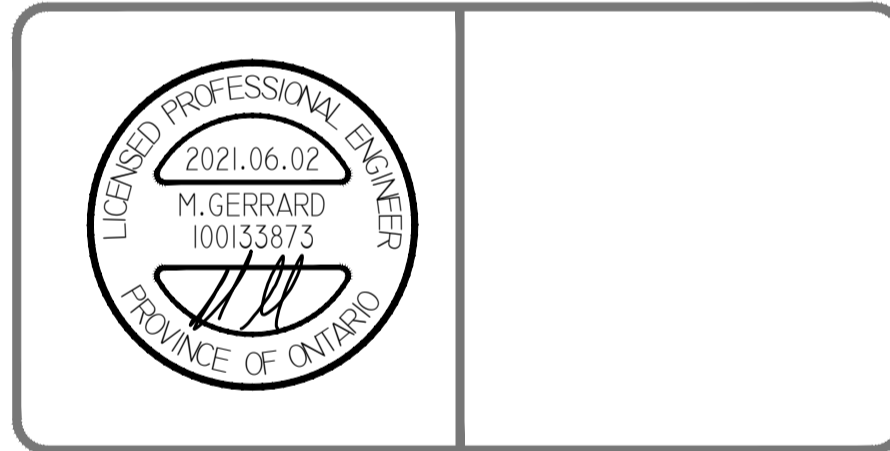

client:

project:
INDUSTRIAL BUILDING
 2167 MCGEE SIDE ROAD
 OTTAWA, ONTARIO

drawing title:
SITE LIGHTING PLAN

scale:	AS NOTED	drawn by:	C.M.
designed by:	C.M.	reviewed by:	M.G.
approved by:	M.G.	date:	MAR 2021

project no.:	100-2103	drawing no.:	E-1
revision:	<0>		of 1

D07-12-21-0027