

JRP ENGINEERING
Professional Engineers

9 Holgate Court, Kanata, ON, K2K 1B4
Tel: 613-627-2462 Email: Admin@jrpeng.com

An exact copy of all working documents including, without limitations, the original of the present document or plan is kept on file by J.R.P. Engineering Any modification carried out to this document or plan or to accompanying documents without written authorization by the engineer is prohibited.

Authorized modifications must be signed and sealed by an engineer and this engineer will be completely responsible for these modifications. J.R.P. Engineering is not and will not be responsible for the consequences of these modifications or for modifications carried out without it's consent.

0	ISSUED FOR SITE PLAN	MAR 08 2021
No	DESCRIPTION	DATE
REVISIONS		



client:

project:

ELECTRICAL
PHOTOMETRIC

1592, TENTH LINE RD,
OTTAWA, ONTARIO

drawing title:

SITE LIGHTING
PHOTOMETRIC

scale:	AS NOTED	drawn by:	C.M.
designed by:	C.M.	reviewed by:	M.G.
approved by:	M.G.	date:	MAR 2021

project no.:


100-2104

revision:

<0>

drawing no.:

E1
of 1

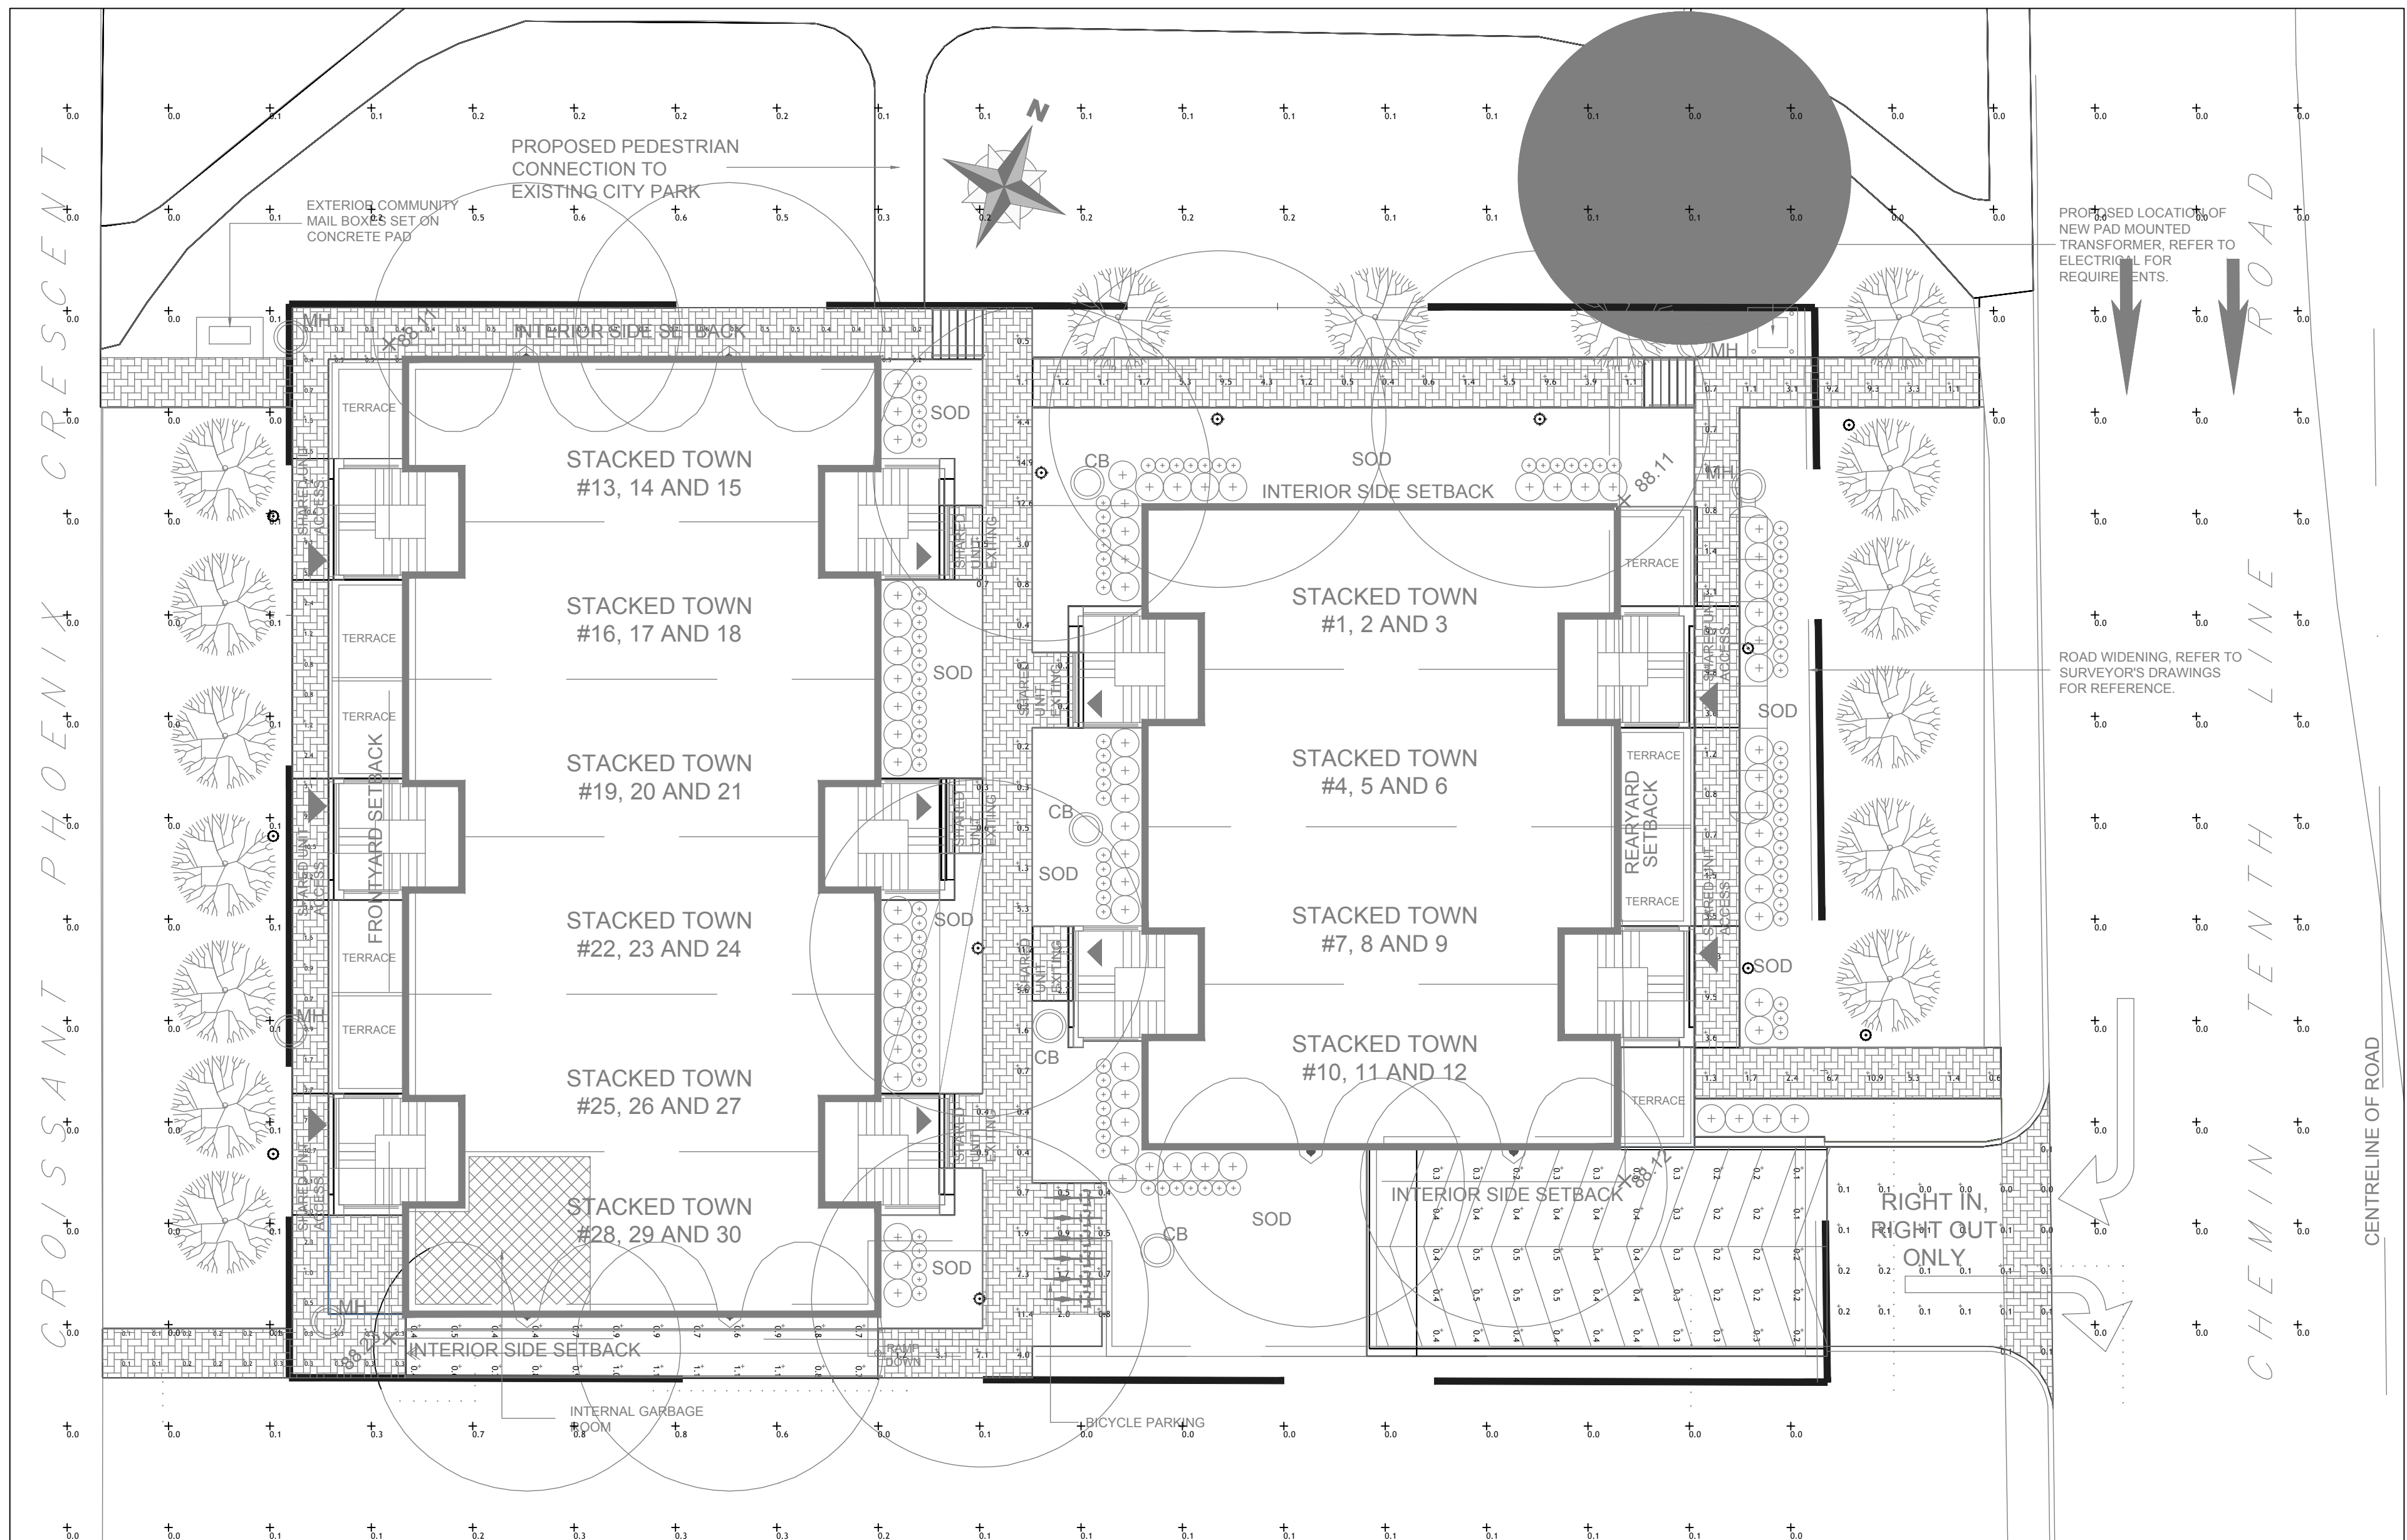

LIGHTING SCHEDULE						
Symbol	Qty	Label	Arrangement	LLF	Description	Lum. Lumens
+	12	B	SINGLE	0.900	BL25-NW-G1-5-8-BZ	2539
⬤	6	C	SINGLE	0.900	7177-34-H16-40K	1624