

\\014114255\GP\Drawings\Phase 2\Phase 3\114025-GP-PH3.dwg, GP, Jul 23, 2021, 12:28pm, mmpedro

NOTE:
THE POSITION OF ALL POLE LINES, CONDUITS,
WATERMAINS, SEWERS AND OTHER
UNDERGROUND AND OVERGROUND UTILITIES AND
STRUCTURES IS NOT NECESSARILY SHOWN ON
THE CONTRACT DRAWINGS, AND WHERE SHOWN,
THE ACCURACY OF THE POSITION OF SUCH
UTILITIES AND STRUCTURES IS NOT GUARANTEED.
BEFORE STARTING WORK, DETERMINE THE EXACT
LOCATION OF ALL SUCH UTILITIES AND
STRUCTURES AND ASSUME ALL LIABILITY FOR
DAMAGE TO THEM.

PRELIMINARY
NOT FOR
CONSTRUCTION

REVISION			
No.	REVISION	DATE	BY
5.	ISSUED WITH SITE PLAN APPLICATION	JUL 22/21	JAG
4.	ISSUED FOR INFORMATION	MAR 19/21	JAG
3.	RE-ISSUED FOR COORDINATION	FEB 17/21	JAG
2.	ISSUED FOR COORDINATION	DEC 4/20	JAG
1.	ISSUED FOR DISCUSSION PURPOSES	DEC 2/20	JAG

SCALE			
1:250			
0 2 4 6 8 10			

DESIGN	JAG
CHECKED	MSP
DRAWN	MTM
CHECKED	JAG
APPROVED	JGR

FOR REVIEW ONLY





NOVATECH
Engineers, Planners & Landscape Architects
Suite 200, 240 Michael Cowpland Drive
Ottawa, Ontario, Canada K2M 1P6
Telephone (613) 254-9643
Facsimile (613) 254-5867
Website www.novatech-eng.com

LOCATION
CITY OF OTTAWA
GREYSTONE VILLAGE PHASE 3

DRAWING NAME
GENERAL PLAN OF SERVICING

PROJECT No.
114025-PH3
REV
REV # 5
DRAWING No.
114025-GP(PH3)

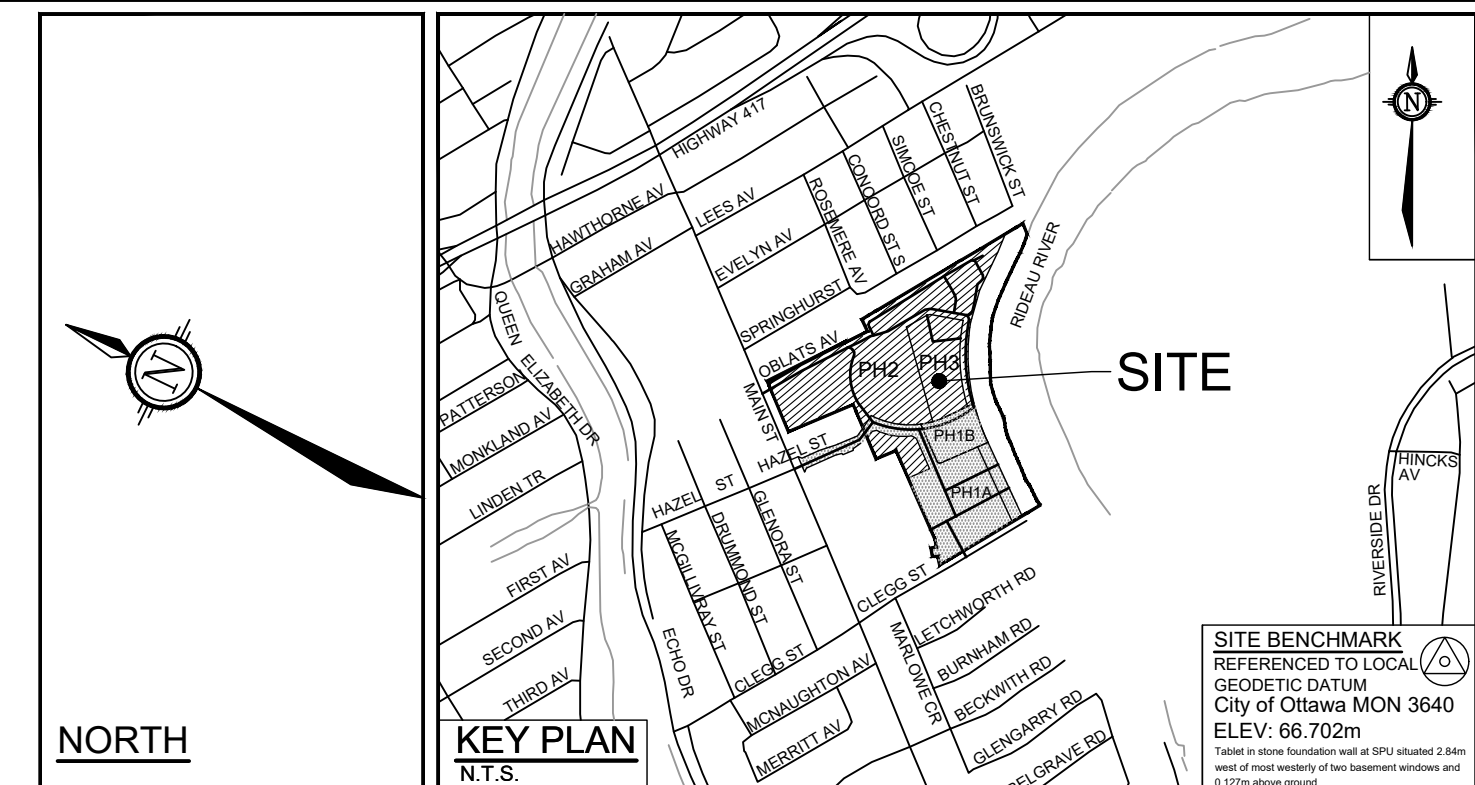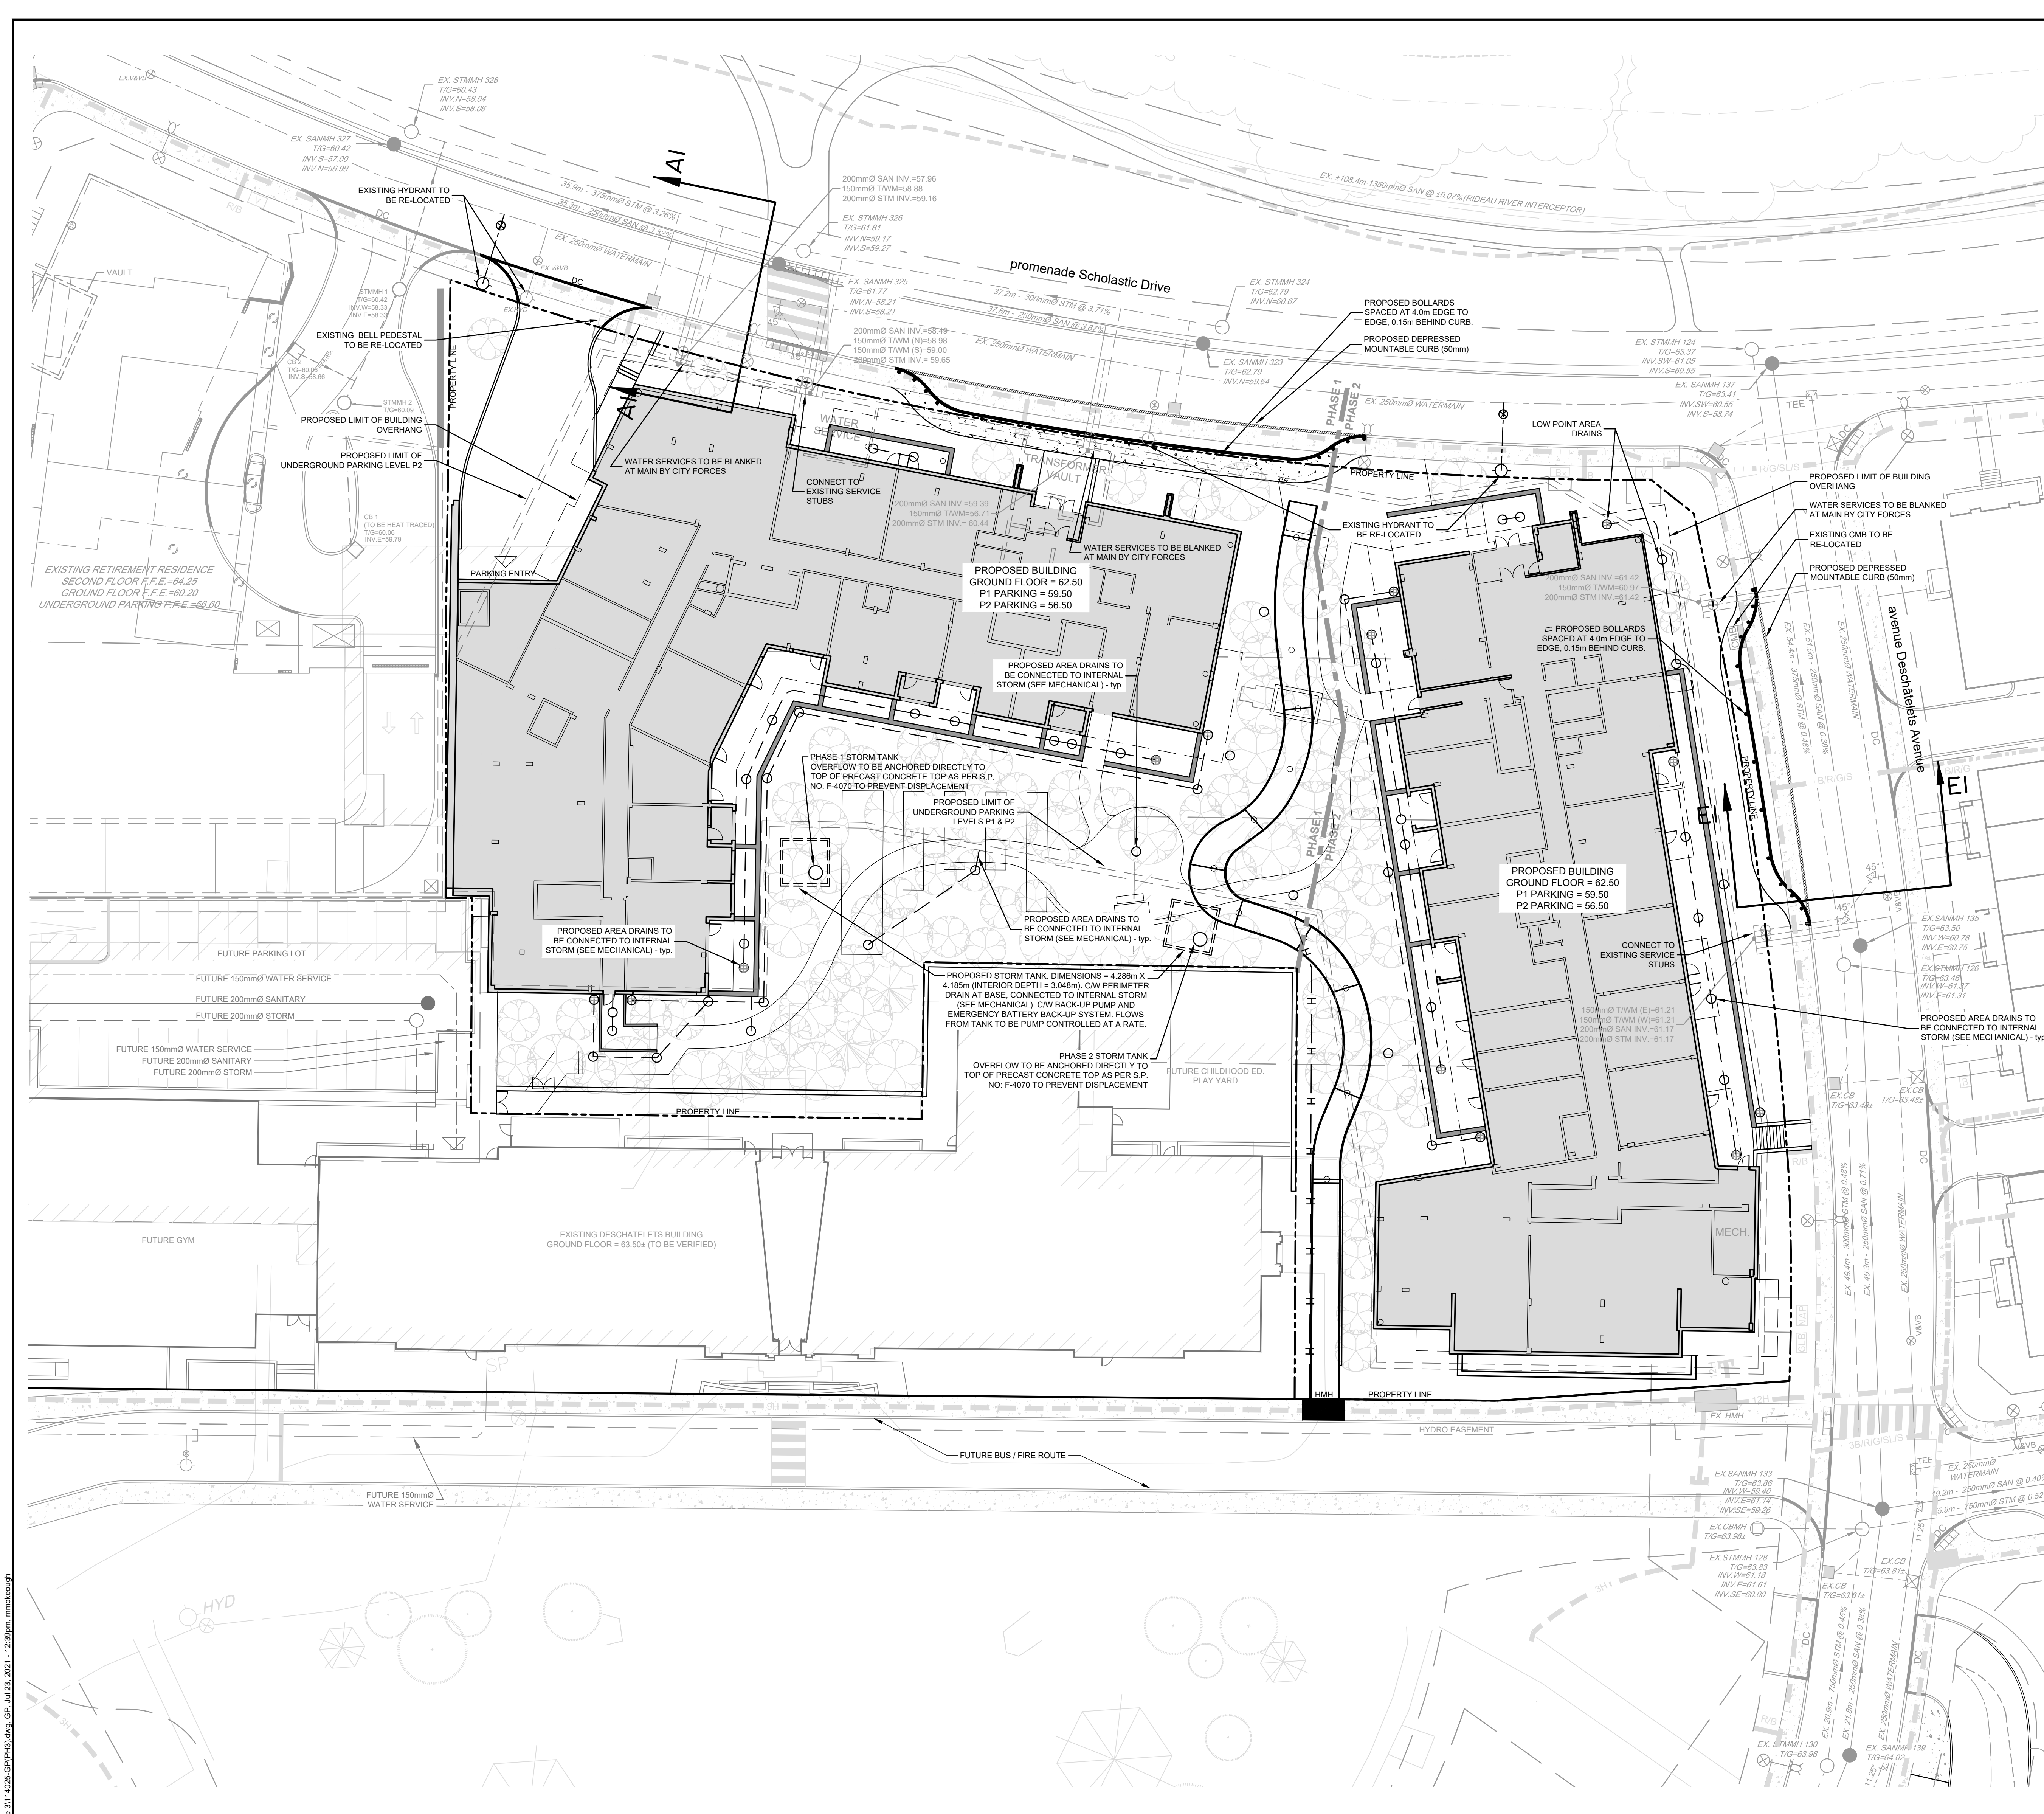

LEGEND	
--- SITE BOUNDARY	--- EXISTING ADJACENT PROPERTY LINE
--- PROPOSED STORM SEWER AND DIRECTION OF FLOW	--- EXISTING STORM MANHOLE AND SEWER
--- PROPOSED SANITARY SEWER AND DIRECTION OF FLOW	--- EXISTING SANITARY MANHOLE AND SEWER
--- PROPOSED WATERMAIN	--- EXISTING WATERMAIN
--- PROPOSED LANDSCAPE TEE	--- EXISTING VALVE AND VALE BOX
--- PROPOSED LANDSCAPE ELBOW	--- EXISTING FIRE HYDRANT
--- PROPOSED VALVE AND VALVE BOX	--- EXISTING CATCH BASIN
--- PROPOSED WATER METER LOCATION	--- EXISTING TOP OF GRATE
--- PROPOSED REMOTE METER LOCATION	--- EXISTING UTILITY POLE C/W GUY WIRES
--- PROPOSED SANITARY / STORM MONITORING TEST PORT	--- EXISTING STREET LIGHT
--- PROPOSED TRENCH DRAIN	--- EXISTING ROGERS NETWORK ACCESS POINT
--- PROPOSED SIAMSE CONNECTION	--- EXISTING BELL GRADE LEVEL BOX
--- PROPOSED BUILDING ENTRANCE	--- EXISTING UNDERGROUND CABLE (BELL, ROGERS, GAS, STREETLIGHT)
--- PROPOSED LIMITS OF UNDERGROUND PARKING	--- EXISTING UNDERGROUND HYDRO
--- PROPOSED RETAINING WALL	--- EXISTING HYDRO MANHOLE
--- PROPOSED BARRIER CURB	--- EXISTING COMMUNITY MAILBOX
--- PROPOSED DEPRESSION CURB	
--- PROPOSED GUARD RAIL FENCE	
--- PROPOSED TREES / SHRUBS	
--- PROPOSED UNDERGROUND HYDRO	
--- PROPOSED HYDRO MANHOLE	

