
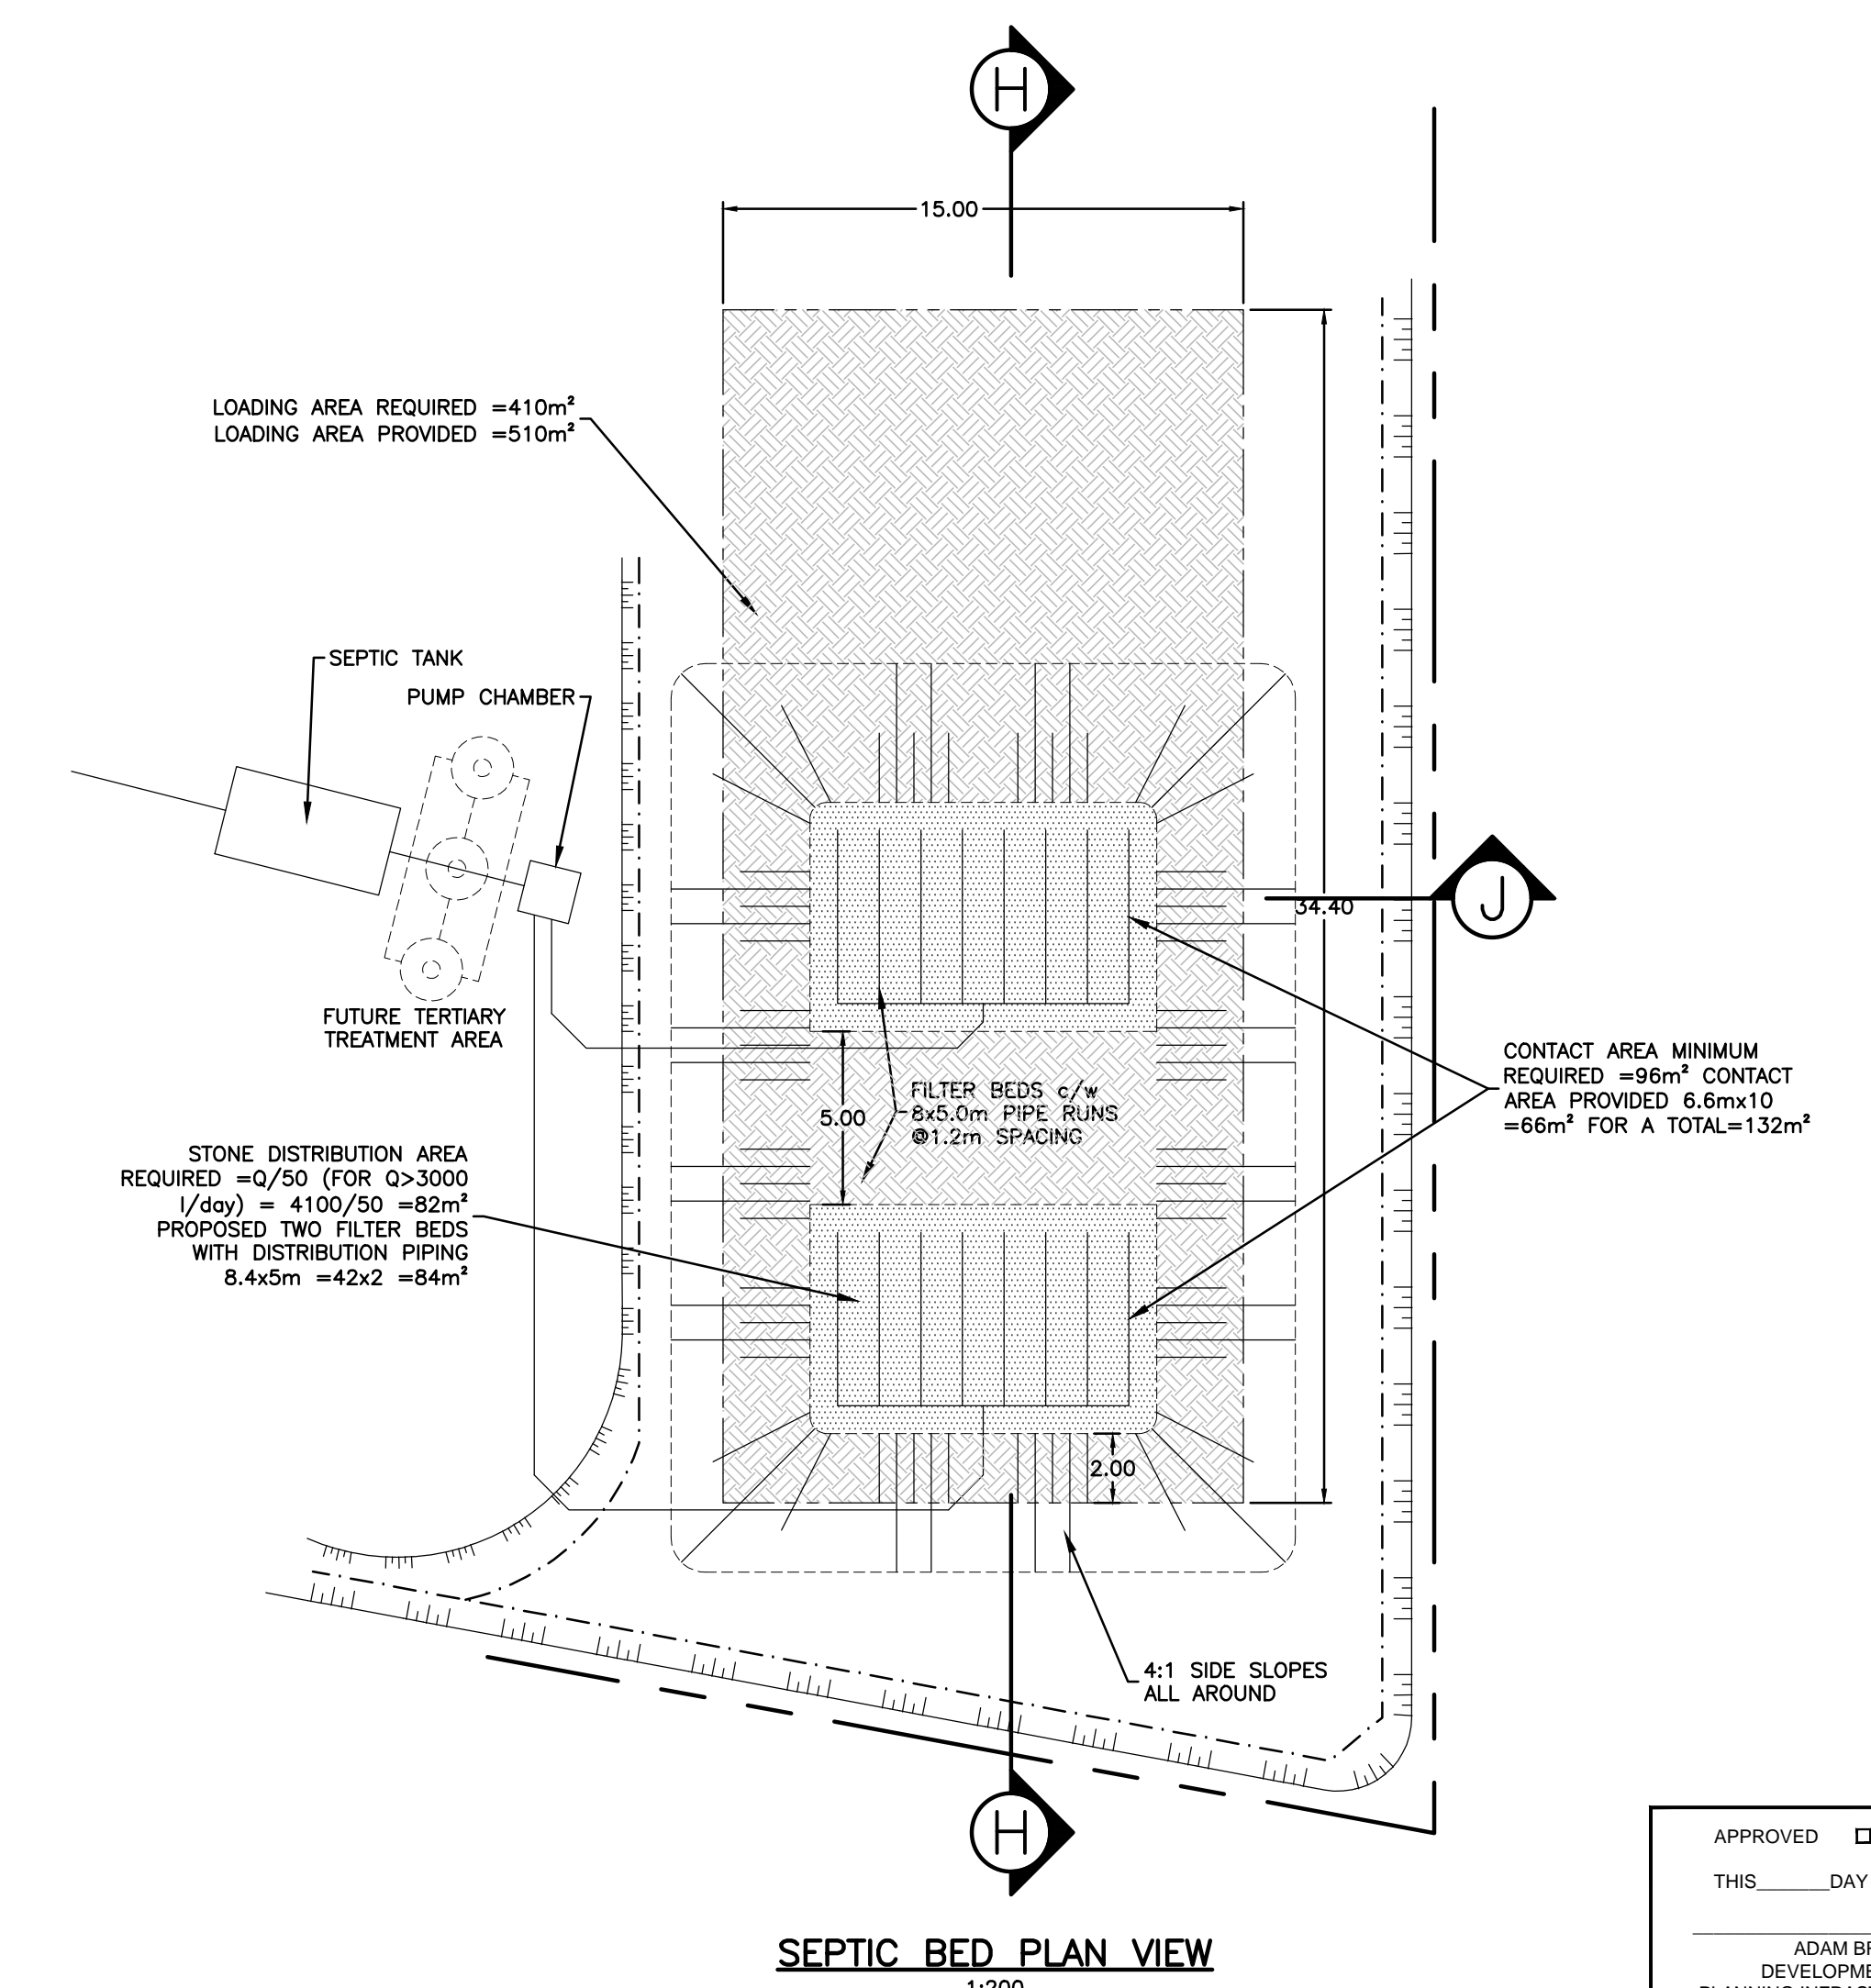
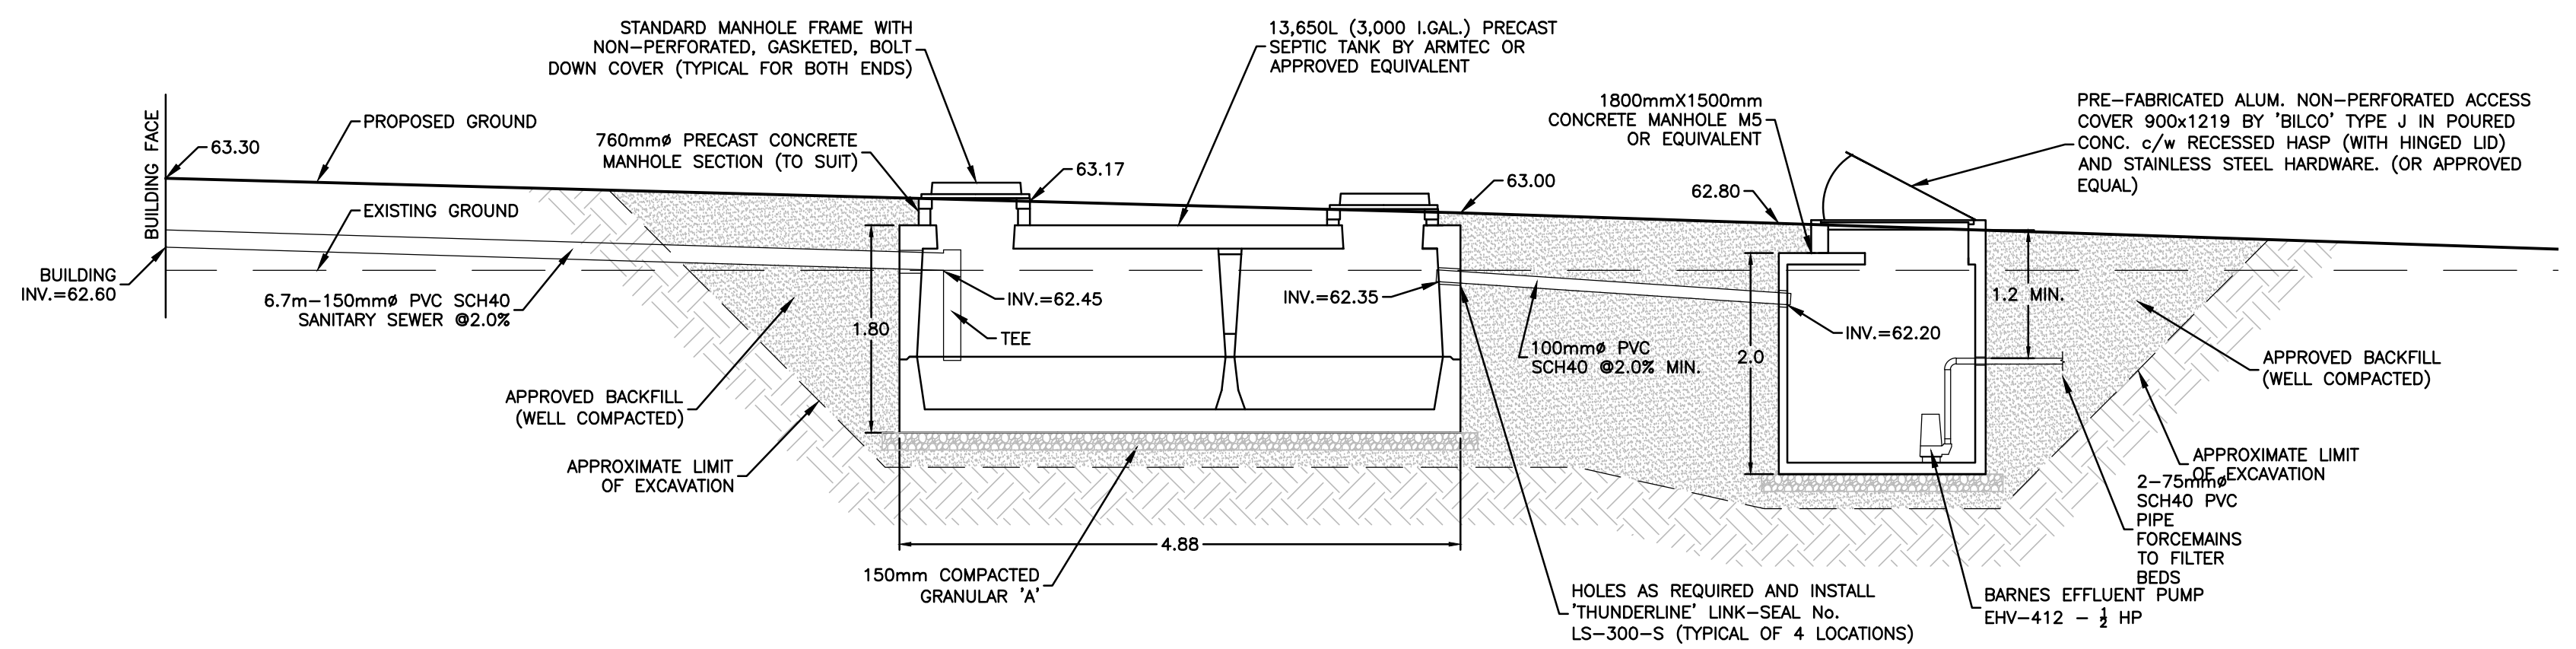
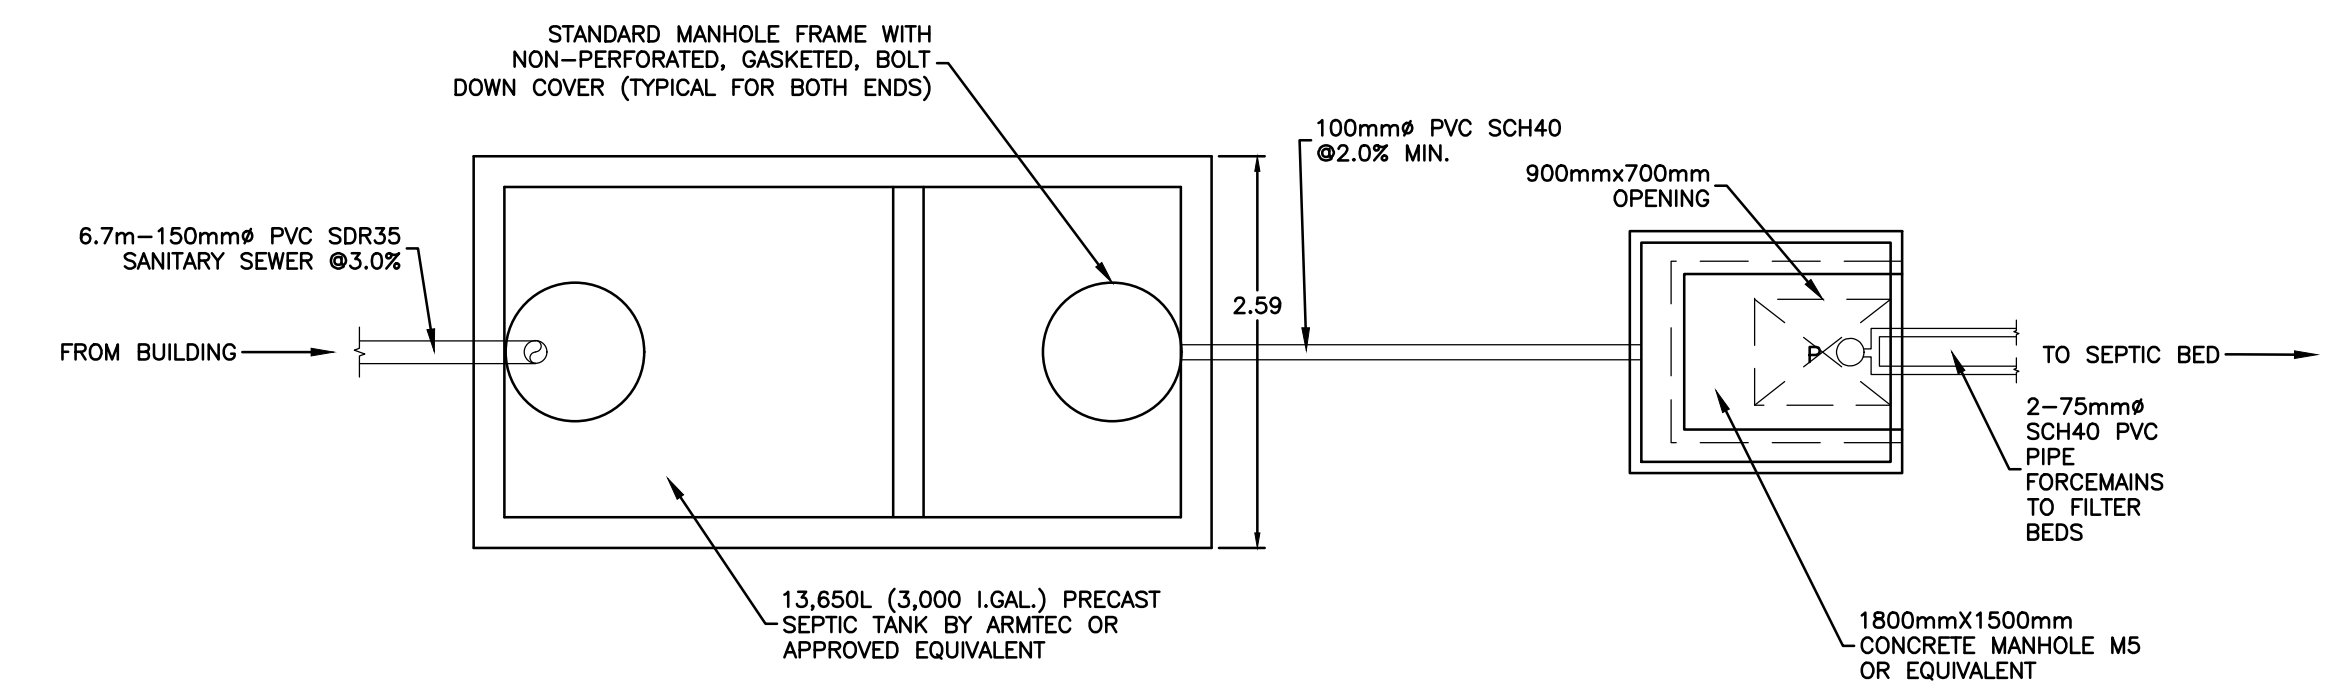
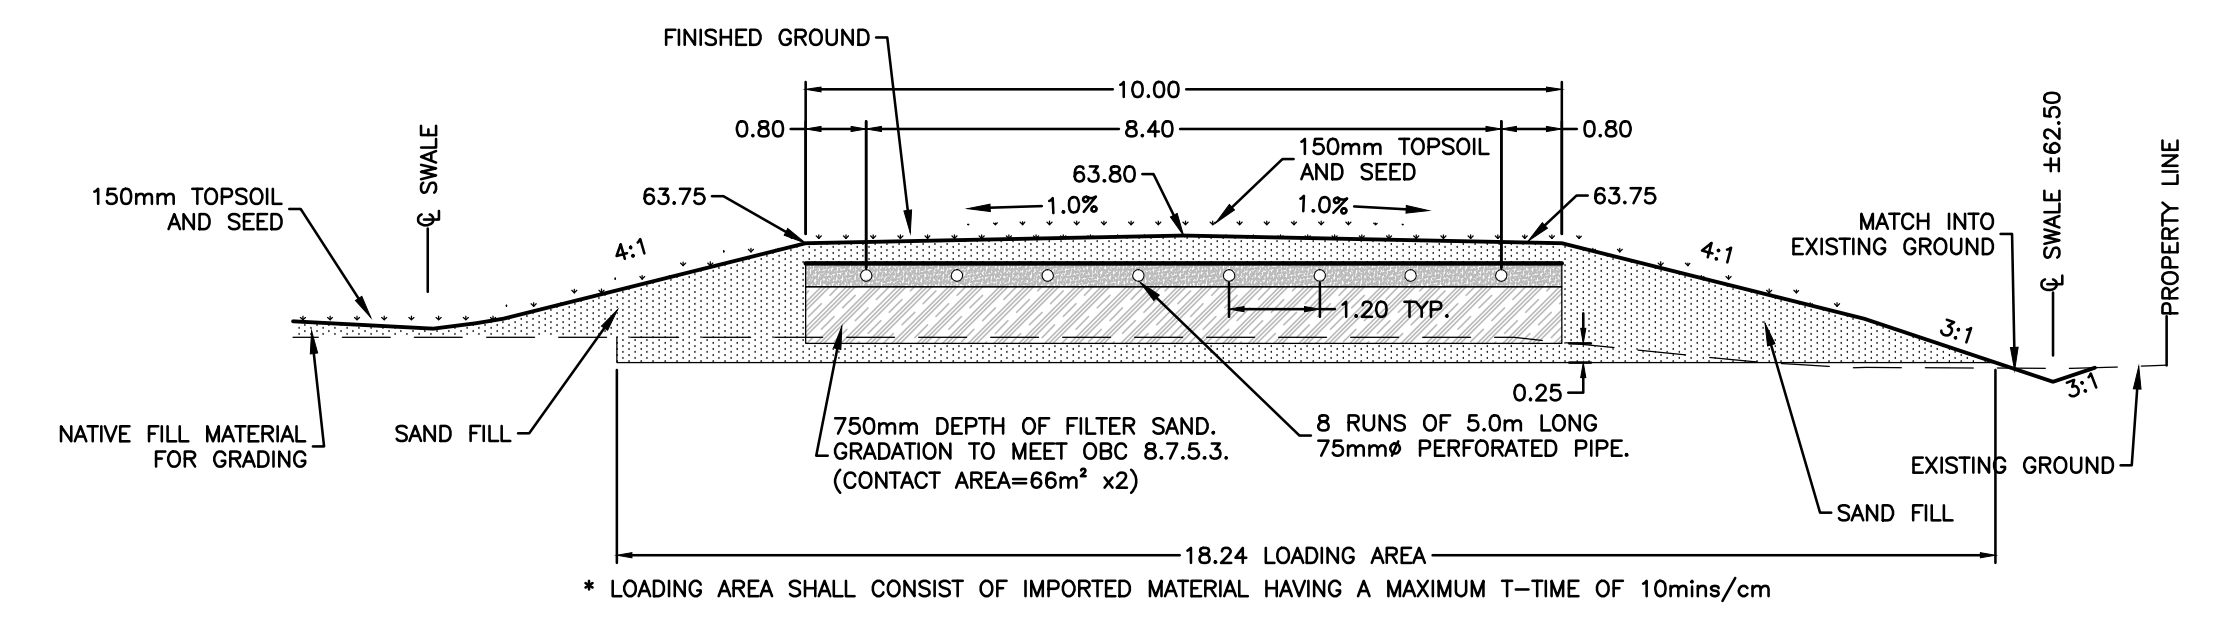


SEPTIC SYSTEM NOTES

1. THE PROPOSED SEPTIC SYSTEM SHOULD BE INSTALLED IN ACCORDANCE WITH THE CURRENT ONTARIO BUILDING CODE, CITY OF OTTAWA AND OTTAWA SEPTIC SYSTEM OFFICE REQUIREMENTS AND THE SERVING REPORT PREPARED BY EXP SERVICES INC.
2. THE PROPOSED SEPTIC SYSTEM HAS BEEN DESIGNED BASED ON SEWAGE DESIGN FLOW OF 4,100 L/DAY.
3. THE FOLLOWING SETBACKS ARE REQUIRED:
 - DISTRIBUTION PIPE TO PROPERTY LINE - 3.0m MINIMUM
 - DISTRIBUTION PIPE TO STRUCTURE - 5.0m MINIMUM
 - DISTRIBUTION PIPE TO WELL - 15.0m MINIMUM
 - SEPTIC TANK/TERTIARY UNIT TO STRUCTURE - 1.5m MINIMUM
 - SEPTIC TANK/TERTIARY UNIT TO PROPERTY LINE - 3.0m MINIMUM
 - SEPTIC TANK/TERTIARY UNIT TO WELL - 15.0m MINIMUM
4. CONSTRUCTION TRAFFIC AND MATERIALS ARE TO BE KEPT AWAY FROM THE SEPTIC SYSTEM, INCLUDING THE MANTLE.
5. THE CONTRACTOR IS RESPONSIBLE FOR PROVIDING AS-BUILT ELEVATIONS AND PROVIDING THE REQUIRED AS-BUILT INFORMATION AND DRAWINGS TO THE OTTAWA SEPTIC SYSTEM OFFICE.

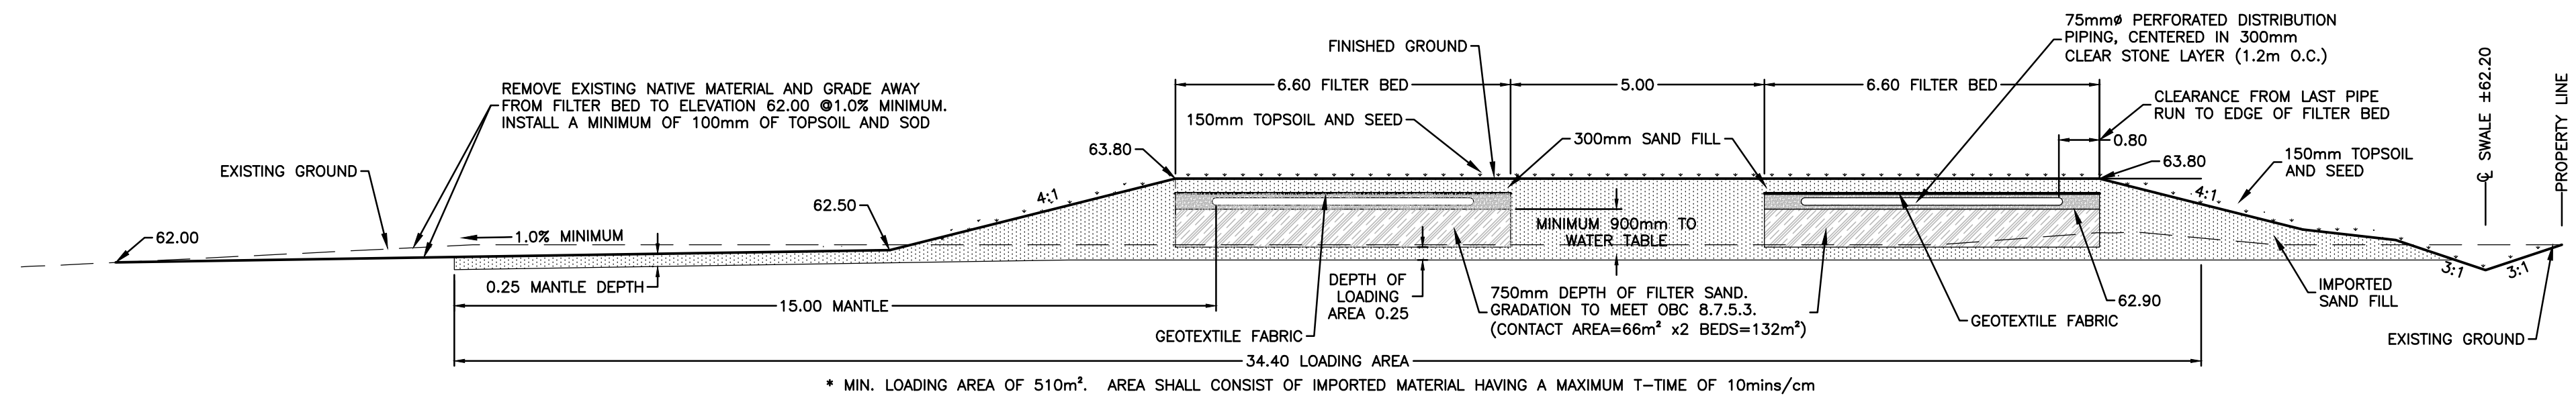

APPROVED REFUSED

THIS _____ DAY OF _____ 20___

ADAM BROWN, MANAGER
DEVELOPMENT REVIEW - RURAL
PLANNING INFRASTRUCTURE AND ECONOMIC
DEVELOPMENT DEPARTMENT, CITY OF OTTAWA

File Name: \\exp\projects\2016\09\01\h1\engineering\servicing\2016\09\01\h1\exp\00229886-ao - humanics_sanctuary\01\project\electronic\dwg\00229886-dwg.dwg
 User: JTB
 Date: 2016-09-09 12:14:41 PM
 Plotted by: jbtomlin
 Scale: 1:50

NO.	REVISION DESCRIPTION	DATE	BY	APPD	NO.	REVISION DESCRIPTION	DATE	BY	APPD
4	ISSUED FOR SITE PLAN AMENDMENT	03/12/21	AJ	BMT					
3	CITY STAMP ADDED	13/12/17	SAB	BMT					
2	REVISED SEPTIC BED	25/07/17	SAB	JLF					
1	REVISED AS PER CITY COMMENTS	25/01/17	SAB	BMT					

SCALE	DESIGNED BY	REVIEWED BY	CLIENT
AS NOTED			HUMANICS UNIVERSAL INC. 601 BROOKRIDGE CRES ORLEANS, ON K4A 1Z6, 613-824-1525

exp SERVICES INC.
1-813-888-1888 | 1-613-225-7300
300-2222 Avenue Drive, Unit 100
Ottawa, ON K2B 8R8
Canada
www.exp.com

BUILDINGS • EARTH & ENVIRONMENT • ENERGY •
INDUSTRIAL • INFRASTRUCTURE • SUSTAINABILITY

PROJECT	DESIGN	DRAWN	CHECKED	TITLE
HUMANICS SANCTUARY 3400/3468 OLD MONTREAL ROAD ORLEANS, ONTARIO.	J. FITZPATRICK	B. THOMAS	J. FITZPATRICK	SEPTIC BED DETAILS

PROJ. NO.	SURVEY	DATE	DRAWING NO.
OTT-00229886-AO	exp	FEB 09, 2016	DET2

D07-12-16-0081