


**LEGEND**

DRAINAGE AREA: X XXX 0.XX

AREA (sq.m)

5 YEAR RUNOFF COEFFICIENT

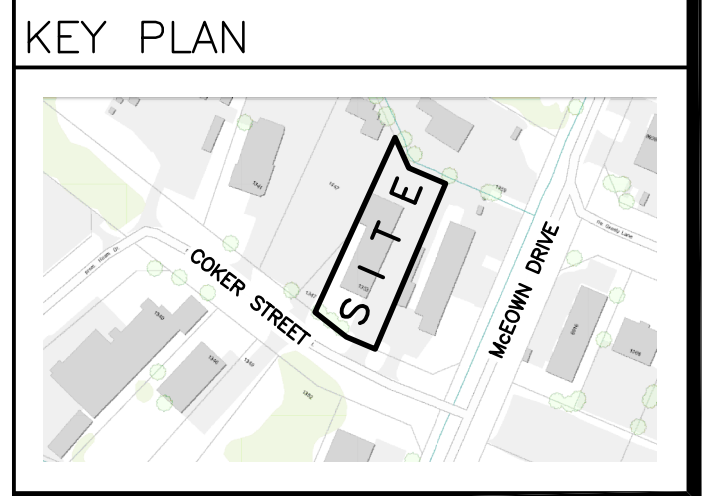


No.	DATE	REVISION
2	MAR 7-22	ISSUED FOR APPROVAL
1	FEB 15-22	ISSUED FOR COORDINATION

**D. B. GRAY ENGINEERING INC.**  
 Stormwater Management - Grading & Drainage - Storm & Sanitary Sewers - Waterworks  
 700 Long Point Circle Ottawa, Ontario  
 613-425-8044 d.gray@dbgrayengineering.com

**Project**  
 PROPOSED 1-STORY WAREHOUSE  
 1353 COKER STREET  
 OTTAWA, ONTARIO

**Drawing Title**  
 PRE- AND POST-DEVELOPMENT DRAINAGE PLANS

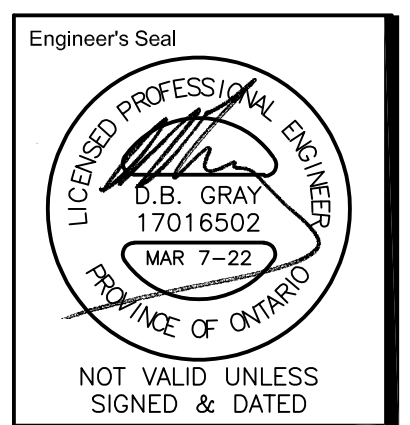

Drawn: D.B.G.  
 H. Scale: 1:150  
 V. Scale:  
 Date: FEB 15-22  
 Job No.: 20127

Drawing No.  
**C-4 of 4**

NOT VALID UNLESS SIGNED & DATED