


CB	CATCH-BASIN
MH	STORM MANHOLE
CB/MH	CATCH BASIN/MANHOLE
MH	SANITARY MANHOLE
VC	VALVE CHAMBER
SPL	SPRINGLINE OF PIPE
INV	INVERT OF PIPE
SAN	SANITARY SEWER
ST	STORM SEWER
WS/WM	WATER SERVICE/WATERMAIN
CS	CURB STOP & STANDPOST
VB	VALVE & VALVE BOX
FR	FIRE HYDRANT
x 99.99	EXISTING GRADE ELEVATION
—	OVER HEAD WIRE
—	HYDRO
— B —	BELL TELEPHONE
— G —	CABLE
— T —	TRAFFIC
— · —	PROPERTY LINE

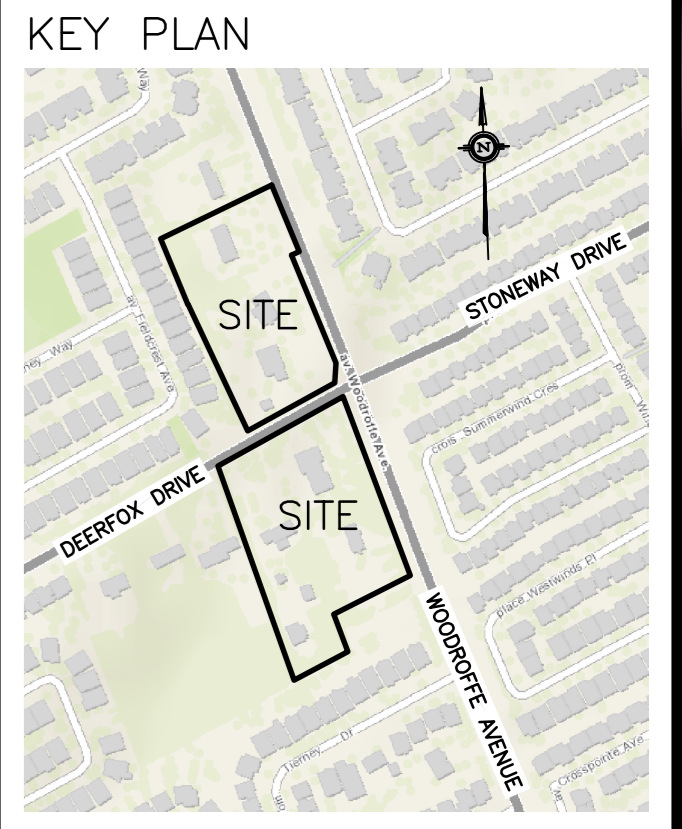

No.	DATE	REVISION
3	MAR 17-22	RE-ISSUED TO CITY FOR APPROVAL
2	DEC 21-21	ISSUED TO CITY FOR APPROVAL
1	SEP 28-21	PRELIMINARY

**D. B. GRAY ENGINEERING INC.**  
 Stormwater Management - Grading & Drainage - Storm & Sanitary Sewers - Watermain  
 700 Long Point Circle 613-425-8044  
 Ottawa, Ontario d.gray@dbgrayengineering.com

Project **MUNICIPAL SANITARY SEWER EXTENSION CROSSING WOODROFFE AVE WEST FROM STONEWAY DR NORTH ON WOODROFFE AVE & WEST ON DEERFOX DR OTTAWA, ONTARIO**

Drawing Title  
**PLAN AND PROFILE**  
 STA A+000.0 TO STA A+035.3

	Drawn D.B.G. Hor. Scale 1:100 Vert. Scale 1:20 Date OCT 1-21 Job No. 20055
	Drawing No. <b>C-2</b> of 9

NOT VALID UNLESS SIGNED & DATED

