


CB	☐	CATCH-BASIN
MH	⊙	STORM MANHOLE
CB/MH	⊙	CATCH BASIN/MANHOLE
MH	⊙	SANITARY MANHOLE
VC	⊙	VALVE CHAMBER
SPL	—	SPRINGLINE OF PIPE
INV	—	INVERT OF PIPE
SAN	—	SANITARY SEWER
ST	—	STORM SEWER
WS/WM	—	WATER SERVICE/WATERMAIN
CS	—	CURB STOP & STANDPOST
VB	—	VALVE & VALVE BOX
FH	—	FIRE HYDRANT
—	—	EXISTING GRADE ELEVATION
—	—	OVER HEAD WIRE
—	—	HYDRO
B	—	BELL TELEPHONE
—	—	CABLE
G	—	GAS
T	—	TRAFFIC
—	—	PROPERTY LINE

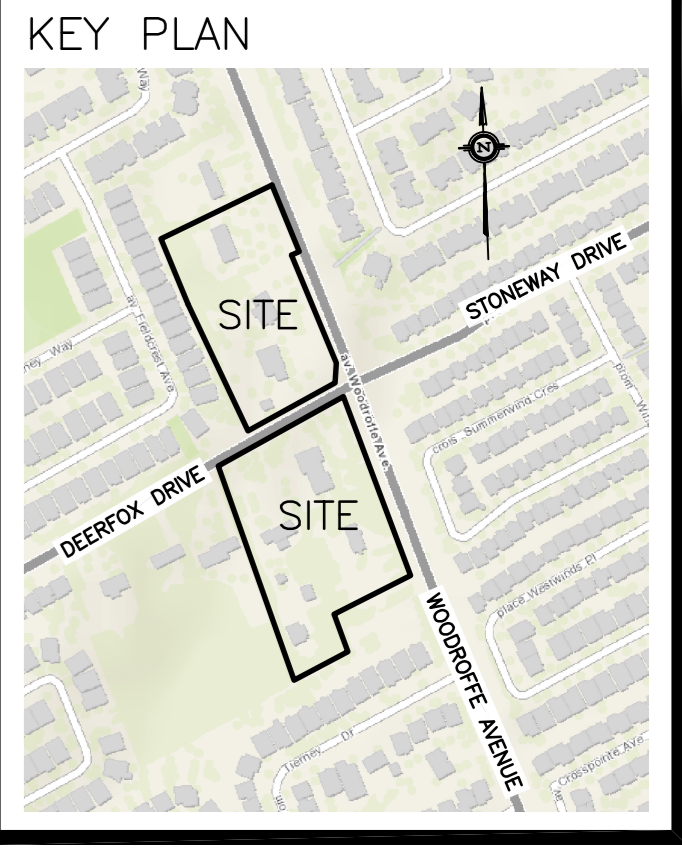


93.00	EXISTING GRADE										93.00
92.00	105.5m - 250 PVC SAN @ 0.24%										92.00
91.00	EXISTING 200 ST										91.00
90.00	MH-SA.6 TOP ±93.05										90.00
89.00	EXISTING GRADE ELEVATION										89.00
EXISTING GRADE ELEVATION	±93.17	±93.16	±93.14	±93.12	±93.08	±93.05	±92.99	±93.05	±93.05	EXISTING GRADE ELEVATION	
SANITARY SEWER INVERT								90.51(SE)	90.61(NW)	SANITARY SEWER INVERT	
CHAINAGE ABOVE PROPOSED SANITARY	B+090		B+100		B+110		B+120		B+130	CHAINAGE ABOVE PROPOSED SANITARY	

No.	DATE	REVISION
3	MAR 17-22	RE-ISSUED TO CITY FOR APPROVAL
2	DEC 21-21	ISSUED TO CITY FOR APPROVAL
1	SEP 28-21	PRELIMINARY

D. B. GRAY ENGINEERING INC.
 Stormwater Management - Grading & Drainage - Storm & Sanitary Sewers - Watermain
 700 Long Point Circle 613-425-8044
 Ottawa, Ontario d.gray@dbgrayengineering.com

Project: **MUNICIPAL SANITARY SEWER EXTENSION CROSSING WOODROFFE AVE WEST FROM STONEWAY DR NORTH ON WOODROFFE AVE & WEST ON DEERFOX DR OTTAWA, ONTARIO**

Drawing Title: **PLAN AND PROFILE**
 STA A 0+090 TO A 0+144.7

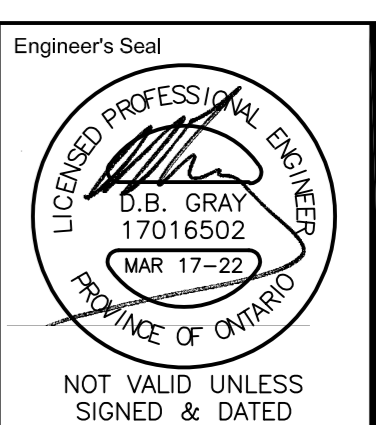

Drawn: D.B.G.
 Hor. Scale: 1:100
 Vert. Scale: 1:20
 Date: OCT 1-21
 Job No.: 20055

Drawing No.: **C-6**
 of 9

NOT VALID UNLESS SIGNED & DATED