



LEGEND

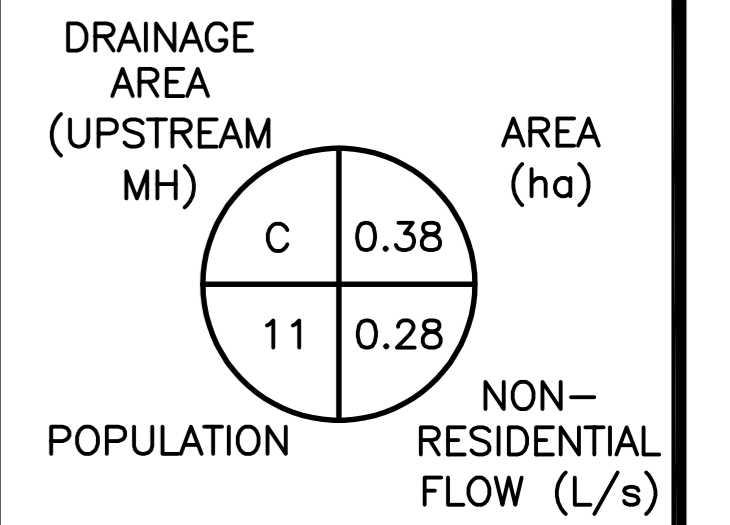

KEY PLAN

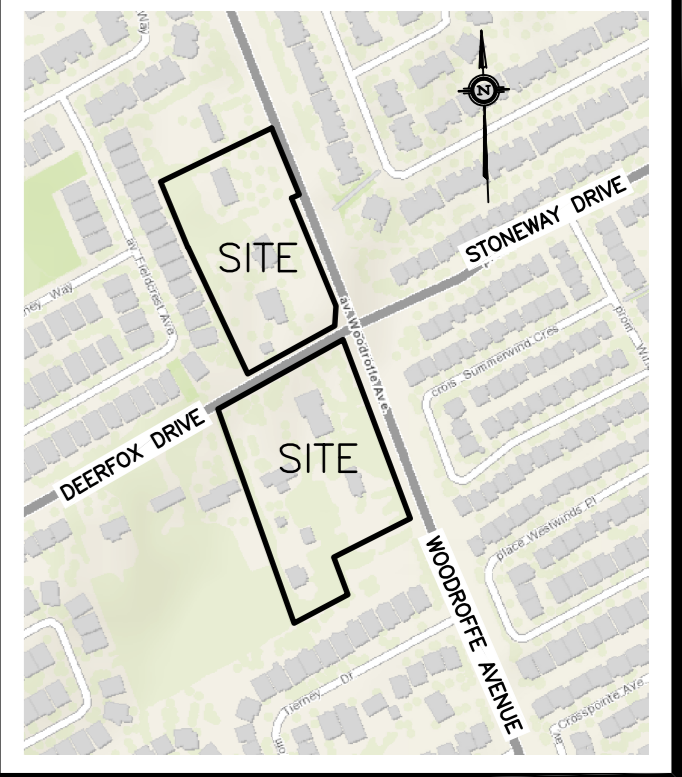

No.	DATE	REVISION
1	MAR 17-22	ISSUED TO CITY FOR APPROVAL

D. B. GRAY ENGINEERING INC.
 Stormwater Management - Grading & Drainage - Storm & Sanitary Sewers - Watermain
 700 Long Point Circle 613-425-8044
 Ottawa, Ontario d.gray@dbgrayengineering.com

Project: **MUNICIPAL SANITARY SEWER EXTENSION CROSSING WOODROFFE AVE WEST FROM STONEWAY DR NORTH ON WOODROFFE AVE & WEST ON DEERFOX DR OTTAWA, ONTARIO**

Drawing Title: **SANITARY DRAINAGE PLAN**

	Drawn: D.B.G.
	Hor. Scale: 1:500
	Vert. Scale:
	Date: MAR 17-22
	Job No.: 20055
	Drawing No.: C-9 of 9

NOT VALID UNLESS SIGNED & DATED