

PLAN


5

3

0137

T 4

3 - 0145

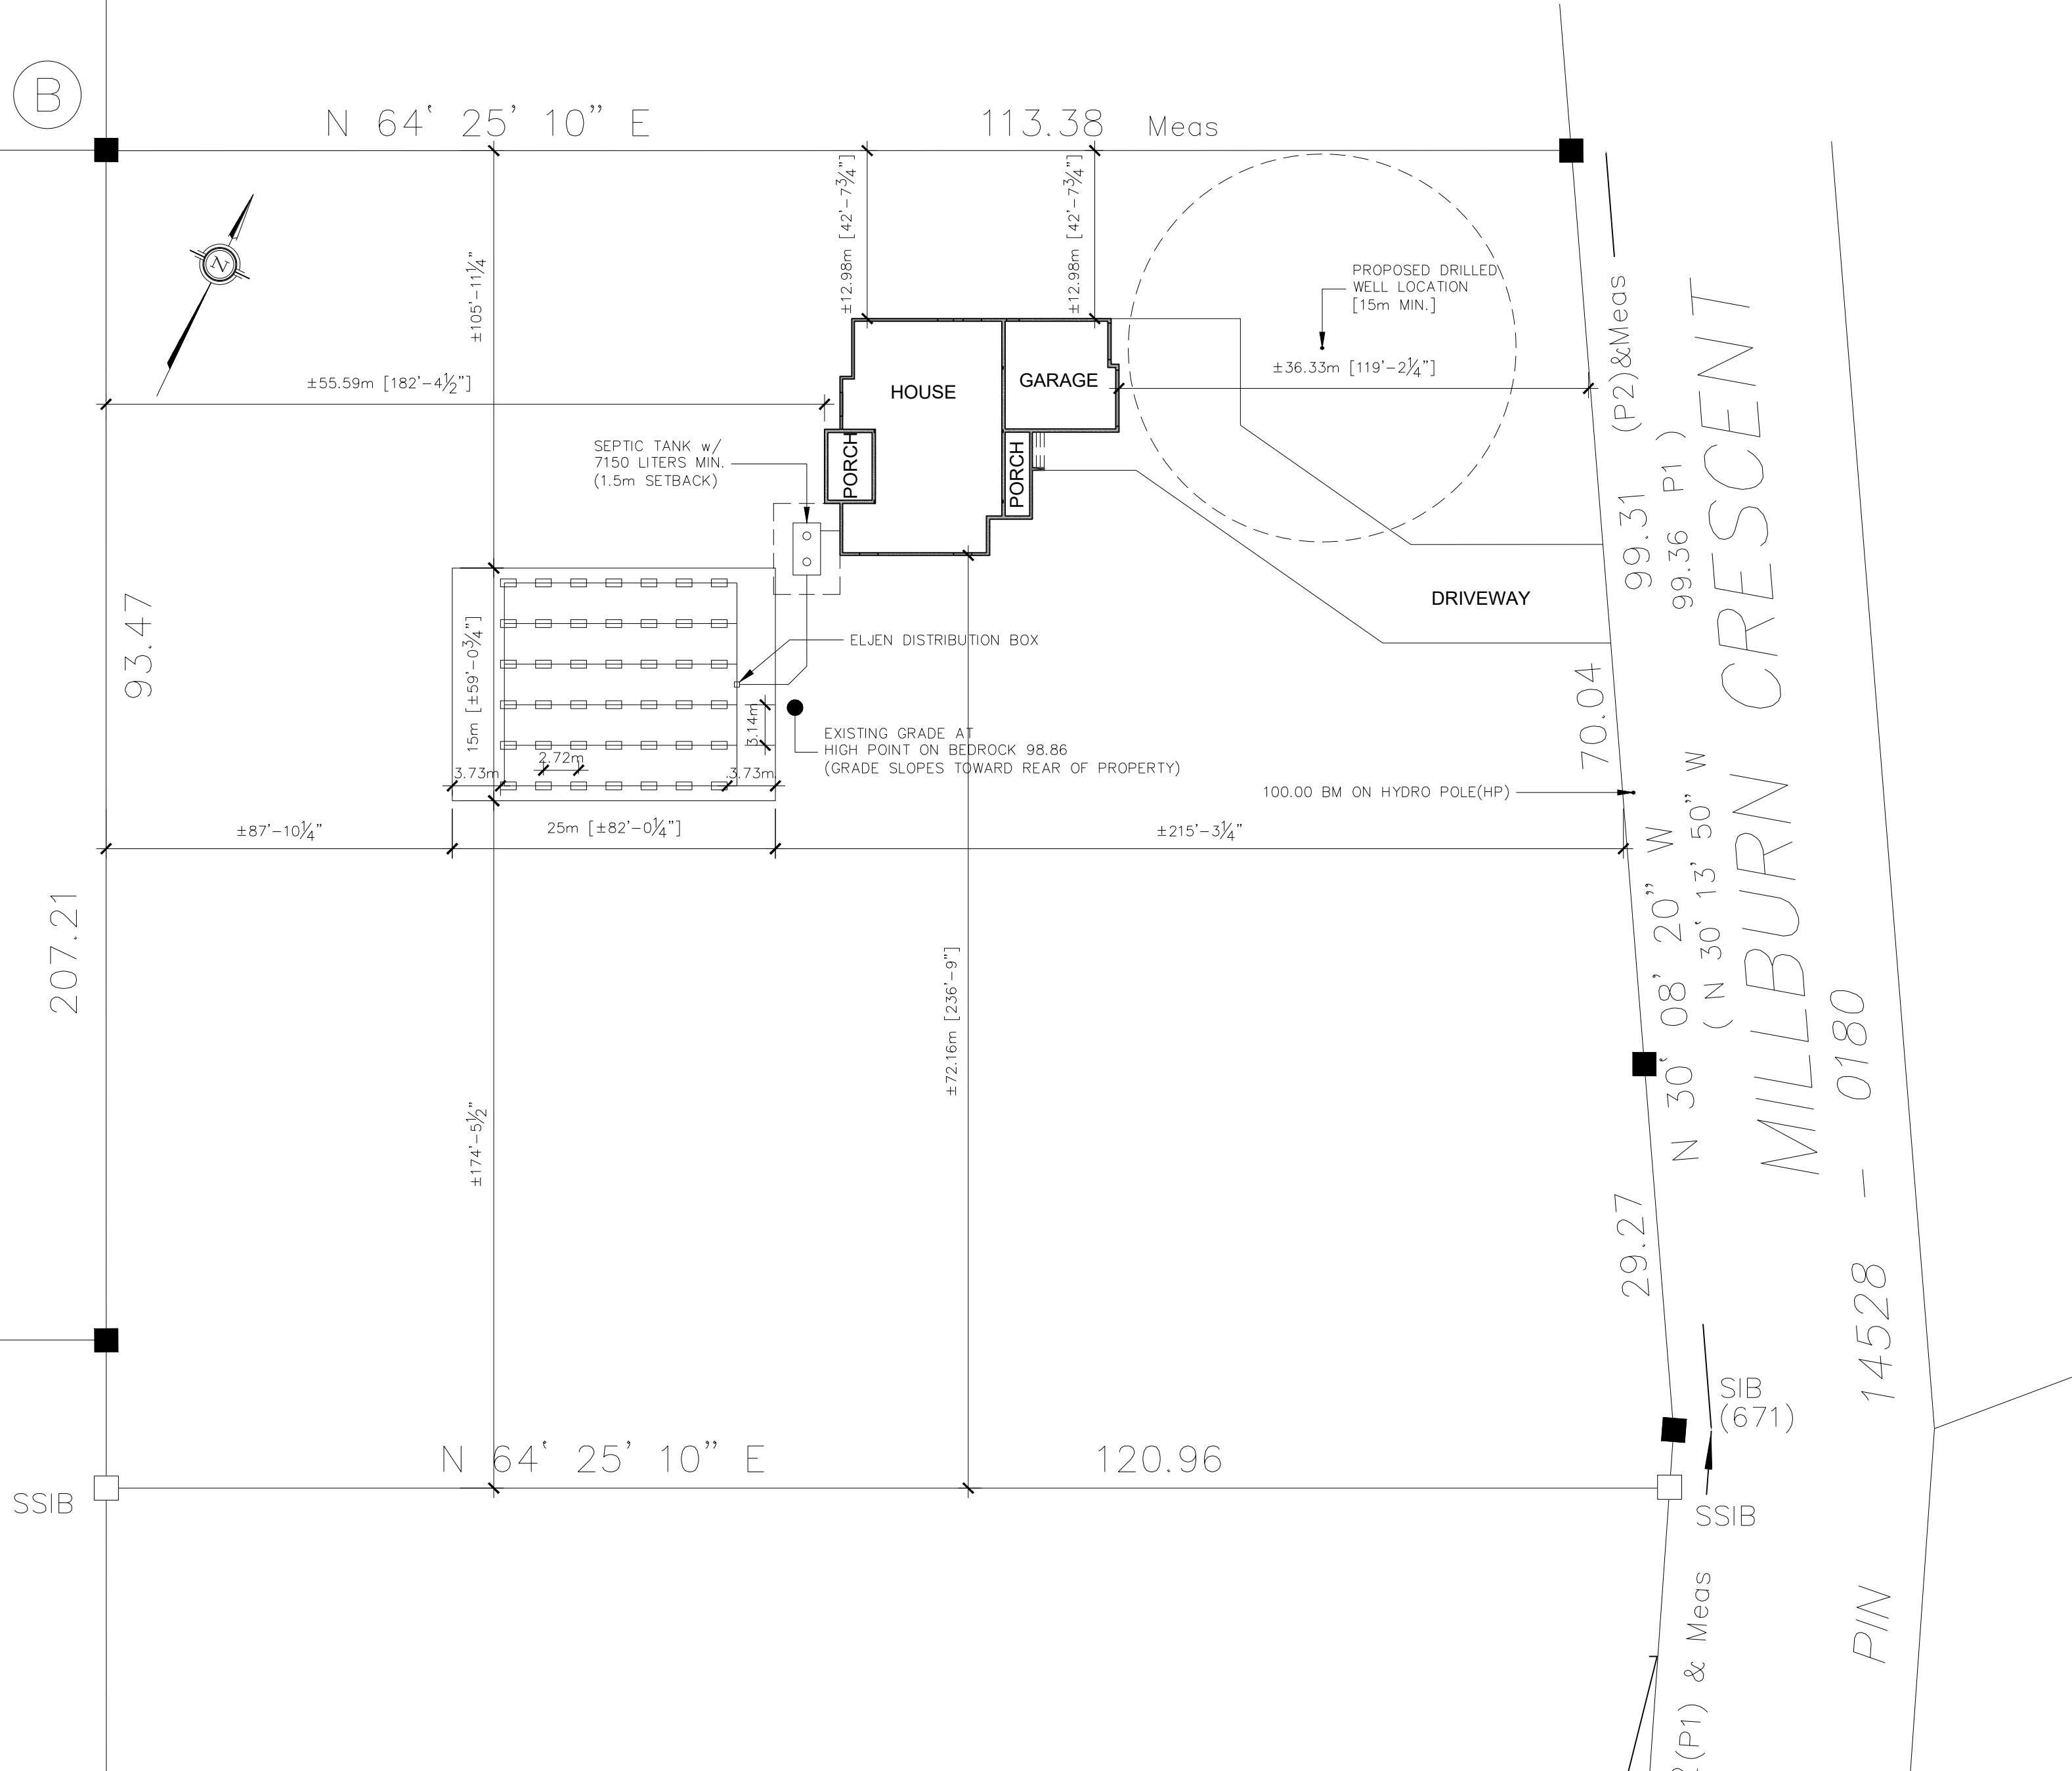

ALL CONTRACTORS SHALL PERFORM THEIR WORK WHETHER DESCRIBED OR NOT, ACCORDING TO THE APPLICABLE BUILDING CODE REQUIREMENTS AND MUNICIPAL REGULATIONS.

THE GENERAL CONTRACTOR SHALL CHECK AND VERIFY ALL DIMENSIONS AND REPORT ERRORS AND OMISSIONS TO THE DESIGN CONSULTANT.

NO DIMENSION SHOULD BE SCALED ON DRAWINGS.

THE GENERAL CONTRACTOR OR SUB-CONTRACTORS WILL BE HELD RESPONSIBLE FOR ALL WORK DONE ON THE CONSTRUCTION SITE. IN NO EVENT WILL THE DESIGN CONSULTANT BE HELD RESPONSIBLE BEFORE, DURING AND AFTER THE PROJECT.

PROPOSED - SITE PLAN + SEPTIC DESIGN LOCATION

SCALE: 1/4" = 1'-0"

SCALE:
1/32" = 1'-0"

ABSOLUTE DRAFTING + DESIGN INC.
PERS. BCIN #44555
FIRM. BCIN #45254

DATE: 2022.04.11.
ISSUED FOR PERMIT
PROJECT: 21A148-REV02

I, ABSOLUTE DRAFTING + DESIGN INC., HAVE REVIEWED THE FOLLOWING DOCUMENTS AND TAKE RESPONSIBILITY FOR THE DESIGN ACTIVITIES.

DESSIN/DRAWING
SEPTIC DESIGN + SITE PLAN

PROJET/PROJECT
MILLBURN'S SINGLE FAMILY DWELLING

CLIENT
FRANCESCA SAPOZHNIKOV & PHILLIP PAQUETTE
1205 MILLBURN CRESCENT,
CUMBERLAND, ON. K4C 1C9