



5m
0m

25m

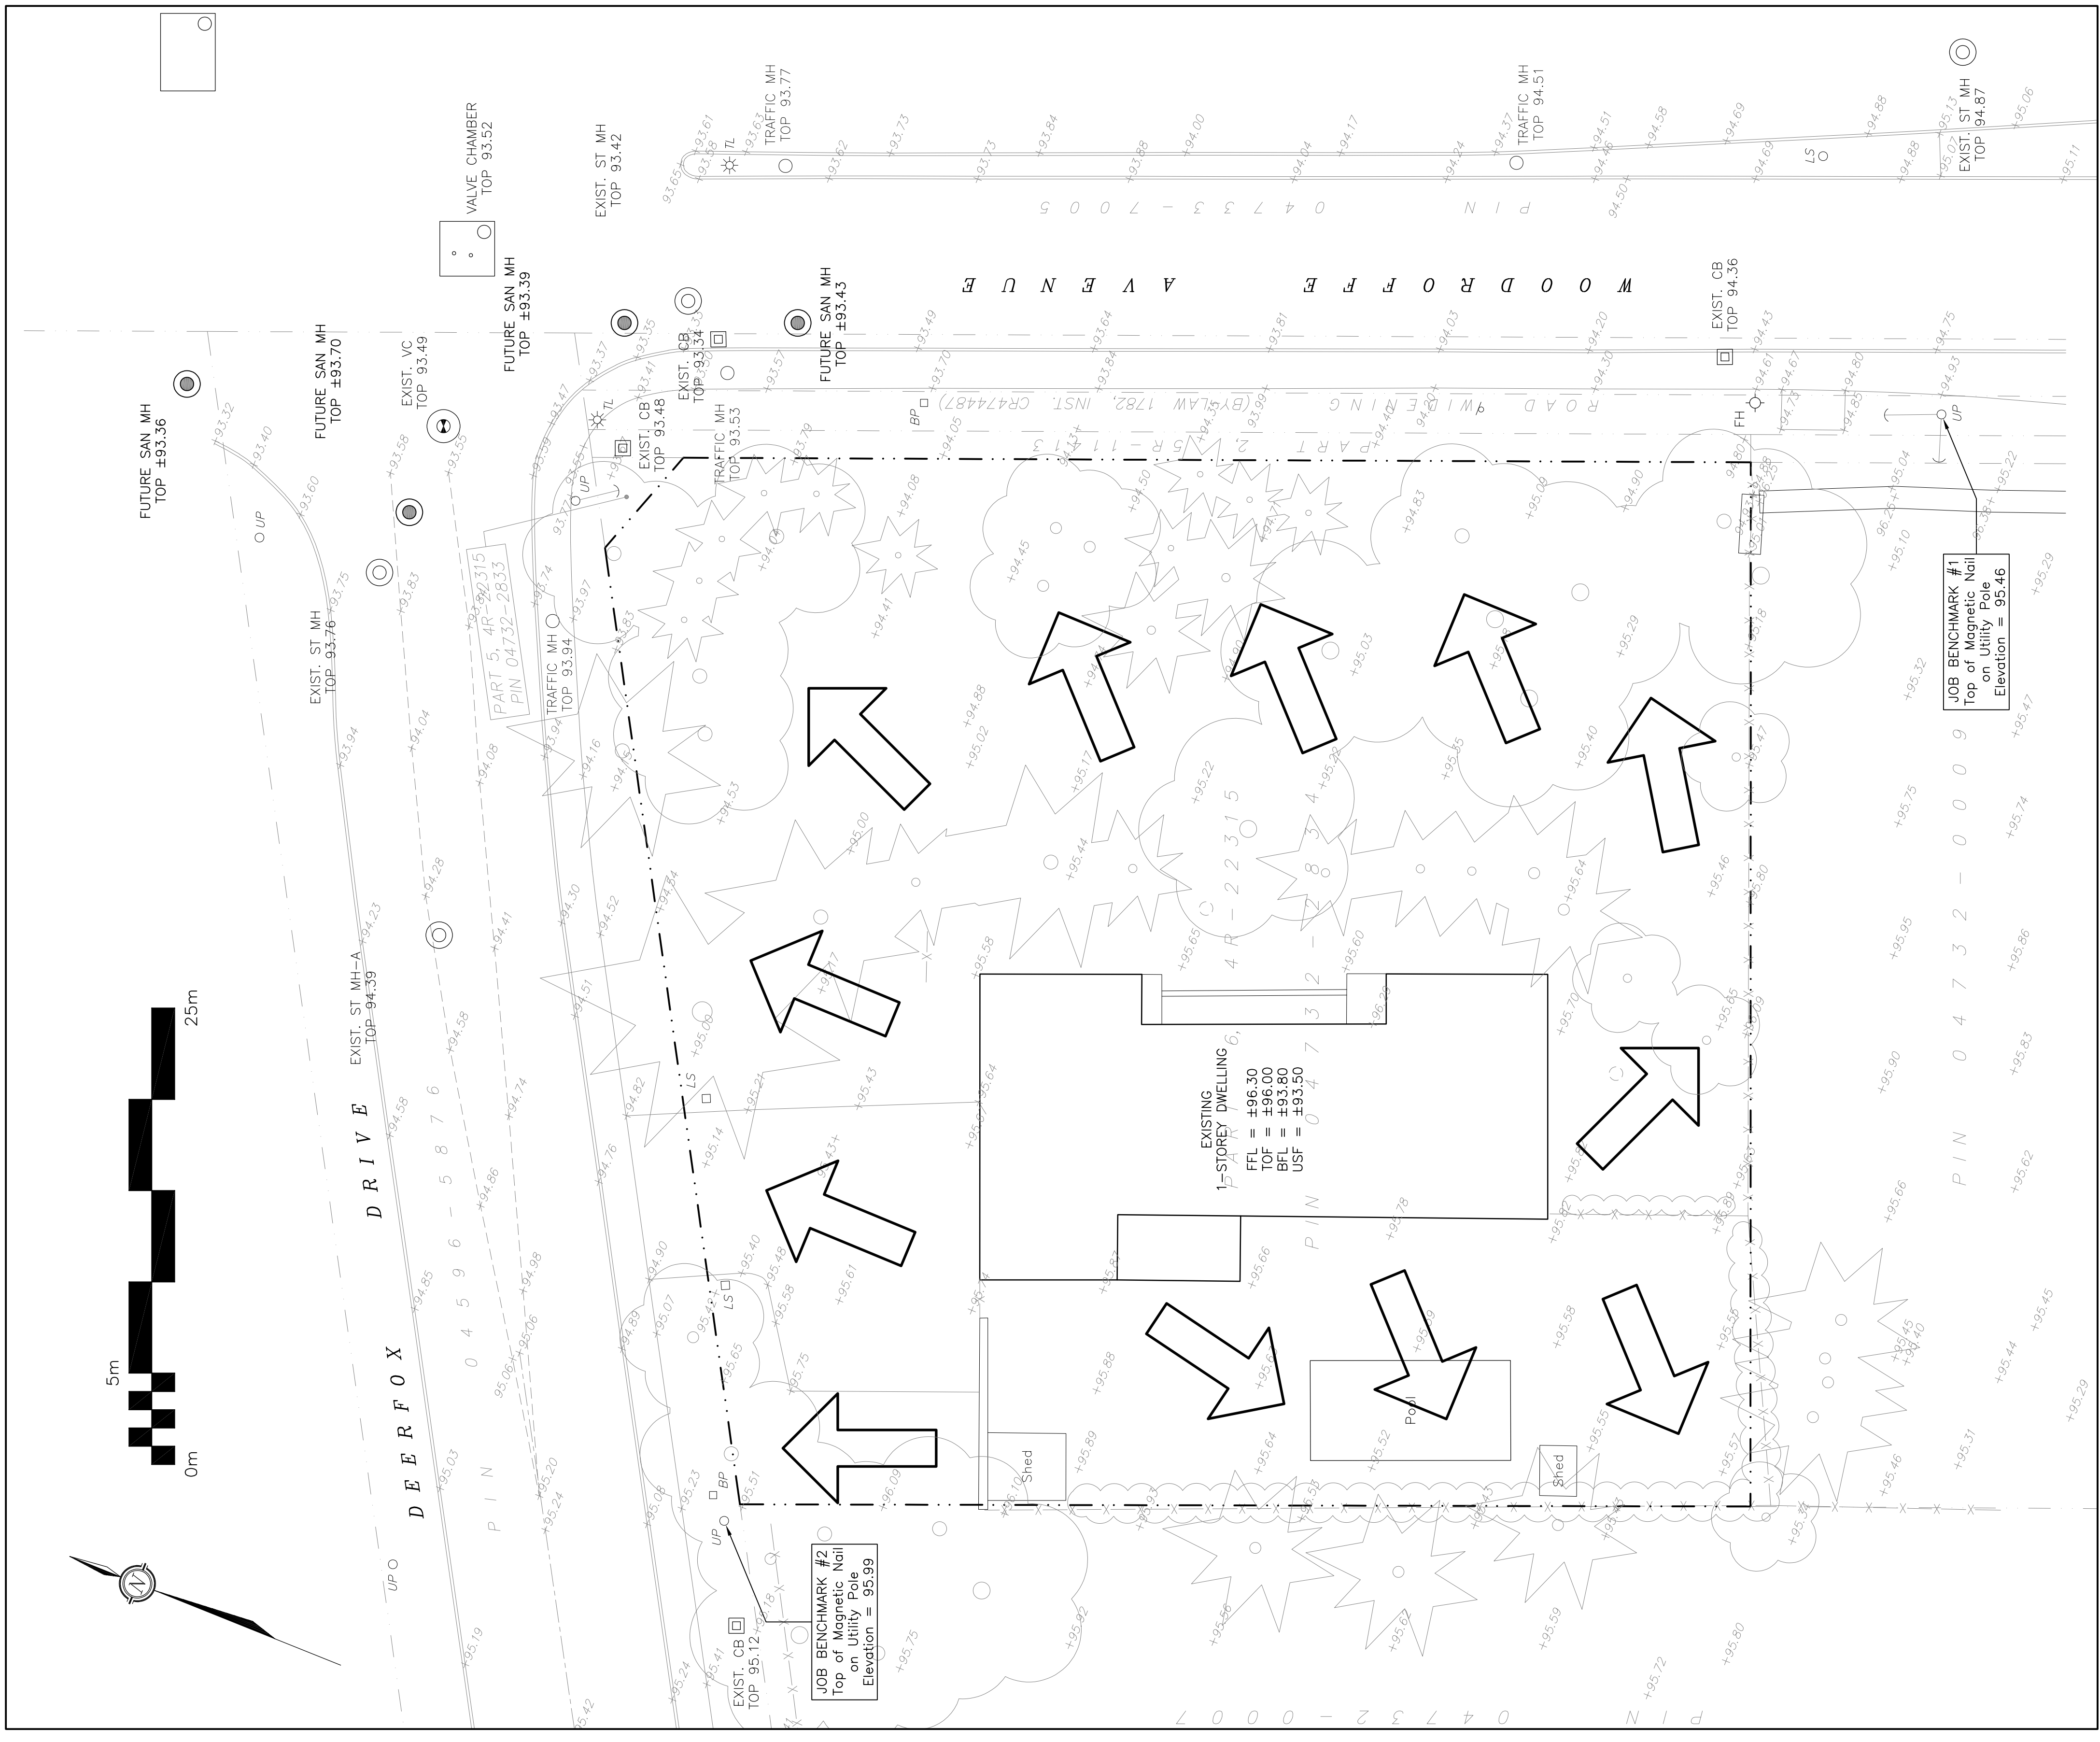

KEY PLAN

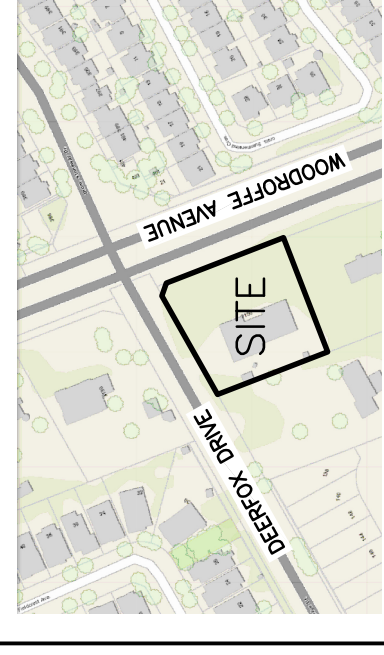

No.	DATE	REVISION
2	JUN 2-22	ISSUED FOR APPROVAL
1	MAY 16-22	ISSUED FOR COORDINATION

D. B. GRAY ENGINEERING INC.
Professional Engineering Firm
700 Long Point Circle
Ottawa, Ontario
d.gray@dbgrayengineering.com
613-425-8044

Project
EXHALO SPA
3150 WOODROFFE AVENUE
OTTAWA, ONTARIO

Drawing Title
**PRE-DEVELOPMENT
DRAINAGE PLAN**

Engineer's Seal
D. B. GRAY
PROFESSIONAL ENGINEER
P.E. No. 17016502
JUN 2-22
D.B.G.
Drawn
H. Scale
V. Scale
Date
Job No.
22017
Drawing No.
C-6
of 7
NOT VALID UNLESS
SIGNED & DATED