



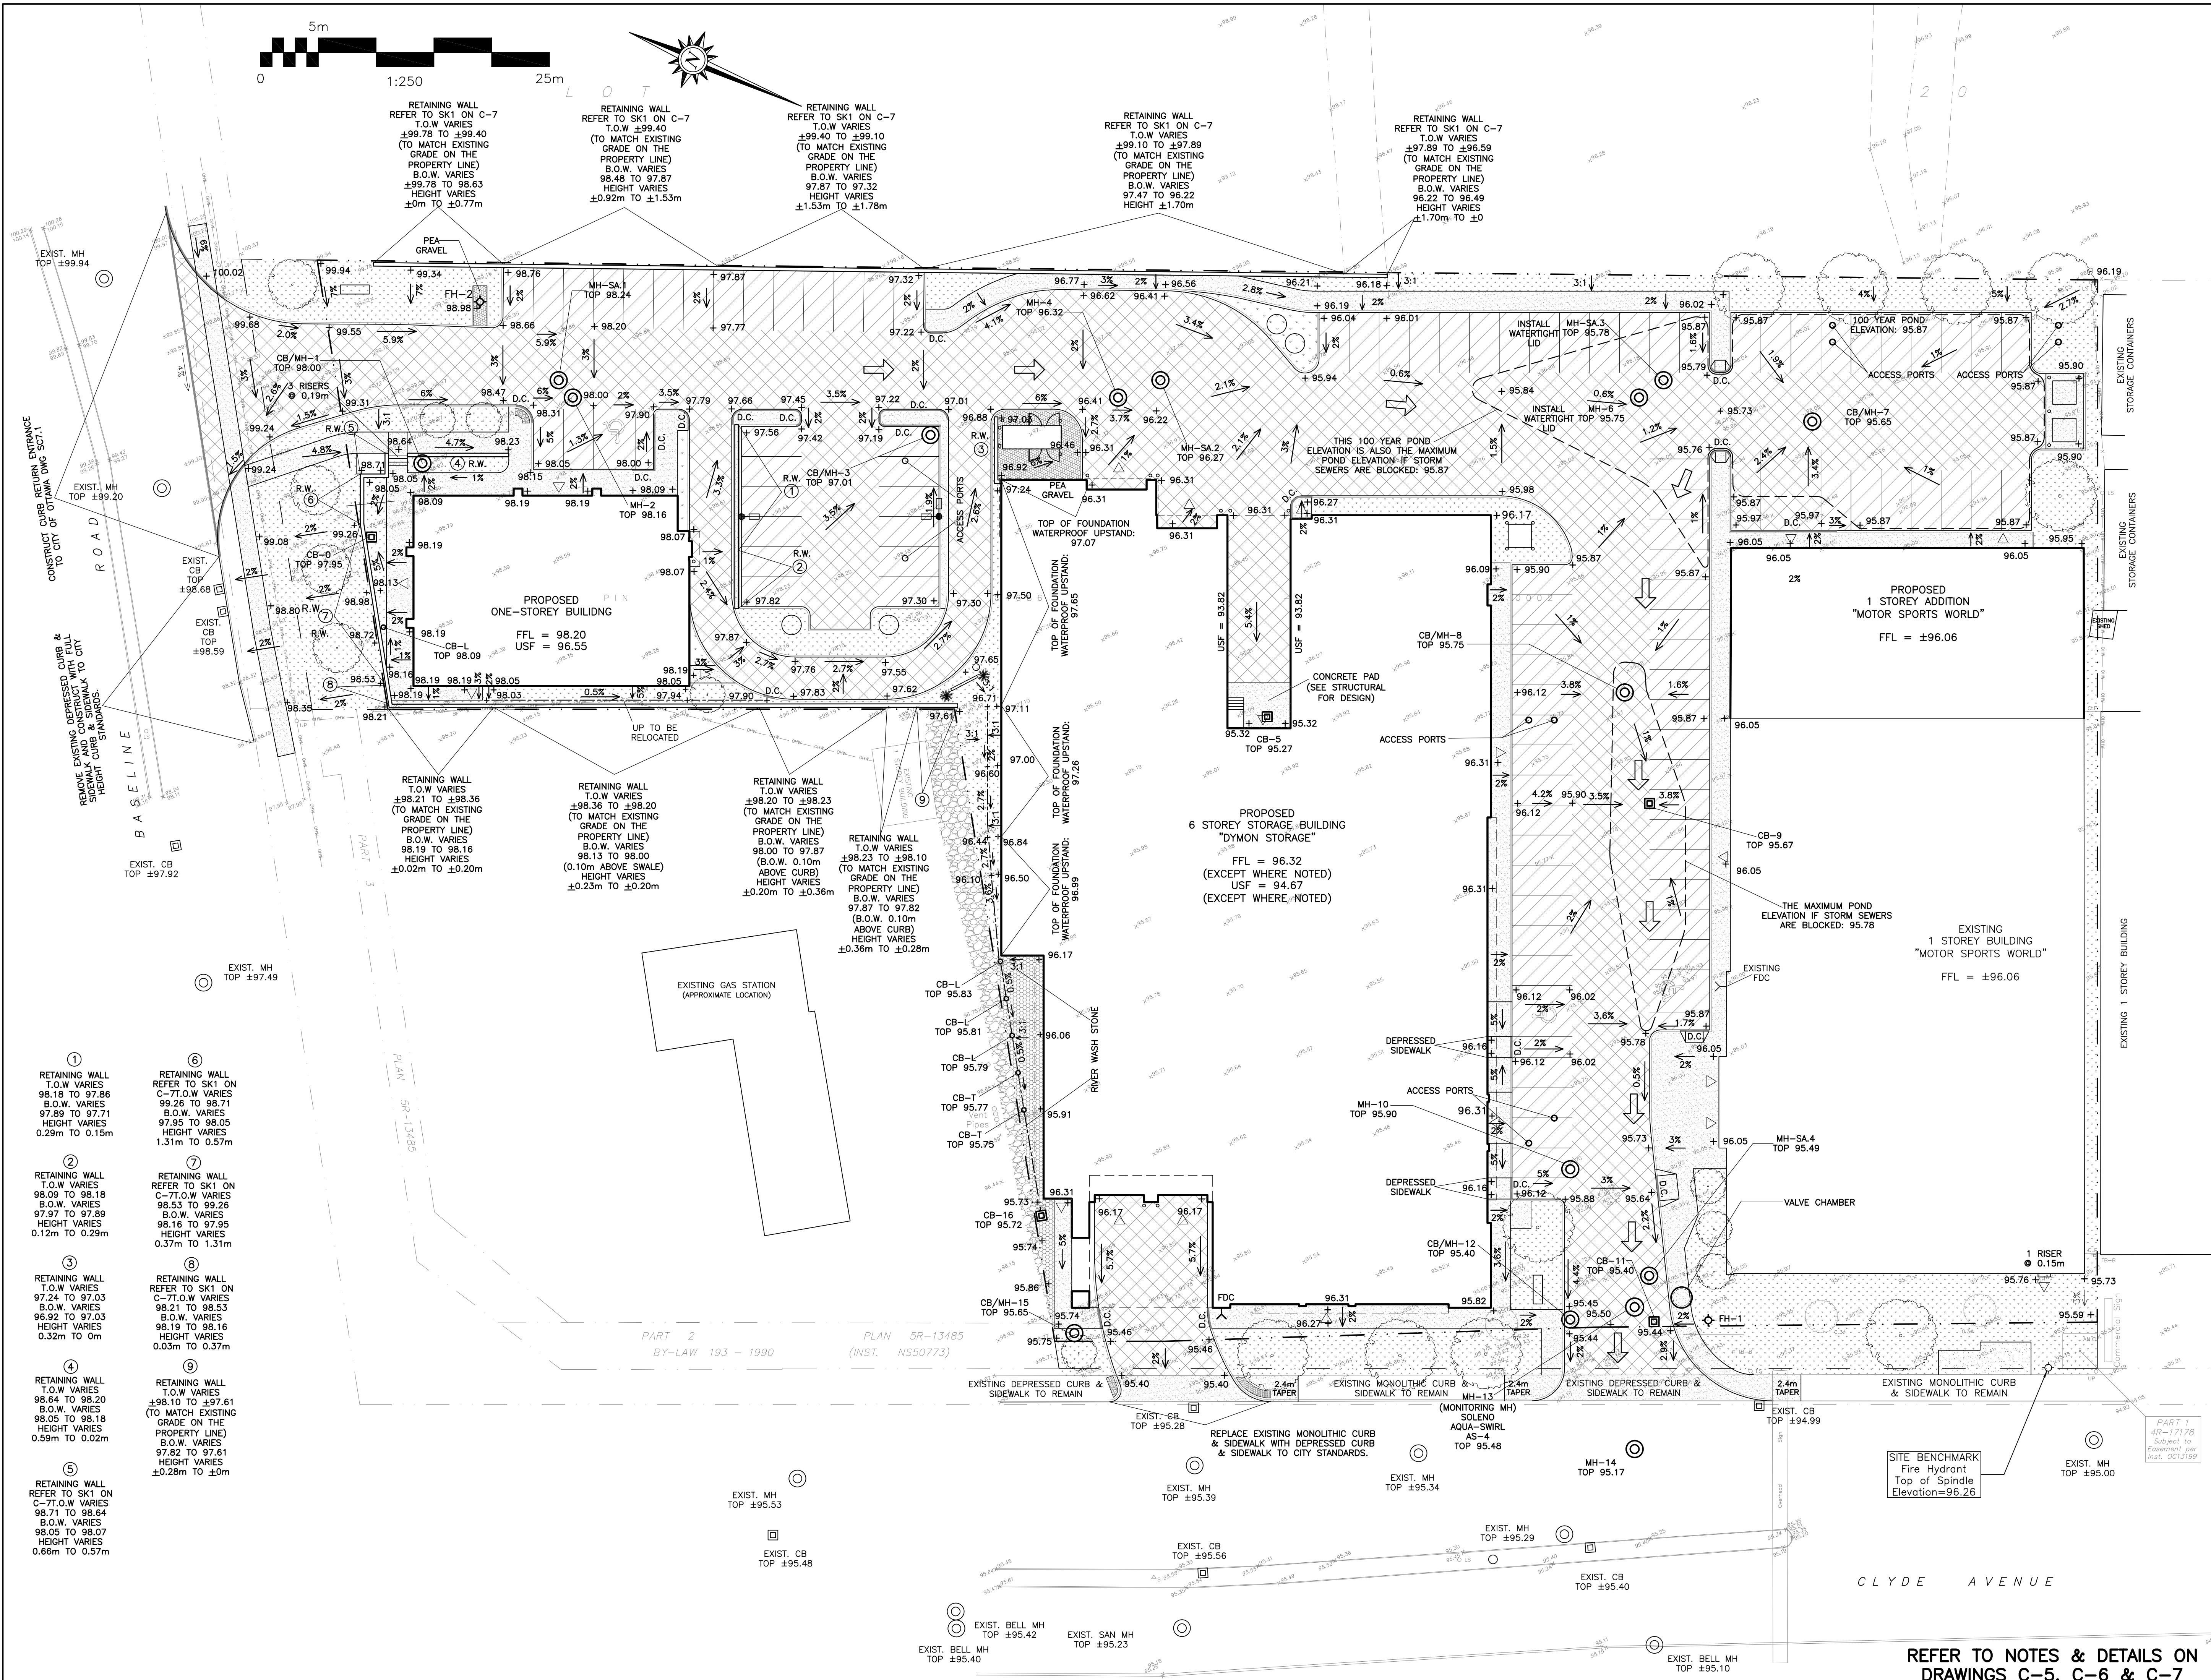

- DRAWING LEGEND**
- CB CATCH BASIN
 - MH MANHOLE
 - CB/MH CATCH BASIN/MANHOLE
 - SPL SPRINGLINE OF PIPE
 - INV INVERT OF PIPE
 - SB SUBDRAIN IN CB
 - SB SUBDRAIN IN CB/MH
 - SAN SANITARY SEWER
 - ST STORM SEWER
 - WS/WM WATER SERVICE/WATERMAIN
 - CS CURB STOP & STANDPOST
 - VB VALVE & VALVE BOX
 - FH FIRE HYDRANT
 - FDC FIRE DEPARTMENT CONNECTION
 - RD ROOF DRAIN
 - WM WATER METER
 - WM REMOTE WATER METER READOUT
 - GE EXISTING GRADE ELEVATION
 - PG PROPOSED GRADE ELEVATION
 - SG EXISTING SLOPE OF GRADE
 - PG PROPOSED SLOPE OF GRADE
 - EF EMERGENCY OVERLAND FLOW
 - CL CENTERLINE OF SWALE
 - PL PROPERTY LINE
 - SFB SILT FENCE BARRIER
 - DC 150mm CURB/DEPRESSED CURB
 - MD MEDIUM-DUTY PAVEMENT
 - HD HEAVY-DUTY PAVEMENT
 - CON CONCRETE
 - LAN LANDSCAPE
 - FFL FIRST FLOOR ELEVATION
 - USF UNDERSIDE OF FOOTING

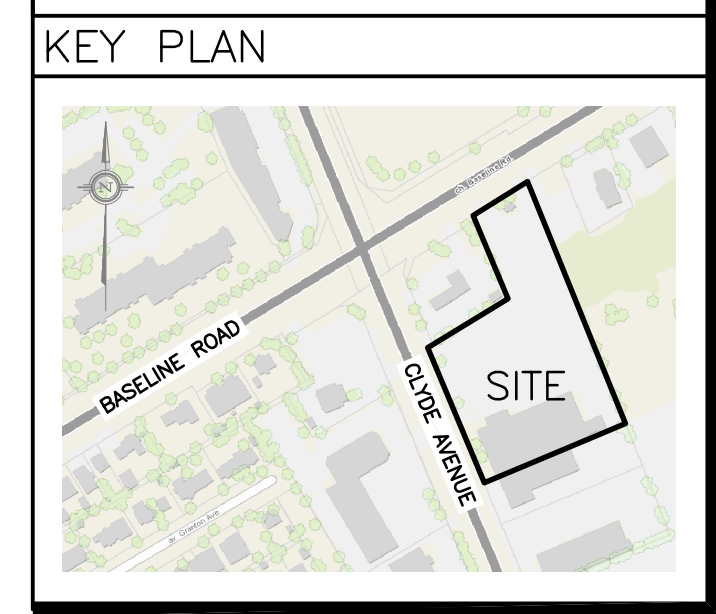


No.	DATE	REVISION
7	APR 28-22	RE-ISSUED FOR APPROVAL
6	JAN 5-22	ISSUED FOR TENDER
5	DEC 14-21	RE-ISSUED FOR APPROVAL
4	DEC 9-21	ISSUED FOR PERMIT
3	NOV 23-21	ISSUED FOR COORDINATION
2	JAN 8-20	ISSUED FOR APPROVAL
1	DEC 12-19	ISSUED FOR COORDINATION

D. B. GRAY ENGINEERING INC.
Stormwater Management - Grading & Drainage - Storm & Sanitary Sewers - Watermain
700 Long Point Circle
Ottawa, Ontario
613-425-8044
d.gray@dbgrayengineering.com

Project
PROPOSED 6-STORY STORAGE FACILITY & 1-STORY BUILDING
1375 CLYDE AVENUE
OTTAWA, ONTARIO

Drawing Title
GRADING PLAN

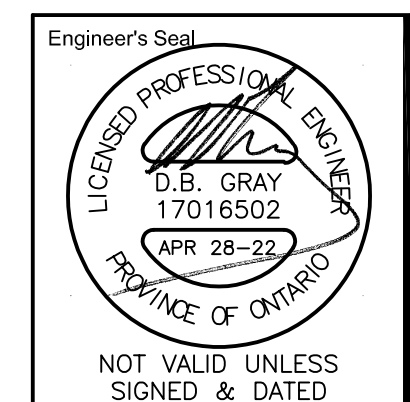

Engineer's Seal
Drawn D.B.G.
Hor. Scale 1:250
Vert. Scale
Date SEP 17-19
Job No. 19058
Drawing No.
C-3
of 8

REFER TO NOTES & DETAILS ON
DRAWINGS C-5, C-6 & C-7