


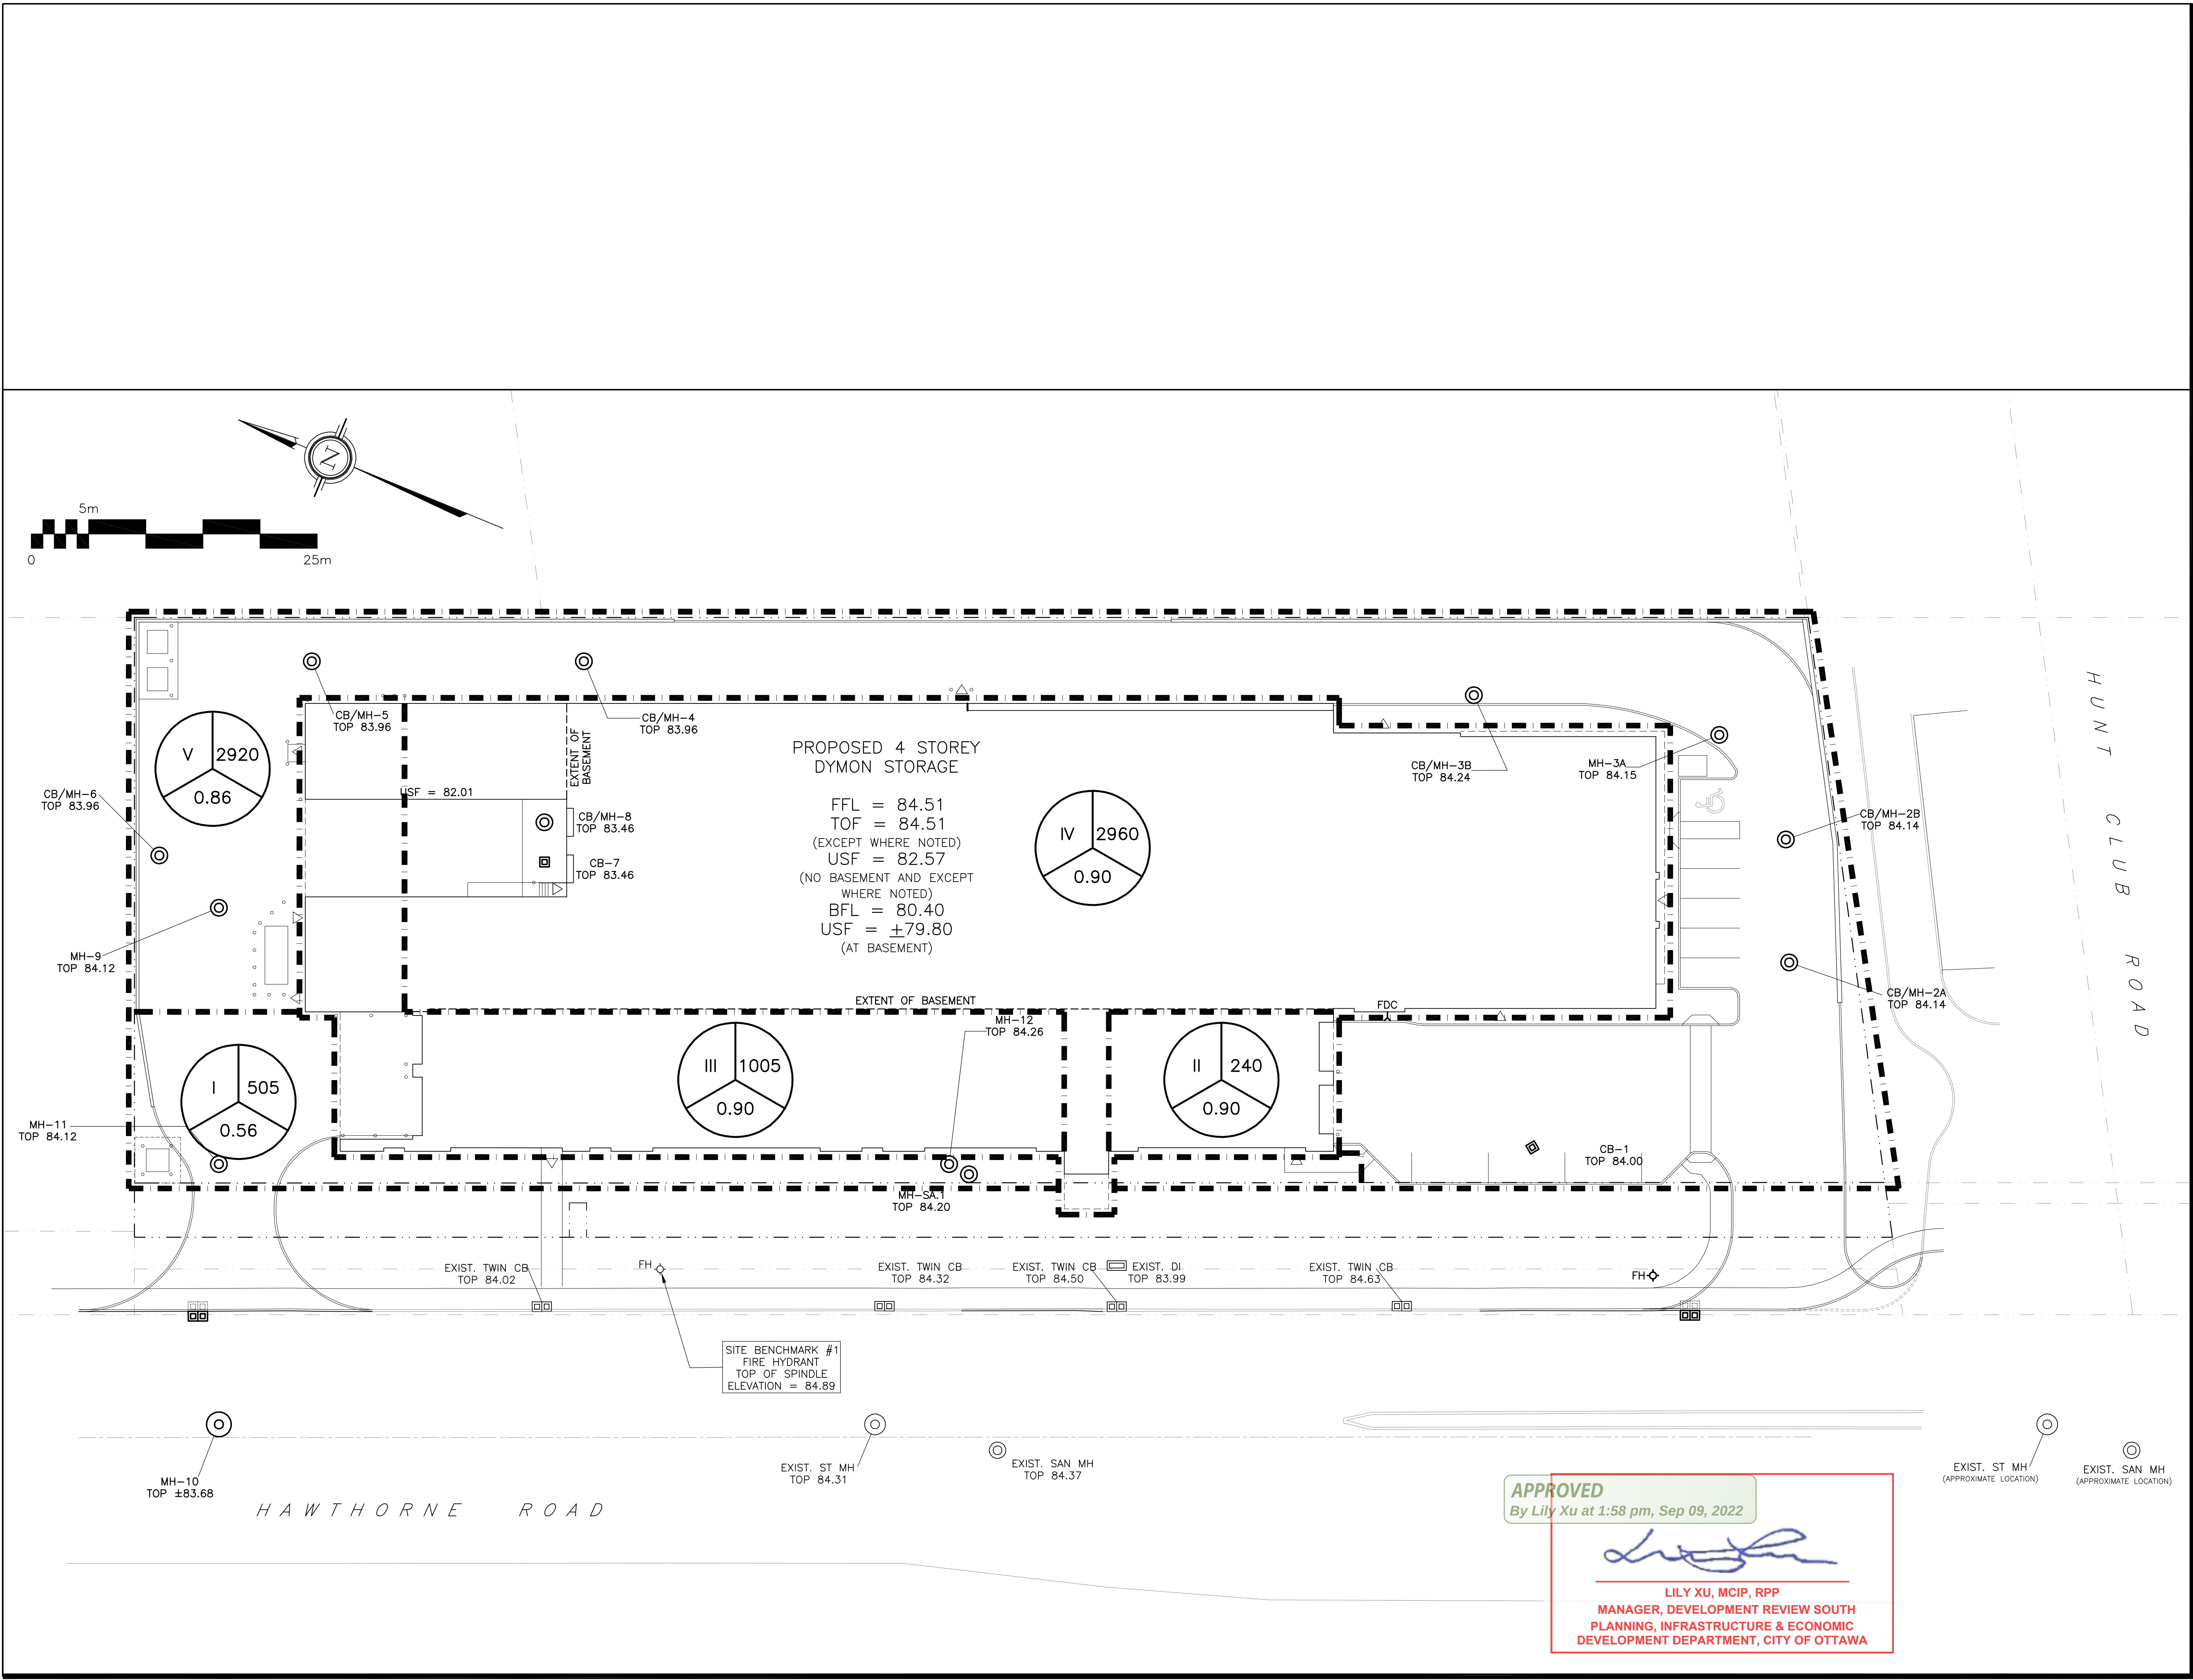

LEGEND

DRAINAGE AREA

AREA (sq.m)

112340.56

5 YEAR RUNOFF COEFFICIENT

KEY PLAN

No.	DATE	REVISION
6	AUG 11-22	ISSUED FOR CONSTRUCTION
5	MAY 31-22	RE-ISSUED FOR APPROVAL
4	NOV 1-21	ISSUED FOR TENDER
3	OCT 8-21	ISSUED FOR BUILDING PERMIT
2	DEC 11-20	ISSUED FOR APPROVAL
1	DEC 9-20	ISSUED FOR COORDINATION

D. B. GRAY ENGINEERING INC.
Stormwater Management • Grading & Drainage • Storm & Sanitary Sewers • Watermain

700 Long Point Circle
Ottawa, Ontario

613-425-8044
d.gray@dbgrayengineering.com

Project

PROPOSED 4-STOREY DYMON STORAGE BUILDING
3455 HAWTHORNE ROAD
OTTAWA, ONTARIO

Drawing Title

DRAINAGE PLAN

Engineer's Seal

Drawn: D.B.G.
Hor. Scale: 1:250
Vert. Scale:
Date: NOV 17-20
Job No.: 19107

NOT VALID UNLESS SIGNED & DATED

Drawing No.
C-8 of 8

APPROVED
By Lily Xu at 1:58 pm, Sep 09, 2022

LILY XU, MCIP, RPP
MANAGER, DEVELOPMENT REVIEW SOUTH
PLANNING, INFRASTRUCTURE & ECONOMIC
DEVELOPMENT DEPARTMENT, CITY OF OTTAWA