


ALL DRAWINGS REMAIN THE PROPERTY OF THE LANDSCAPE ARCHITECT AND SHALL NOT BE REPRODUCED OR REUSED WITHOUT THE LANDSCAPE ARCHITECTS WRITTEN PERMISSION.
THIS DRAWING SHALL NOT BE USED FOR CONSTRUCTION OR TENDER PURPOSES UNLESS SIGNED AND DATED BY RONALD H. KOUDYS, O.A.L.A. C.S.L.A. LANDSCAPE ARCHITECT, LONDON, ONTARIO (519) 687-3322.

Ronald H. Koudys, O.A.L.A. C.S.L.A. DATE

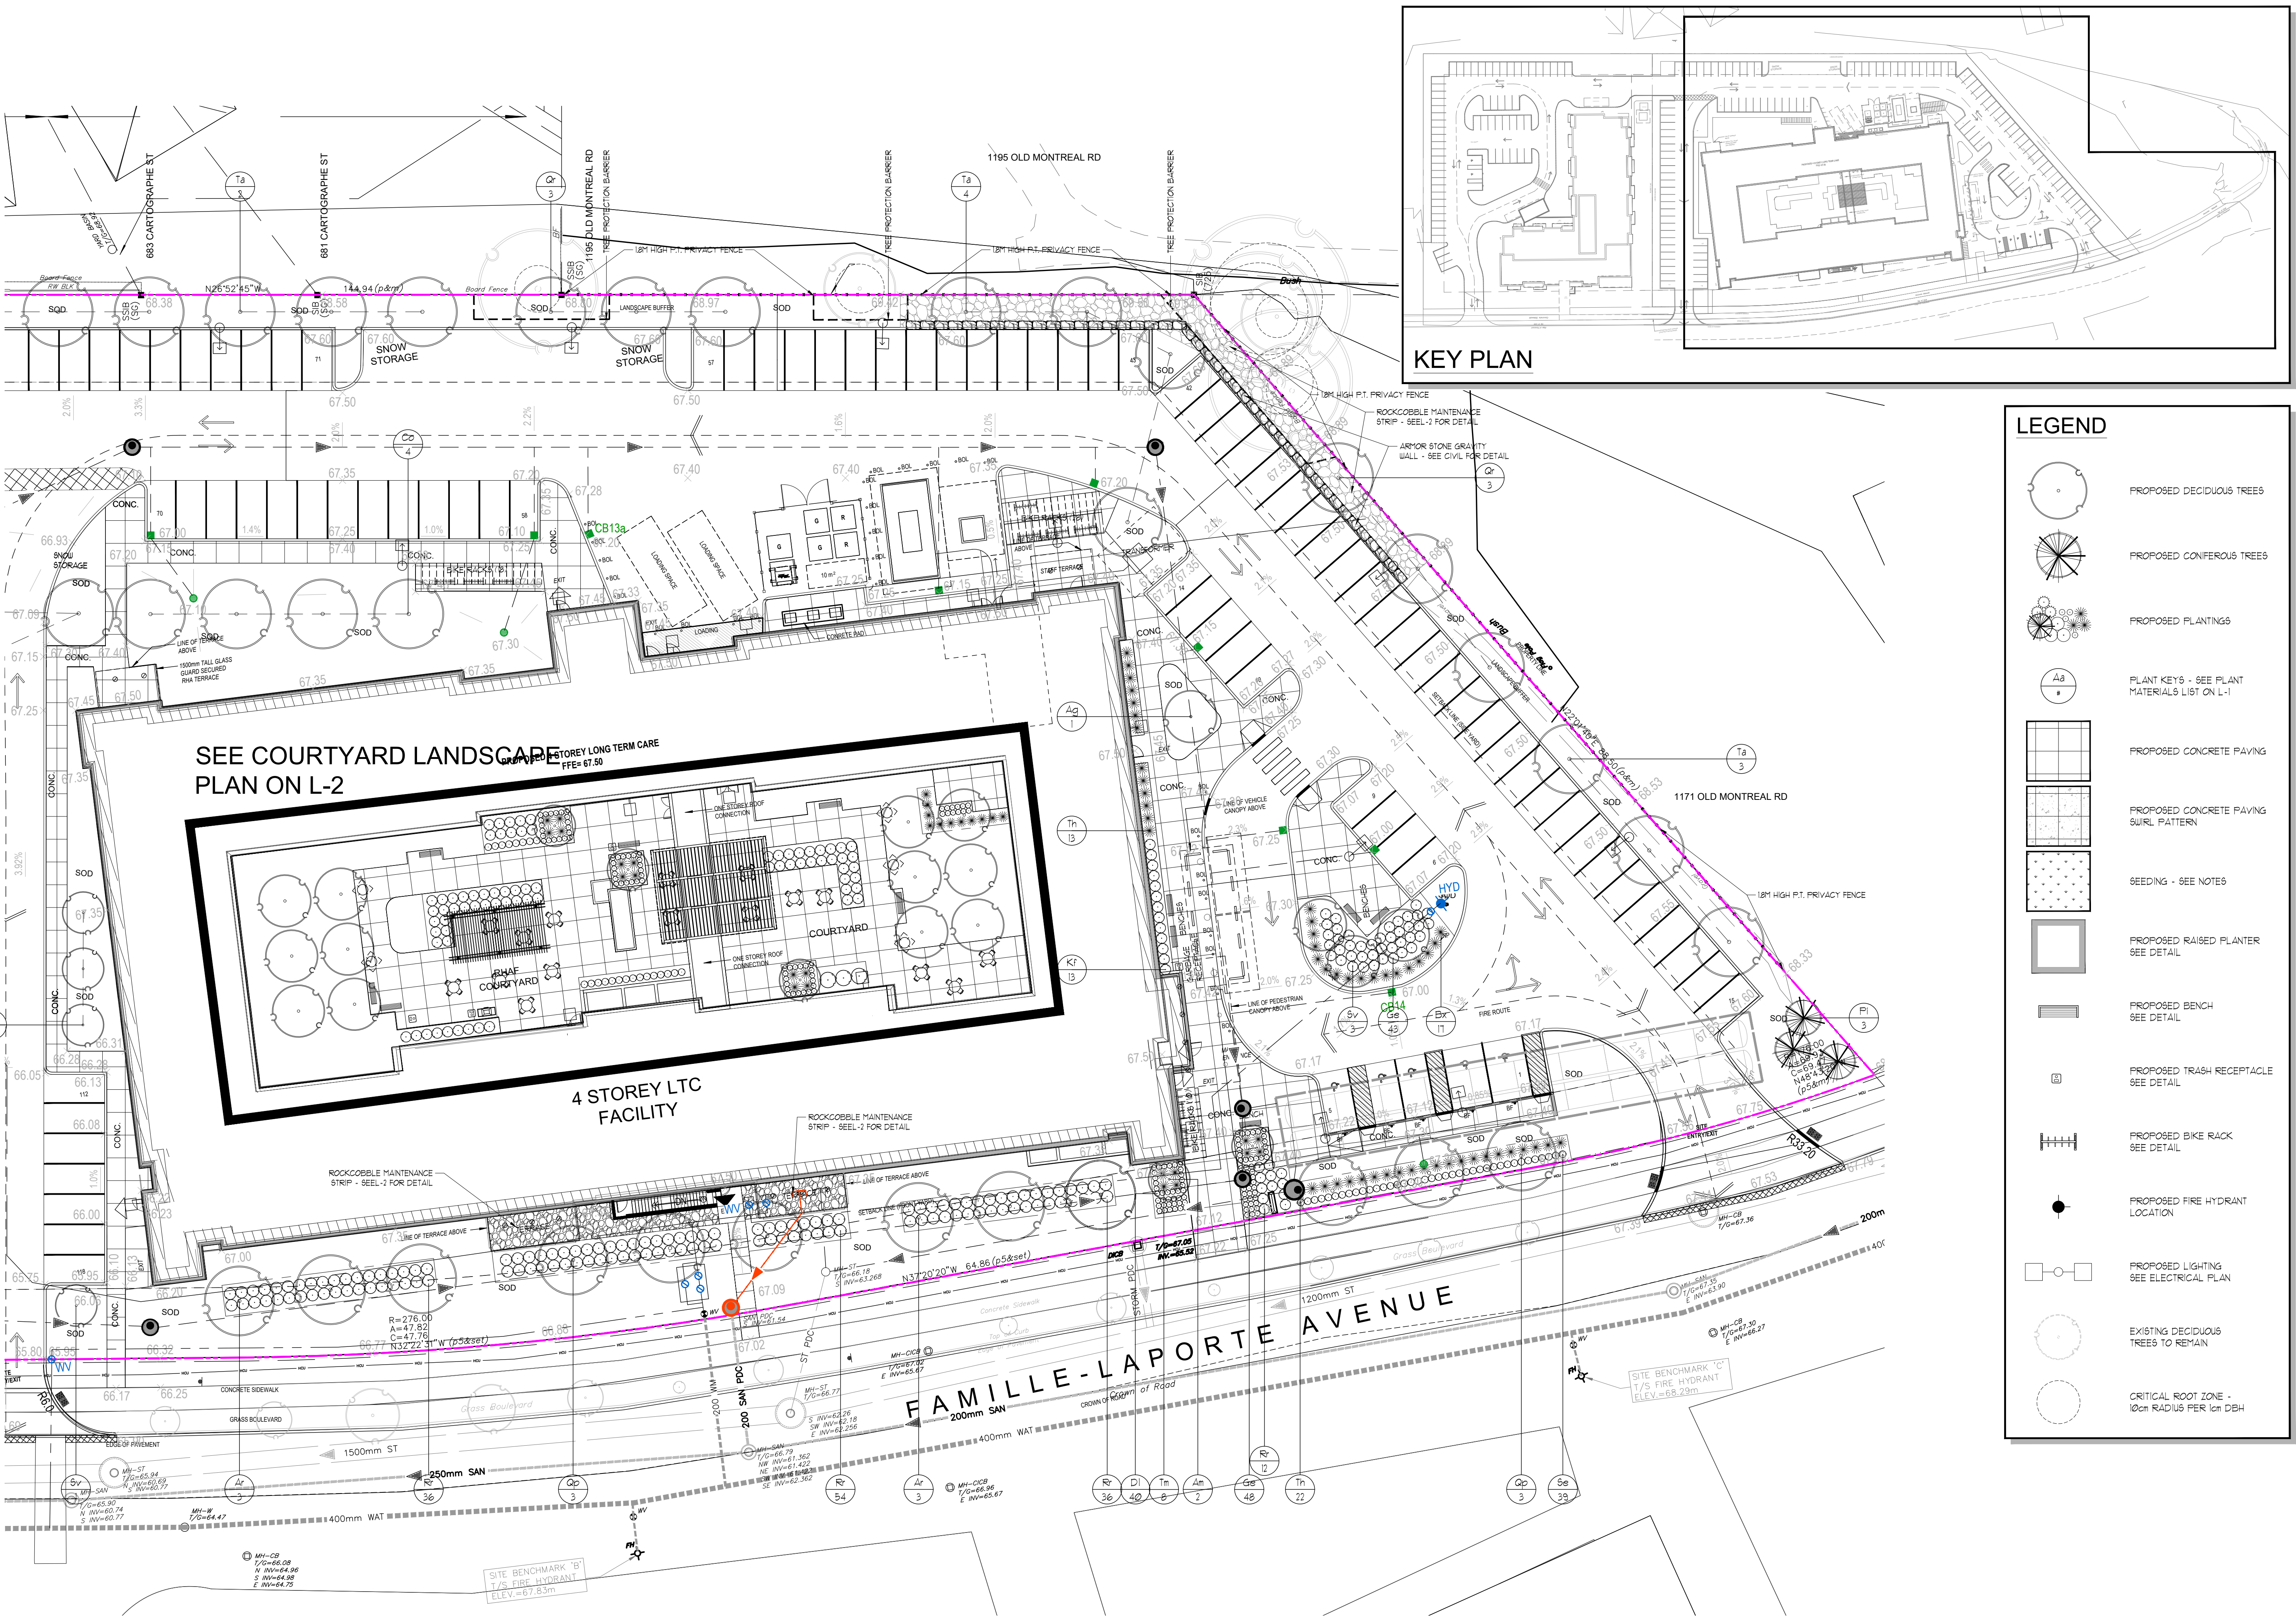

KEY PLAN

LEGEND

- PROPOSED DECIDUOUS TREES
- PROPOSED CONIFEROUS TREES
- PROPOSED PLANTINGS
- PLANT KEYS - SEE PLANT MATERIALS LIST ON L-1
- PROPOSED CONCRETE PAVING
- PROPOSED CONCRETE PAVING SWIRL PATTERN
- SEEDING - SEE NOTES
- PROPOSED RAISED PLANTER SEE DETAIL
- PROPOSED BENCH SEE DETAIL
- PROPOSED TRASH RECEPTACLE SEE DETAIL
- PROPOSED BIKE RACK SEE DETAIL
- PROPOSED FIRE HYDRANT LOCATION
- PROPOSED LIGHTING SEE ELECTRICAL PLAN
- EXISTING DECIDUOUS TREES TO REMAIN
- CRITICAL ROOT ZONE - 10cm RADIUS PER 1cm DBH

#	date	revision	by
9	AUG 19 2022	ISSUED FOR SITE PLAN CONTROL APPLICATION	MCB
8	AUG 19 2022	ISSUED FOR ZONING BY-LAW AMENDMENT	MCB
7	JUL 29 2022	ISSUED FOR ZONING BY-LAW AMENDMENT	MCB
6	FEB 04 2022	ISSUED FOR ZONING BY-LAW AMENDMENT	MCB
5	DEC 02 2021	ISSUED FOR SPA & ZONING BY-LAW AMENDMENT	MCB
4	NOV 19 2021	ISSUED FOR 100% DD	MCB
3	NOV 19 2021	ISSUED FOR 25% SPA	MCB
2	OCT 22 2021	ISSUED FOR 50% DD	MCB
1	AUG 26 2021	ISSUED FOR 100% SD	MCB

All drawing and specifications are the property of the architect. The contractor shall verify all dimensions and information on site and report any discrepancy to architect before proceeding.

Arch Corp - Orleans

1161 OLD MONTREAL RD,
ORLEANS ON, K4A 3N6

**LANDSCAPE PLAN
2of2**

scale: AS NOTED
drawn by: MCB
reviewed by: MCB
job number: 21-164Ln
plot date: 22-08-19
drawing number: