


ICD SUMMARY TABLE

Control Location	Max Flow (L/sec)	Max Head (m)	Type	Model
CB02	2.3	1.08	IPEX TEMPEST	LMF 50

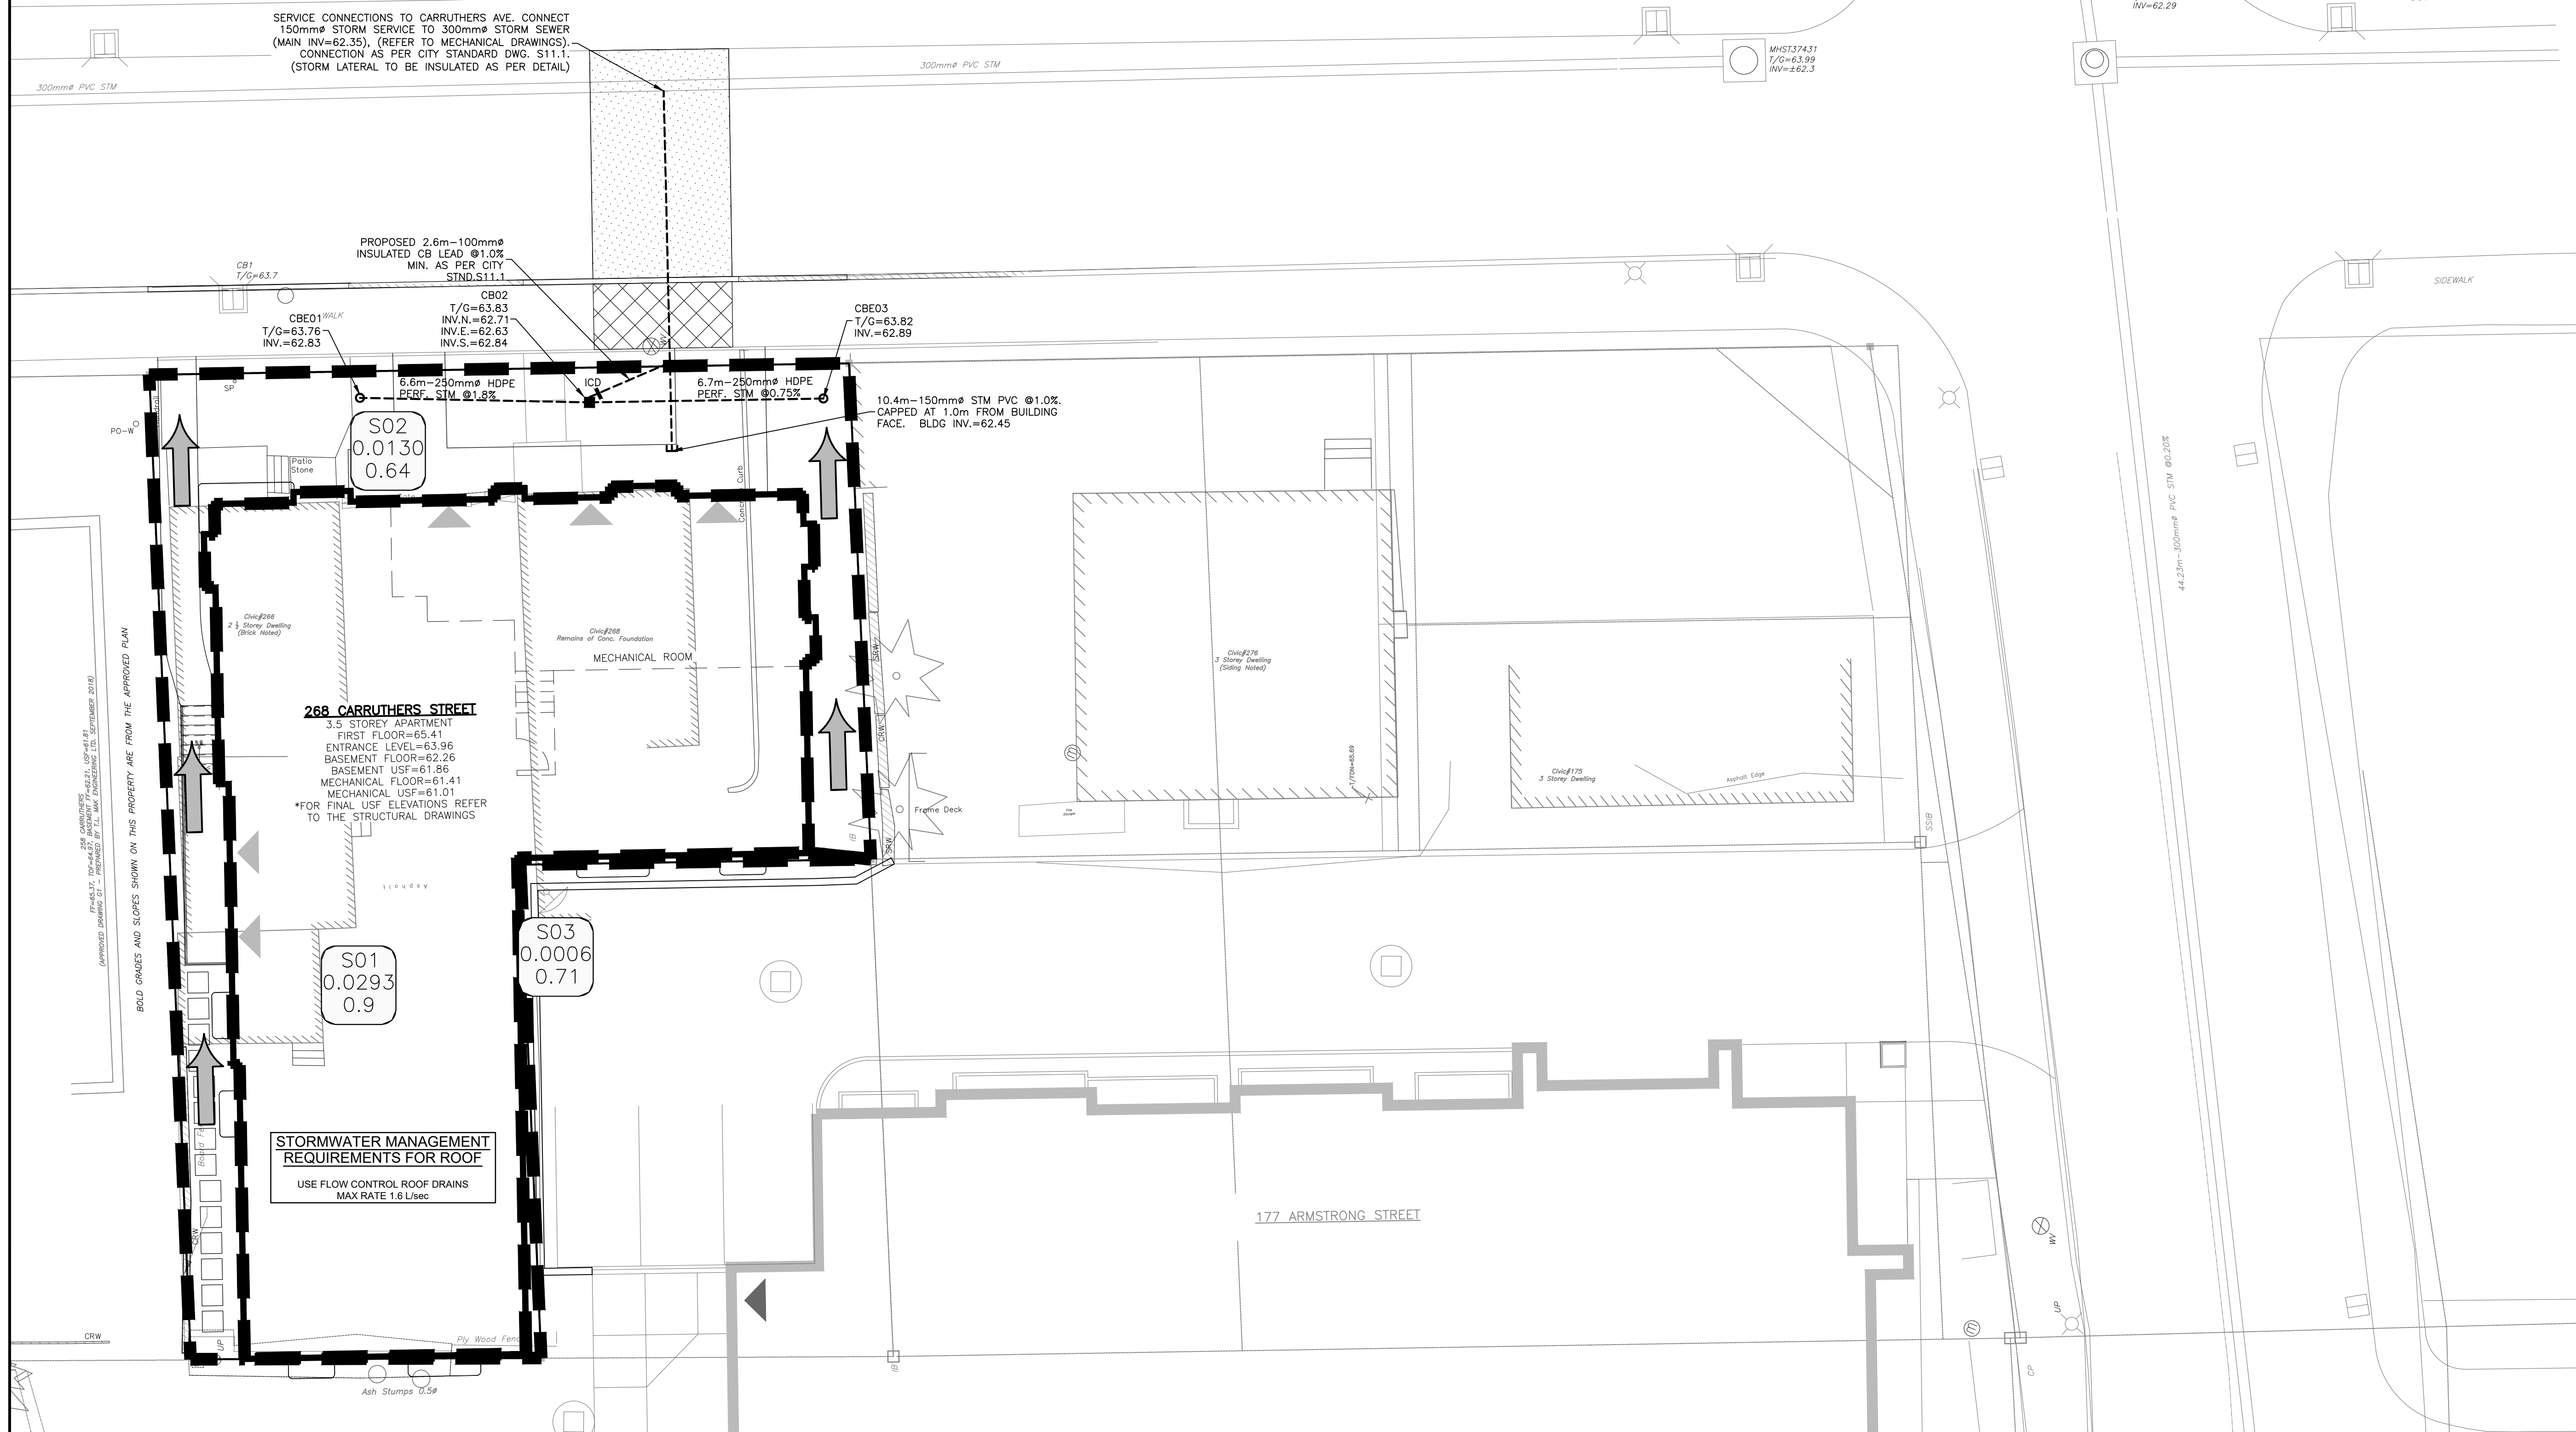

CAUTION
 THE POSITION OF ALL POLE LINES, CONDUITS, WATERMANS, SEWERS AND OTHER UNDERGROUND AND OVERGROUND UTILITIES AND STRUCTURES IS NOT NECESSARILY SHOWN ON THE CONTRACT DRAWINGS, AND WHERE SHOWN, THE ACCURACY OF THE POSITION OF SUCH UTILITIES AND STRUCTURES IS NOT GUARANTEED. BEFORE STARTING WORK, DETERMINE THE EXACT LOCATION OF ALL SUCH UTILITIES AND STRUCTURES AND ASSUME ALL LIABILITY FOR DAMAGE TO THEM.

REV	REVISION DESCRIPTION	DATE	BY	APPD
1	ISSUED FOR SITE PLAN APPROVAL	09/11/22	SAB	BMT

SCALE
 0 1m 2m 4m
 HORIZONTAL 1:100

DESIGNED BY
 REVIEWED BY

DEVELOPER
MCCORMICK PARK DEVELOPMENTS
 1600 LAPERRIERE AVENUE, SUITE 205
 OTTAWA, ON. K1M 2H9
 613.421.1515

exp Services Inc.
 1-813-688-1899 | +1-613-225-7330
 3625 Carleton Place, Unit 100
 Ottawa, ON K2B 8K6
 Canada
 www.exp.com

BASEPLAN: SAB
 DESIGN: BMT
 CHECKED: BMT
 CAD: SAB
 PROJECT MANAGER: BMT
 APPROVED: BMT

PROJECT
266-268 CARRUTHERS
177-179 ARMSTRONG STREET
 OTTAWA, ONTARIO.

TITLE
STORM DRAINAGE PLAN

PROJECT No.
 OTT-22014656-AG

SURVEY
 FWW/FSD

DATE
 JUNE 2022

DRAWING No.
C400