


**LEGEND**

DRAINAGE AREA: X, XXX, 0.XX

AREA (sq.m)

5 YEAR RUNOFF COEFFICIENT

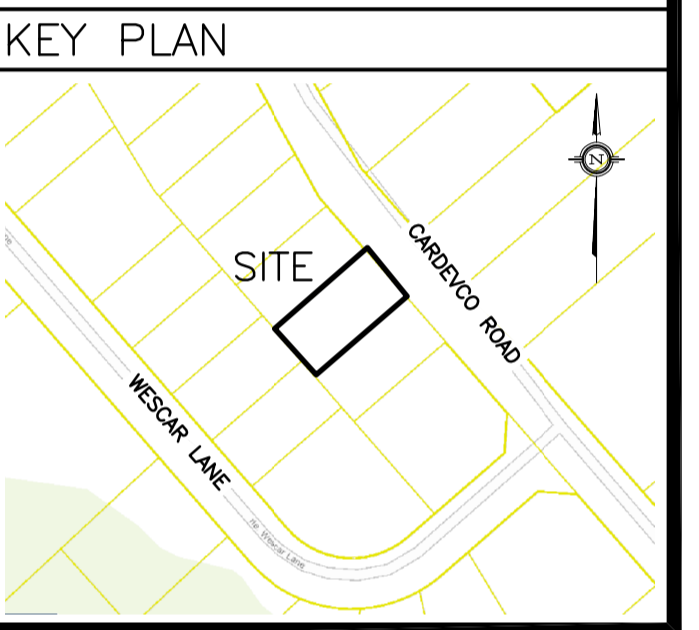

No.	DATE	REVISION
2	NOV 24-22	ISSUED FOR APPROVAL
1	NOV 15-22	ISSUED FOR COORDINATION

**D. B. GRAY ENGINEERING INC.**  
 Stormwater Management - Grading & Drainage - Storm & Sanitary Sewers - Watermain  
 700 Long Point Circle 613-425-8044  
 Ottawa, Ontario d.gray@dbgrayengineering.com

Project  
**PROPOSED ADDITION**  
**135 CARDEVCO ROAD**  
 OTTAWA, ONTARIO

Drawing Title  
**PRE & POST DEVELOPMENT DRAINAGE PLAN**

Engineer's Seal: **D.B. GRAY**, 17016502, NOV 24-22, PROVINCE OF ONTARIO

NOT VALID UNLESS SIGNED & DATED

Drawn: D.B.G.  
 H. Scale: 1:200  
 V. Scale:  
 Date: NOV 15-22  
 Job No.: 21081

Drawing No.: **C-4 of 4**