

ZONING BY-LAW 2008-250

REQUIRED

GRADE (GEODETIC ELEVATION)	62.50m
BUILDING HEIGHT - 12 STOREYS	39.5m
BUILDING HEIGHT - AMENITY / MECHANICAL	43.5m
FRONT YARD SETBACK	0.8m
REAR YARD SETBACK	2.7m
CORNER YARD SETBACK	1.8m & 1.9m
TRANSPARENT GLAZING (GROUND FLOOR FACADE)	0.5%
RESIDENTIAL PARKING PER UNIT (AFTER 12 UNITS)	0.05
VISITOR PARKING PER UNIT (AFTER 12 UNITS)	0.1
COMMERCIAL PARKING	1.25 per 100m ² OF GFA
BICYCLE PARKING PER UNIT	1.0
COMMERCIAL BICYCLE PARKING	1.0 per 250m ² OF GFA
AMENITY AREA - PER UNIT	6.0 sq. m
MINIMUM DRIVEWAY WIDTH	3.0m

SITE PLAN SYMBOLS

- UNIT PAVERS ON CITY BOULEVARD
- PROPOSED CONCRETE SURFACE
- UNIT PAVER SURFACE
- PRIVATE WALKWAYS
- SOFT LANDSCAPING
- BIKE RACK
- TWO WAY VEHICLE CIRCULATION
- MAIN ENTRANCE
- UNIT BALCONY DOOR / FIRE EXIT
- PROPERTY LINE
- ZONING SETBACKS
- EXISTING TREE TO BE REMOVED

- DRAWING NOTES**
- PROPERTY LINE
 - BUILDING SETBACKS AT GRADE - SEE SCHEDULE
 - CORNER SITE TRIANGLE, LOW SHRUBS ONLY
 - HARD SURFACE PAVING, SEE LANDSCAPE PLAN
 - CONTINUOUS DEPRESSED SIDEWALK THROUGH DRIVE
 - 1.8m WIDE CITY SIDEWALK AND STREET CURB
 - SOFT LANDSCAPING, SEE LANDSCAPE PLAN
 - 6.0m WIDE GARAGE ENTRY RAMP WITH TRENCH DRAIN
 - EXISTING FIRE HYDRANT
 - OUTLINE OF PRIVATE TERRACE ABOVE
 - EXISTING TREE TO BE REMOVED
 - OUTLINE OF UPPER FLOORS
 - EXISTING BUILDING TO BE REMOVED
 - EXISTING UTILITY POLE TO BE REMOVED
 - 1200mm HT. BLACK METAL PICKET FENCE
 - OUTLINE OF AMENITY / MECHANICAL LEVEL
 - PROPOSED SERVICES
 - GAS EQUIPMENT LOCATION
 - EXISTING STREET LIGHT
 - EXISTING UTILITY POLE, RELOCATE AS REQUIRED
 - SIAMSE CONNECTION
 - PRIVATE WALKWAY TO GROUND FLOOR UNIT
 - INTAKE / EXHAUST GRILL
 - SEAT WALL, SEE LANDSCAPE FOR DETAILS
 - BICYCLE PARKING SPACE WITH RACK
 - EXISTING CITY PAVERS, RE-INSTATE AS REQUIRED
 - OUTLINE OF BELOW GRADE PARKING GARAGE
 - GROUND FLOOR CANOPY
 - DEPRESSED CURB AND WALK
 - EXISTING STREET PARKING
 - PROPOSED LIGHTING, SEE ELECTRICAL FOR COMPLETE ELECTRICAL PLAN & TYPE

PROVIDED

12 STOREY BUILDING HEIGHT	39.5m
AMENITY / MECHANICAL LEVEL BUILDING HEIGHT	4.0m
FRONT YARD SETBACK	0.9m
CORNER YARD SETBACK - EAST	2.0m
CORNER YARD SETBACK - WEST	1.8m
REAR YARD SETBACK	2.7m
PARKING - PER UNIT (AFTER 12 UNITS)	0.5
VISITOR PARKING - PER UNIT (AFTER 12 UNITS)	0.1
COMMERCIAL PARKING	1.25 per 100m ² OF GFA
BICYCLE PARKING - PER UNIT	0.5
COMMERCIAL BICYCLE PARKING	1 per 250m ² OF GFA
AMENITY AREA - PER UNIT	6.0 sq. m

PROJECT STATISTICS

GROSS BUILDING FLOOR AREA
(CITY-PLANNING DEFINITION)

BELOW GRADE PARKING LEVEL	0.0 sq. m
GROUND FLOOR	1,349.8 sq. m
2nd FLOOR	1,459.9 sq. m
3rd FLOOR	1,667.4 sq. m
4th FLOOR	1,711.6 sq. m
5th - 7th FLOOR	3 x 1,414.7 sq. m
8th & 9th FLOOR	2 x 1,407.1 sq. m
10th FLOOR	1,100.1 sq. m
11th & 12th FLOOR	2 x 1,063.3 sq. m
MECHANICAL / AMENITY LEVEL	0.0 sq. m
TOTAL AREA ABOVE GRADE	16,765.5 sq. m
	180,462 sq. ft.

UNIT STATISTICS

STUDIO	10
1 BEDROOM UNIT	151
2 BEDROOM UNIT	82
TOWN HOUSE UNIT (2 LEVEL)	9
TOTAL	252
COMMERCIAL UNIT	747.1 sq. m
	8,042 sq. ft.

CAR PARKING

REQUIRED

10% REDUCTION WHEN ALL SPACES ARE BELOW GRADE FOR ZONING SECTION 101 (b) (c) ONLY	
RESIDENCE	- 0.5 PER UNIT (252 UNITS) AFTER 12 UNITS, 10% REDUCTION
VISITOR	- 0.1 PER UNIT (252 UNITS) AFTER 12 UNITS
COMMERCIAL RETAIL	- OVER 500m ² , 1.25 per 100m ²
TOTAL	132

BICYCLE PARKING

REQUIRED

RESIDENCE	- 1.0 PER UNIT (252 UNITS)
COMMERCIAL	- 1 per 250 M ² OF GFA
TOTAL	252

AMENITY AREA

AT GRADE EXTERIOR - PRIVATE YARDS	160.0 sq. m
AT GRADE EXTERIOR - COMMUNAL	450.0 sq. m
GROUND FLOOR INTERIOR - COMMUNAL	45.0 sq. m
AMENITY LEVEL INTERIOR - COMMUNAL	300.0 sq. m
AMENITY LEVEL EXTERIOR - COMMUNAL	250.0 sq. m
5th & 10th FLOOR TERRACE - PRIVATE	620.0 sq. m
BALCONIES (ALL LEVELS) - PRIVATE	600.0 sq. m
TOTAL	2,425.0 sq. m
TOTAL COMMUNAL	1,045.0 sq. m

SITE COVERAGE

BUILDING FOOTPRINT	69.6%	2,030.6 sq. m
DRIVING SURFACE	0.4%	11.4 sq. m
LANDSCAPE AREA	30.0%	875.0 sq. m
TOTAL	100.0%	2,917.0 sq. m

REFUGE REQUIREMENT
(252 UNITS)

GARBAGE	- 0.11 PER UNIT	28 YARDS
RECYCLING GMP	- 0.018 PER UNIT	5 YARDS
RECYCLING FIBER	- 0.038 PER UNIT	10 YARDS
ORGANICS	- 240L PER 50 UNITS	5

IT IS THE RESPONSIBILITY OF THE APPROPRIATE CONTRACTOR TO CHECK AND VERIFY ALL DIMENSIONS ON SITE AND TO REPORT ALL ERRORS AND/OR OMISSIONS TO THE ARCHITECT.

ALL CONTRACTORS MUST COMPLY WITH ALL PERTINENT CODES AND BY-LAWS.

THIS DRAWING MAY NOT BE USED FOR CONSTRUCTION UNTIL SIGNED BY THE ARCHITECT.

DO NOT SCALE DRAWINGS.

COPYRIGHT RESERVED.

NOTATION SYMBOLS:

- INDICATES DRAWING NOTES, LISTED ON EACH SHEET.
- INDICATES ASSEMBLY TYPE; REFER TO TYPICAL ASSEMBLIES SCHEDULED.
- INDICATES WINDOW TYPE; REFER TO WINDOW ELEVATIONS AND DETAILS ON A300 SERIES.
- INDICATES DOOR TYPE; REFER TO DOOR SCHEDULES AND DETAILS ON A300 SERIES.
- DETAIL NUMBER
- TITLE
- SCHEMATIC
- DETAIL REFERENCE PAGE
- DETAIL CROSS REFERENCE PAGE

REVISIONS:

No.	DESCRIPTION	DATE
1	ISSUED FOR SPC ROUND 1 COMMENTS	Dec. 12, 22
2	ISSUED FOR TENDER	Dec. 9, 22
3	ISSUED FOR BUILDING PERMIT	Dec. 2, 22
4	ISSUED FOR CONSULTANT REVIEW	Nov. 25, 22
5	ISSUED FOR LDRP SPC SUBMISSION	Nov. 09, 22
6	ISSUED FOR OWNER / CONSULTANT REVIEW	Oct. 27, 22
7	ISSUED FOR GENERAL UPDATES	Aug. 31, 22
8	ISSUED FOR GENERAL UPDATES	July 19, 22
9	ISSUED FOR SPC APPLICATION	Mar. 16, 22
10	ISSUED FOR OWNER / CONSULTANT REVIEW	Dec. 09, 21
11	ISSUED AS PER CITY COMMENTS	June 16, 21
12	ISSUED FOR ZA & OPA ROUND 1 COMMENT	Apr. 07, 21
13	ISSUED FOR ZA & OPA APPLICATION	Nov. 16, 20
14	ISSUED FOR OWNER / CONSULTANT REVIEW	Nov. 05, 20
15	ISSUED FOR ZA & OPA (DRAFT)	Sept. 16, 20
16	ISSUED FOR REVISED DESIGN	Aug. 20, 20
17	ISSUED FOR DESIGN CONCEPT	Mar. 17, 20

PROVIDED

INTERIOR	227
EXTERIOR	27

ARCHITECT SEAL: **RODERICK LAHEY** ARCHITECT INC. LICENSE #4375

SEAL DATE: STAMP DATE

CLIENT: **ML Wellington Realty Investments Inc.**

ARCHITECT: **RODERICK LAHEY ARCHITECT INC.**

56 Beech Street, Ottawa, Ontario K1S 3J6
1.613.724.9932 1.613.724.1209 www.rodericklahey.ca

PROJECT TITLE: **THE SOMERWELL**

979 to 961 WELLINGTON STREET
26 to 40 ARMSTRONG STREET
OTTAWA ONTARIO

SHEET TITLE: **SITE PLAN**


DRAWN: **RV**

CHECKED: **S.S.**

SCALE: 1:125

PROJECT No: **1945**

SHEET No: **SP-1**

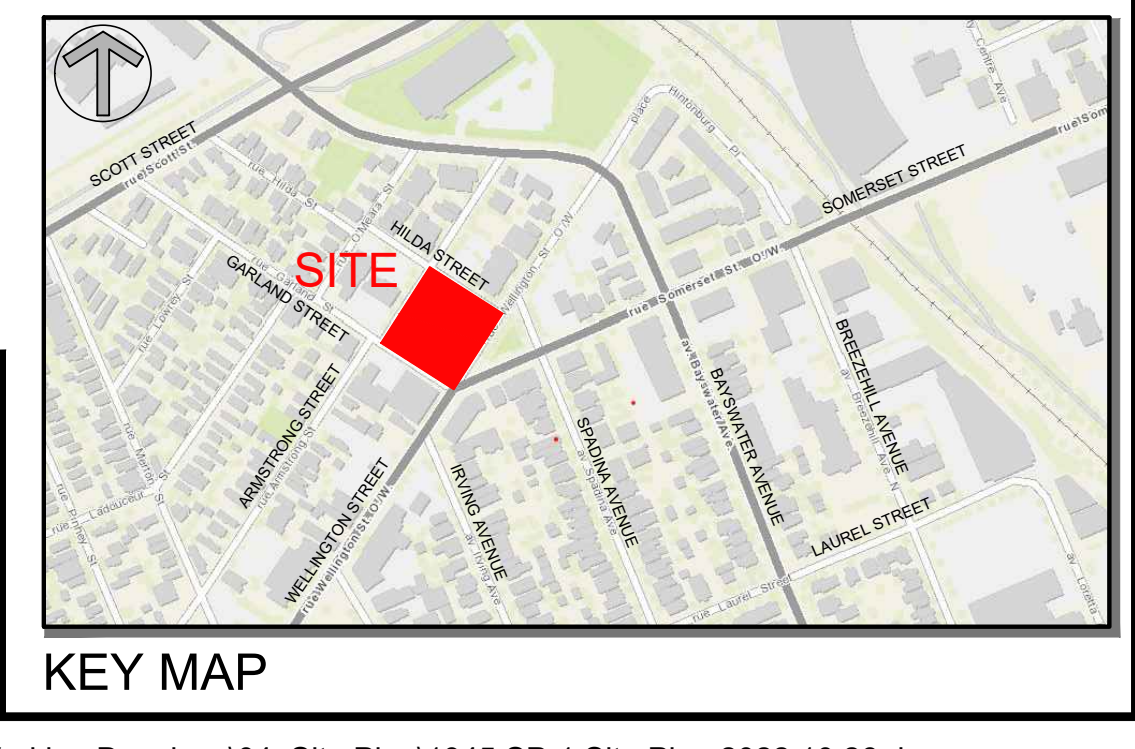

LEGAL DESCRIPTION

TOPOGRAPHICAL PLAN OF SURVEY OF LOTS 7, 8, 9 and 10 PART OF LOT 11 REGISTERED PLAN 89 CITY OF OTTAWA

Surveyed by Annis, O'Sullivan, Vollebek Ltd.

SURVEYOR

Annis O'Sullivan Vollebek Ltd.
Ontario Land Surveyors
14 Concourse Gate, Suite 500,
Nepean, Ontario K2E 7S6
Tel: (613) 727-0850
Fax: (613) 727-1079
Email: EdH@aovltd.com

GEOTECHNICAL ENGINEER

Paterson Group
154 Colonnade Road South
Ottawa, Ontario
K2E 7J5
Tel: 613.226-7381
Email: MD'Arcy@Patersongroup.ca

TRANSPORTATION ENGINEER

CGH TRANSPORTATION INC.
24 Mont Royal West Office 801
13 Markham Avenue
Ottawa, ON
K2G 3Z1
Tel: (514) 889-5442
Tel: (343) 999-9117
Email: Christopher.Gordon@CGHtransportation.com

LANDSCAPE ARCHITECT

Projet Paysage
24 Mont Royal West Office 801
13 Markham Avenue
Ottawa, Quebec, H2T 2S
Montreal, Quebec, H2T 2S
Tel: (514) 889-5442
Cell: (514) _____
Email: sgallant@projetpaysage.com

CIVIL ENGINEER

IBI Group
333 Preston Street, Suite 400
Ottawa, ON K1S 5N4
Tel: (613) 225-1311
Tel: (613) 730-5709
Fax: (613) 225-9868
E-Mail: jmoftat@IBIgroup.com

URBAN PLANNER

FoTenn Consultants Inc.
396 Cooper Street, Suite 300,
Ottawa, ON Canada, K2P 2H7
Tel: (613) 730-5709
Tel: (613) 686-6319
Fax: (613) 730-1136
E-Mail: bolduc@fotenn.com

PROJECT DEVELOPER

ML Wellington Realty Investments Inc.
396 Cooper Street, Suite 300,
Ottawa, ON, K1Z 5G2
Tel: (613) 686-6319
E-Mail: mflanigan@mldevco.ca
E-Mail: psmale@mldevco.ca