



REFER TO NOTES
ON DRAWING C-4

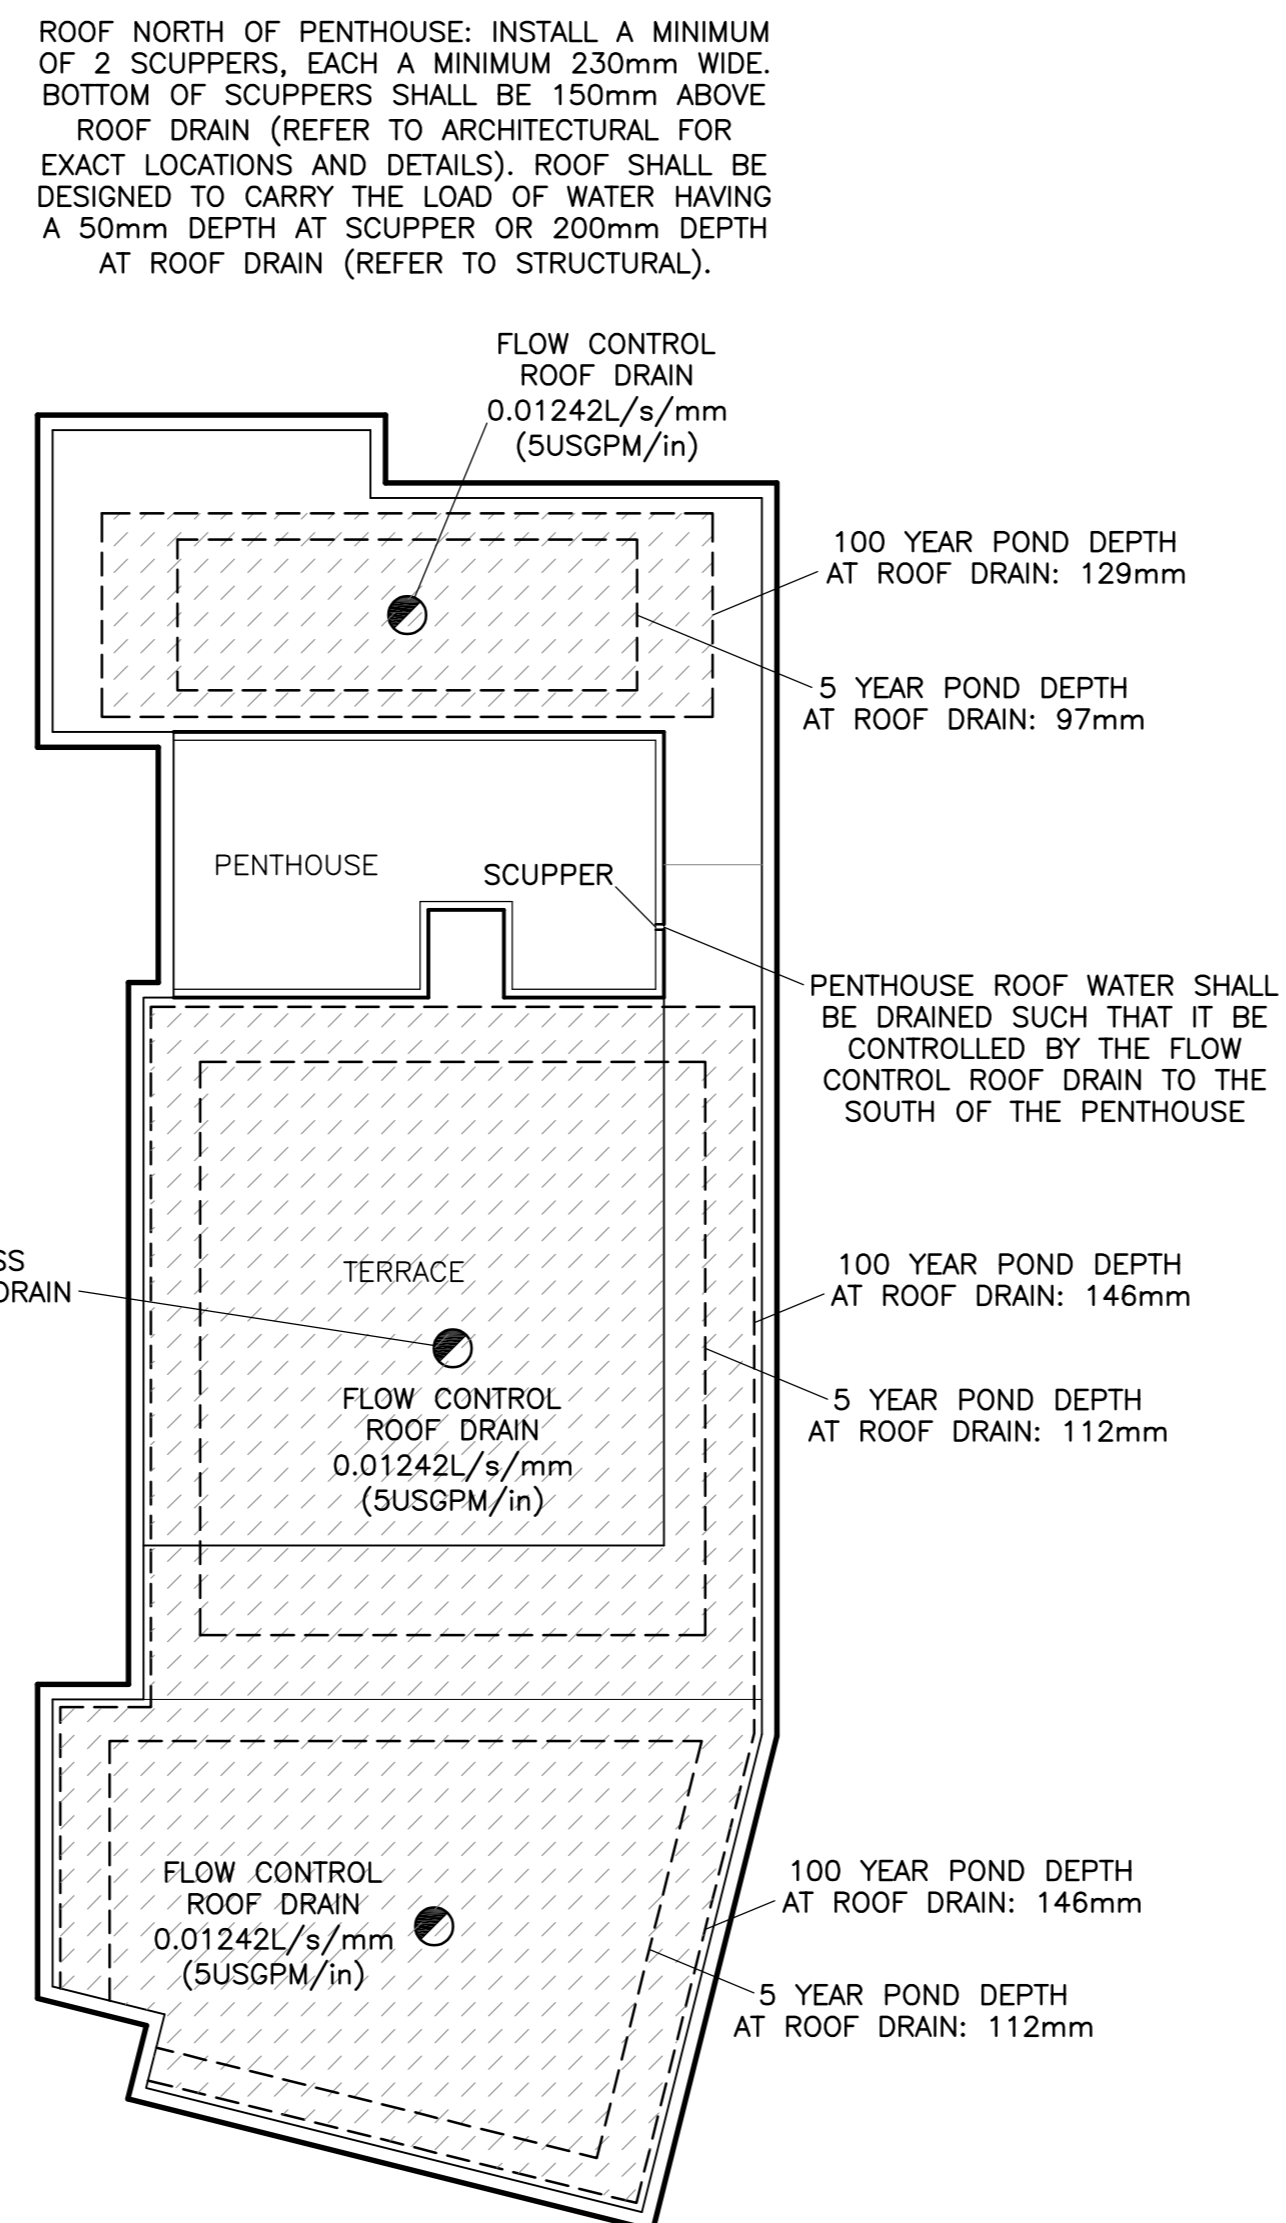


ROOF PLAN

REFER TO NOTES
ON DRAWING C-4

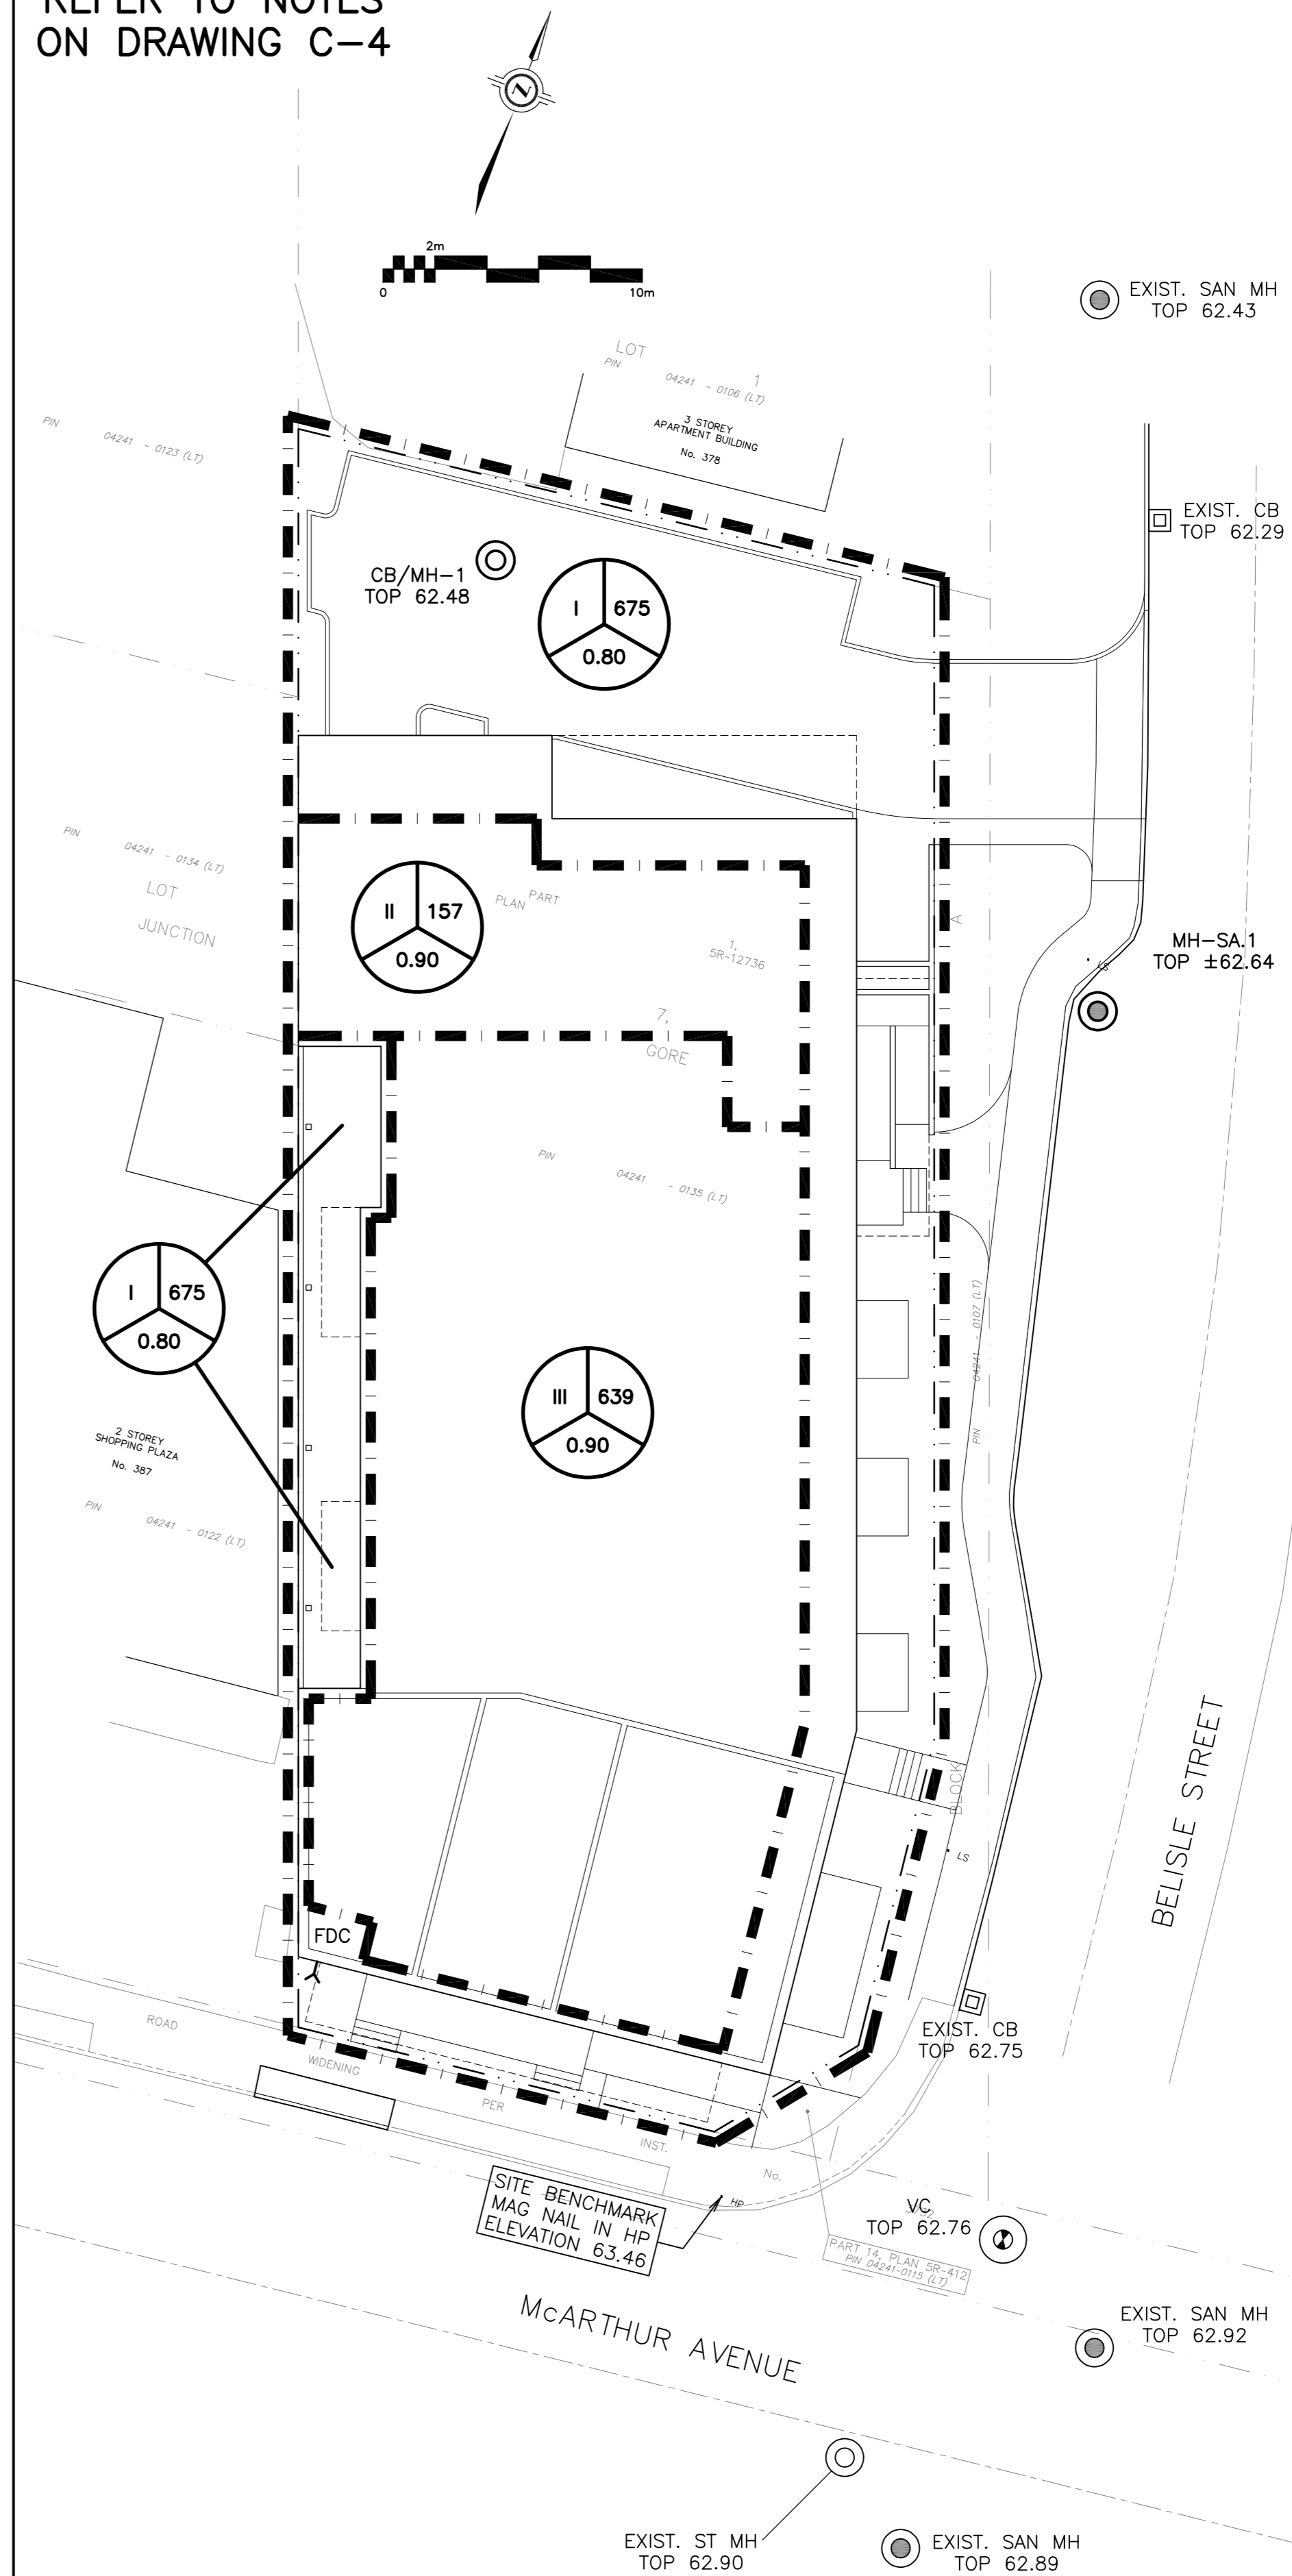


DRAINAGE PLAN

LEGEND

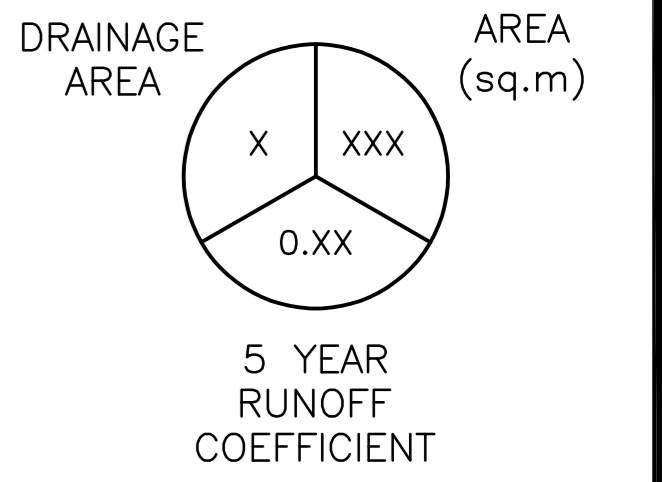

KEY PLAN

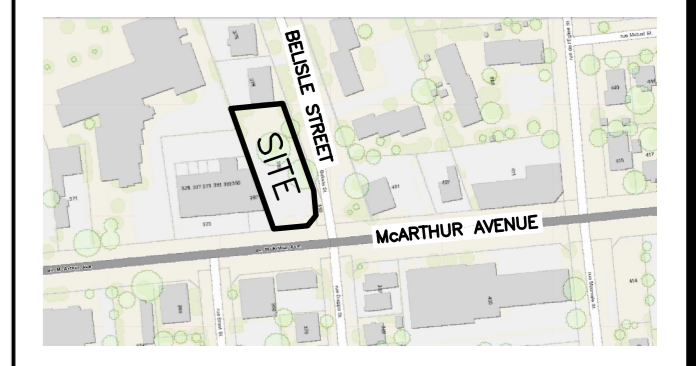


No.	DATE	REVISION
3	SEP 22-22	RE-ISSUED FOR APPROVAL
2	JUN 15-22	ISSUED FOR APPROVAL
1	APR 27-22	ISSUED FOR COORDINATION

D. B. GRAY ENGINEERING INC.
Stormwater Management - Grading & Drainage - Storm & Sanitary Sewers - Watermain
700 Long Point Circle 613-425-8044
Ottawa, Ontario d.gray@dbgrayengineering.com

Project
**PROPOSED 6-STOREY MIXED-USE BUILDING
393 MCARTHUR AVENUE
OTTAWA, ONTARIO**

Drawing Title
ROOF PLAN AND DRAINAGE PLAN

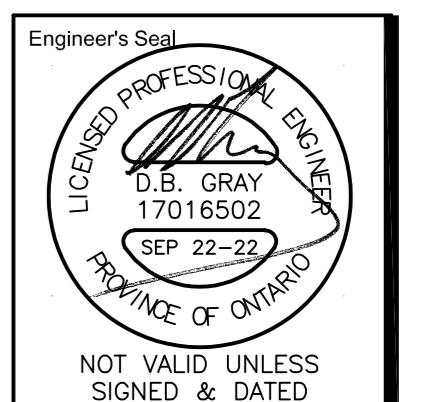

Drawn	D.B.G.
H. Scale	1:200
V. Scale	
Date	APR 27-22
Job No.	21111

Drawing No.
**C-3
of 4**

NOT VALID UNLESS SIGNED & DATED