


### LEGEND

CB	CATCH-BASIN
MH	STORM MANHOLE
CB/MH	CATCH-BASIN/MANHOLE
MH	SANITARY MANHOLE
VC	VALVE CHAMBER
VB	VALVE & VALVE BOX
FH	FIRE HYDRANT
FDC	FIRE DEPARTMENT CONNECTION
SAN	SANITARY SEWER
ST	STORM SEWER
WS/WM	WATER SERVICE/WATERMAIN
SPL	SPRINGLINE OF PIPE
INV	INVERT OF PIPE
M	WATER METER
R	REMOTE WATER METER
FFL	FINISHED FLOOR ELEVATION
USF	UNDERSIDE OF FOOTING
- - -	PROPERTY LINE
±99.99	EXISTING GRADE ELEVATION
C.R.Z.	CRITICAL ROOT ZONE

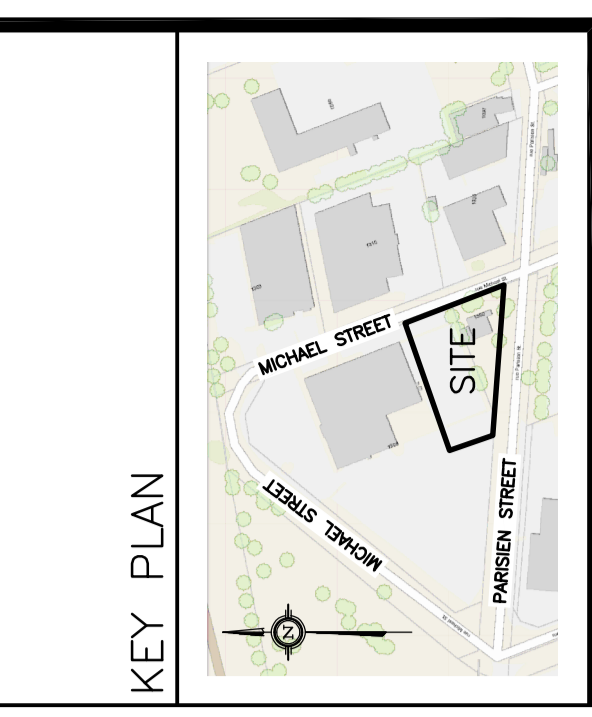

No.	DATE	REVISION
4	JAN 25-23	RE-ISSUED FOR APPROVAL
3	JUL 28-22	RE-ISSUED FOR APPROVAL
2	JAN 12-22	ISSUED FOR APPROVAL
1	JAN 11-22	ISSUED FOR COORDINATION

**D. B. GRAY ENGINEERING INC.**  
 Professional Engineers  
 700 Long Point Circle  
 Ottawa, Ontario  
 613-425-8044  
 d.gray@dbgrayengineering.com

**PROPOSED 2 STOREY VOLVO DEALERSHIP**  
 1328 MICHAEL STREET  
 OTTAWA, ONTARIO


EXISTING DRAINAGE PLAN AND EXISTING CONDITIONS, REMOVALS & DECOMMISSIONING

Engineer's Seal  
 D.B. GRAY  
 PROFESSIONAL ENGINEER  
 17016502  
 JAN 25-23  
 BOARD OF ENGINEERS  
 OF ONTARIO

Drawn: D.B.G.  
 H. Scale: 1:200  
 V. Scale: NOV 2-21  
 Date: NOV 2-21  
 Job No.: 21014

Drawing No.: **C-2**  
 of **8**

NOT VALID UNLESS SIGNED & DATED

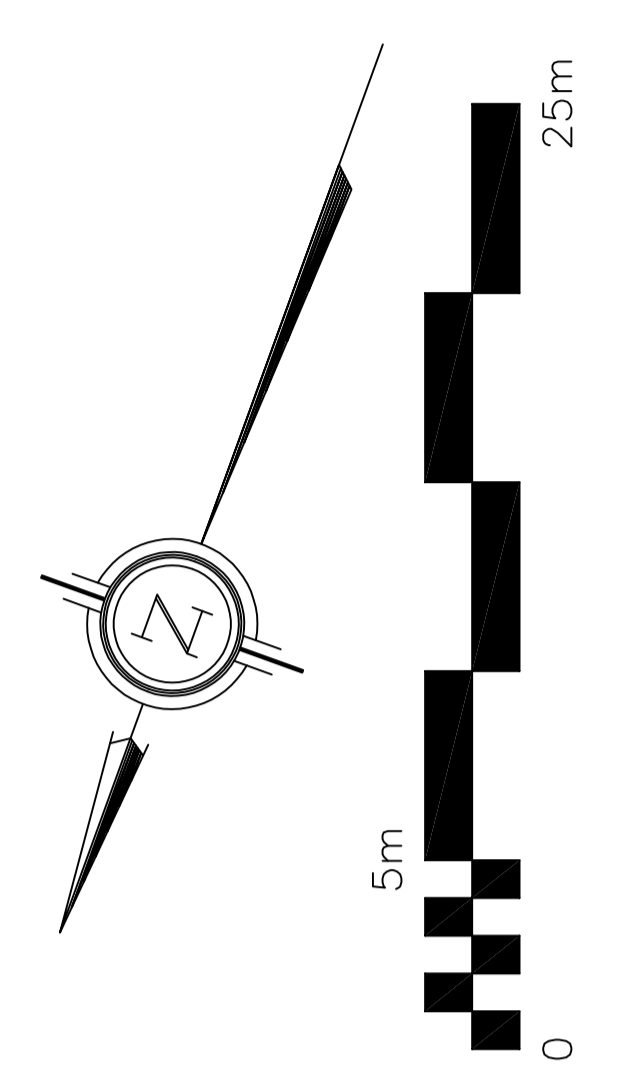

REFER TO NOTES, DETAILS & SCHEDULES ON DRAWINGS C-4 & C-5