


LEGEND

CB	CATCH-BASIN
MH	STORM MANHOLE
CB/MH	CATCH-BASIN/MANHOLE
MH	SANITARY MANHOLE
VC	VALVE CHAMBER
VB	VALVE & VALVE BOX
FH	FIRE HYDRANT
FDC	FIRE DEPARTMENT CONNECTION
SAN	SANITARY SEWER
ST	STORM SEWER
WS/WM	WATER SERVICE/WATERMAIN
SPL	SPRINGLINE OF PIPE
INV	INVERT OF PIPE
M	WATER METER
R	REMOTE WATER METER
FFL	FINISHED FLOOR ELEVATION
USF	UNDERSIDE OF FOOTING
- - -	PROPERTY LINE
---	EXISTING GRADE ELEVATION
---	CRITICAL ROOT ZONE

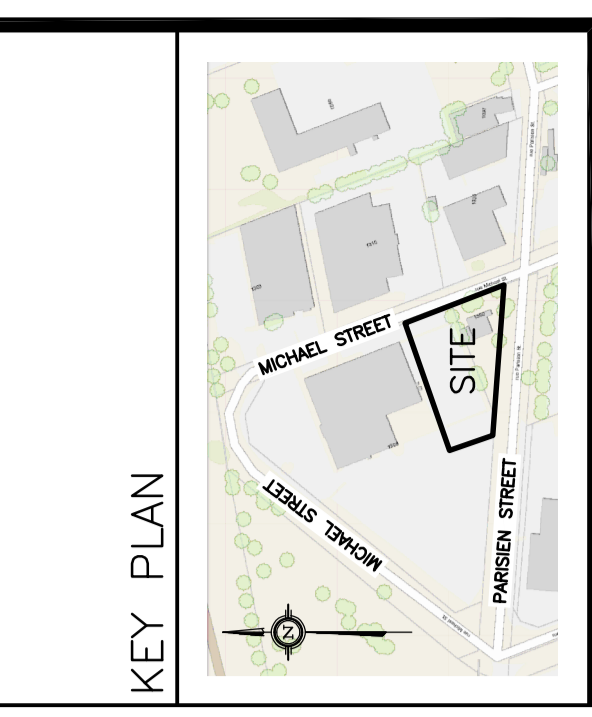

No.	DATE	REVISION
1	JAN 25-23	ISSUED FOR APPROVAL

D. B. GRAY ENGINEERING INC.
 Professional Engineers
 700 Long Point Circle
 Ottawa, Ontario
 613-425-8044
 d.gray@dbgrayengineering.com

**PROPOSED 2 STOREY
 VOLVO DEALERSHIP
 1328 MICHAEL STREET
 OTTAWA, ONTARIO**


**PRE-DEVELOPMENT
 DRAINAGE PLAN**

Engineer's Seal
 PROFESSIONAL ENGINEER
 D. B. GRAY
 17016502
 JAN 25-23
 BOARD OF ENGINEERS
 OF ONTARIO

Drawn: D.B.G.
 H. Scale: 1:200
 V. Scale: 1:20
 Date: DEC 7-22
 Job No.: 21012

Drawing No.: **C-8**
 of **8**

NOT VALID UNLESS
 SIGNED & DATED

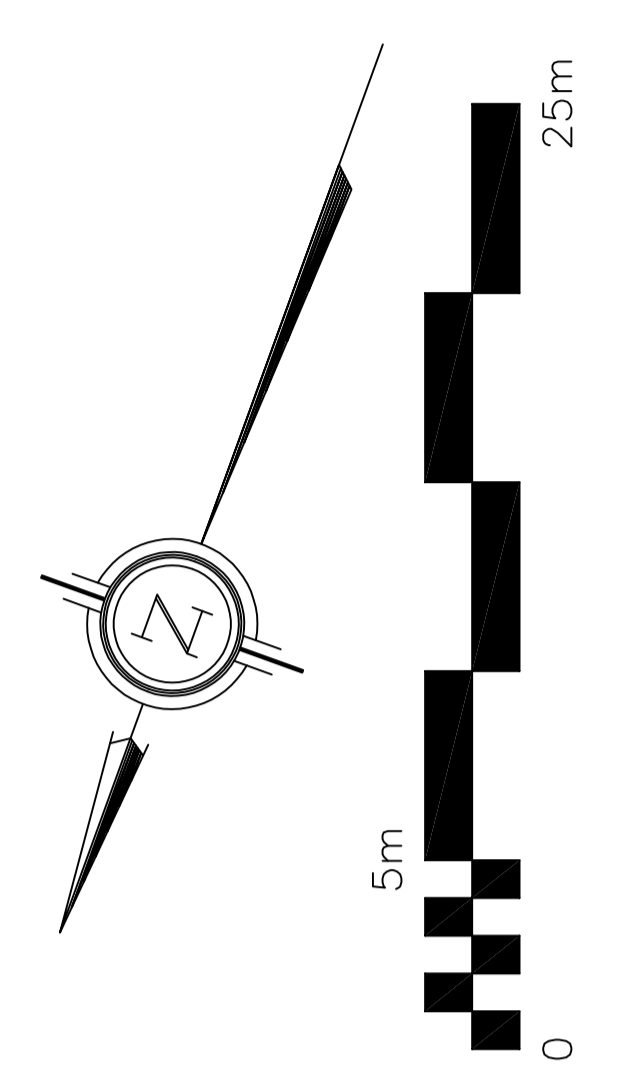

**REFER TO NOTES, DETAILS & C-5
 SCHEDULES ON DRAWINGS C-4 & C-5**