


DRAWING INFORMATION

- ① SURFACE REFLECTANCES:
BUILDING: 0.5
GROUND: 0.2
- ② LUMINAIRE MOUNTING HEIGHTS
INDICATED IN DRAWINGS BY MH
WALL SCONCE - M/H INDICATED IS
DISTANCE FROM FLOOR TO CENTER
OF FIXTURE
SUSPENDED FIXTURE - M/H INDICATED
IS DISTANCE FROM FLOOR TO U/S OF
FIXTURE
- ③ REFER TO ARCHITECTURAL DRAWINGS
FOR FURTHER CEILING INFORMATION
- ④ CALCULATION POINT PLANE INDICATED
IN SCHEDULE

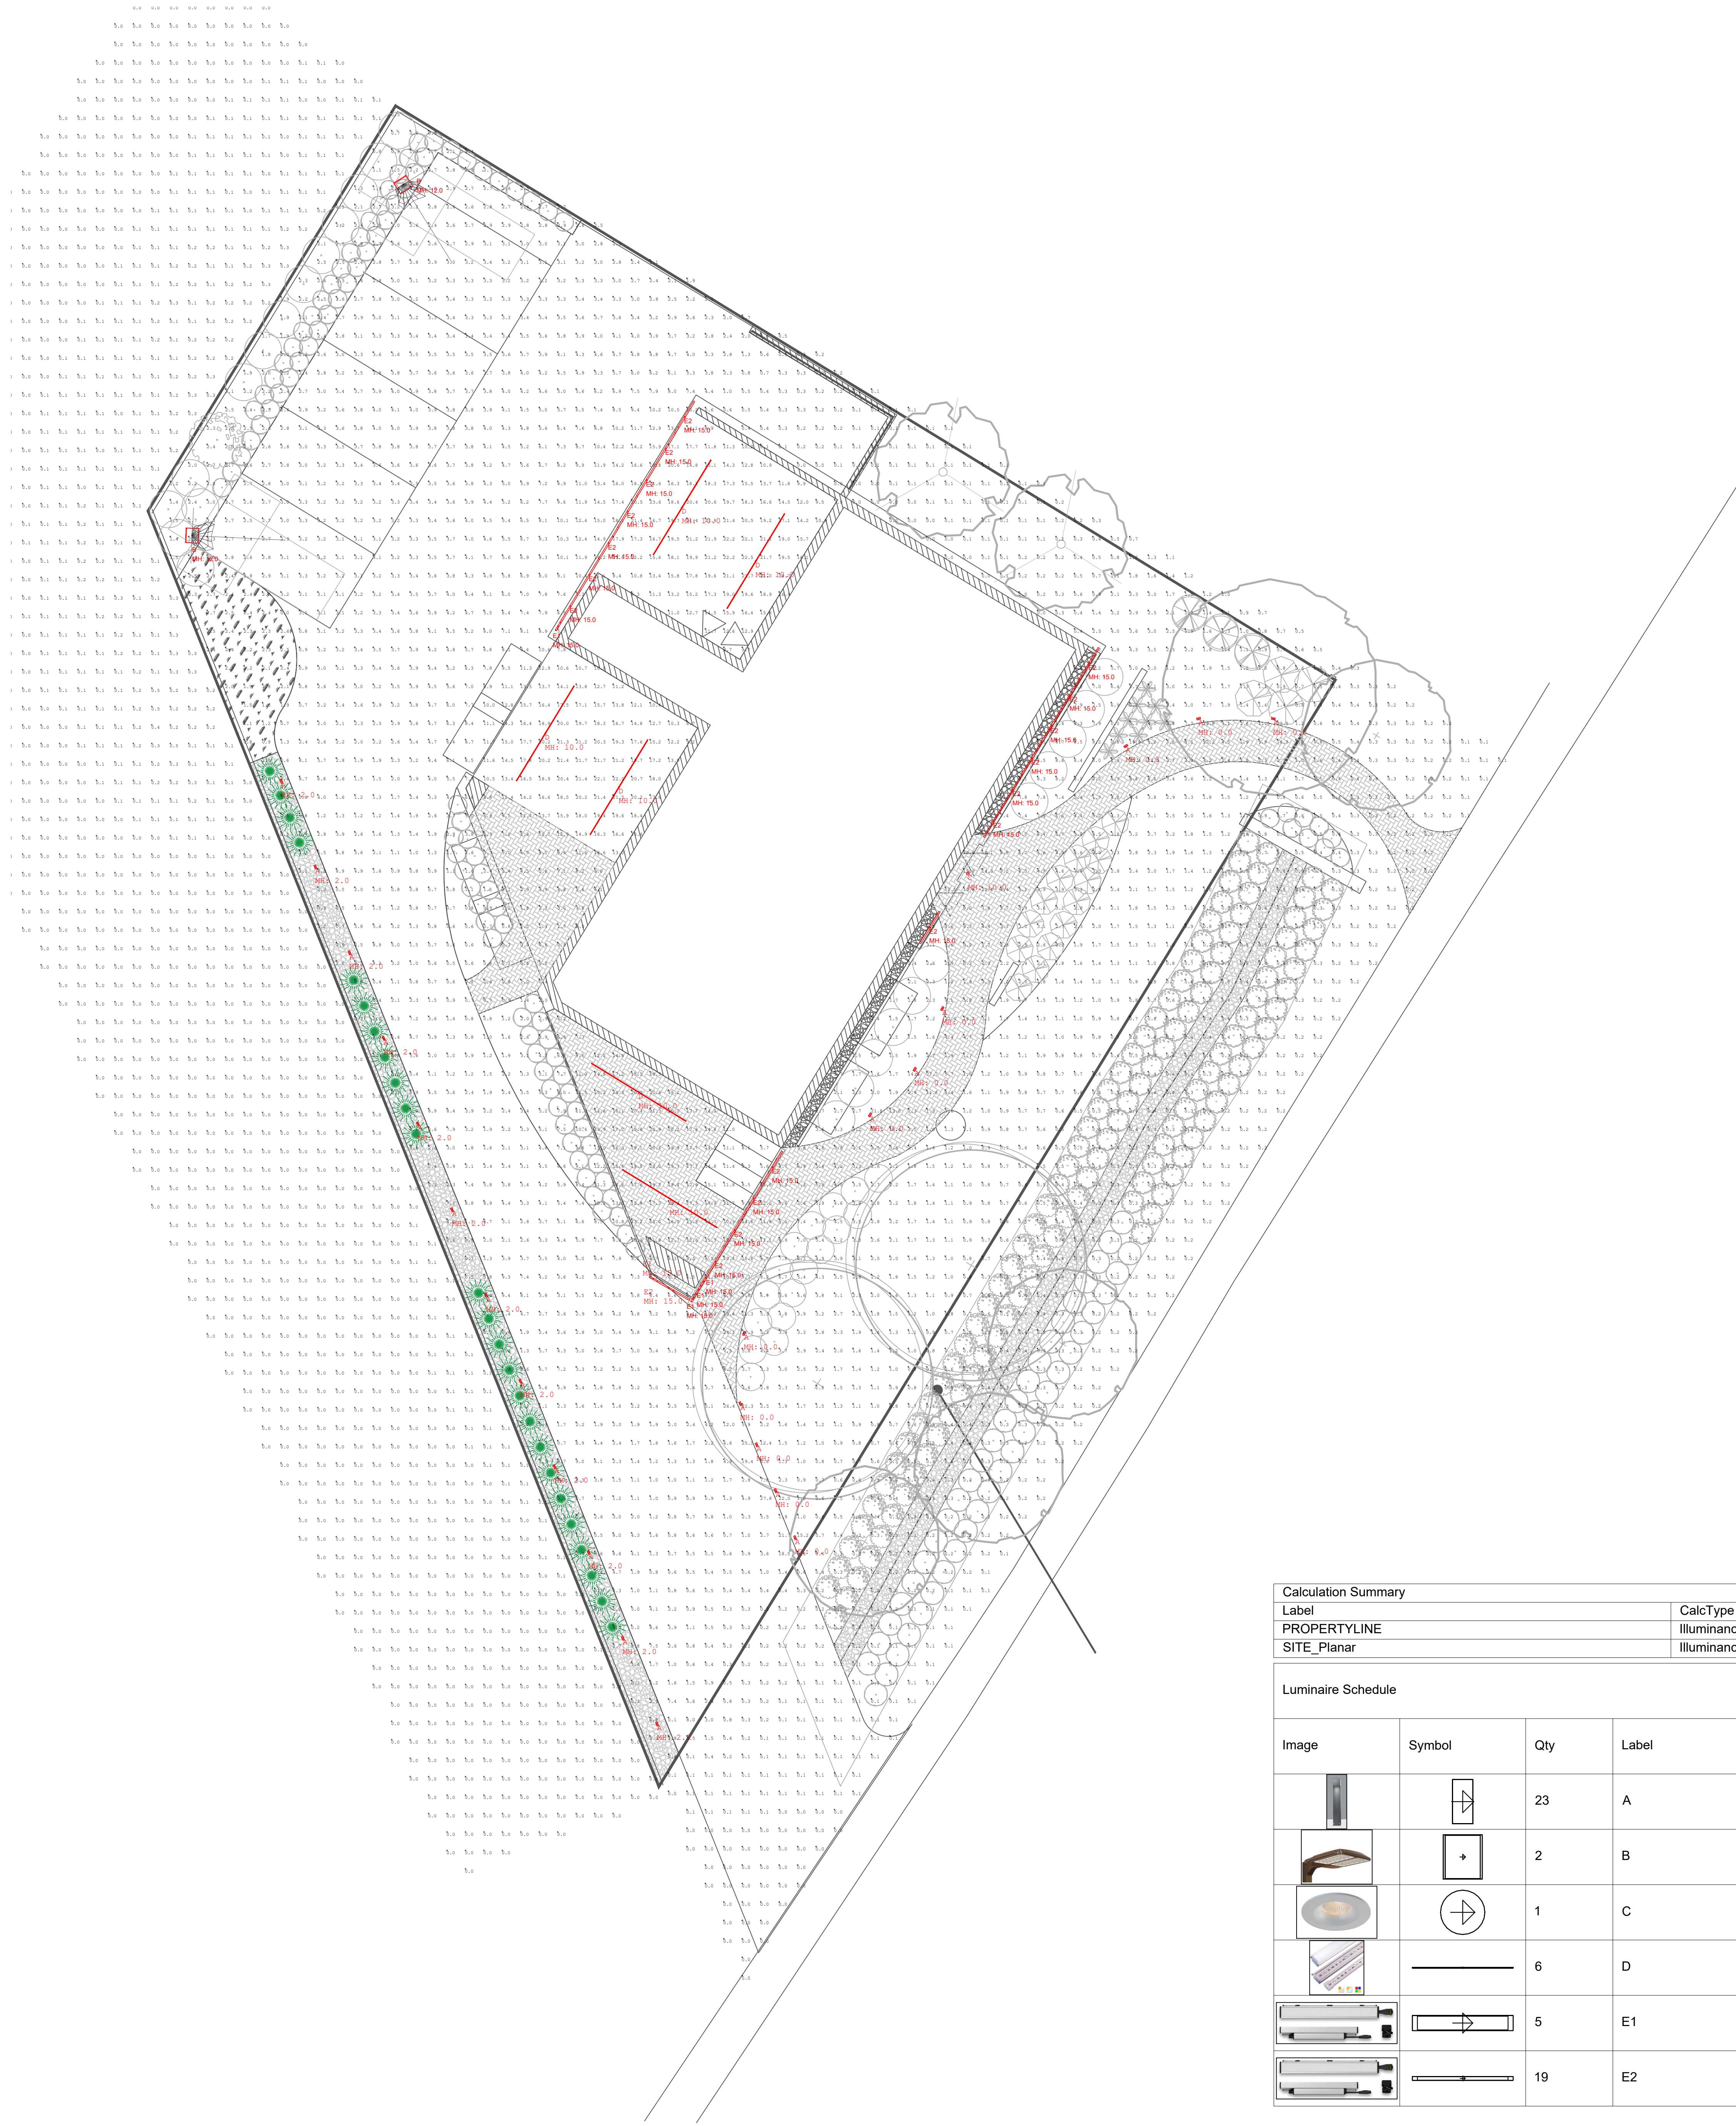


| Calculation Summary | | | | | | | |
|---------------------|-------------|-------|------|------|-----|---------|---------|
| Label | CalcType | Units | Avg | Max | Min | Avg/Min | Max/Min |
| PROPERTYLINE | ILLUMINANCE | Fc | 0.03 | 0.5 | 0.0 | N.A. | N.A. |
| SITE_Planar | ILLUMINANCE | Fc | 3.82 | 30.9 | 0.0 | N.A. | N.A. |

| Luminaire Schedule | | | | | | | | | | |
|--------------------|--------|-----|-------|--------------|---|-----------|------------|-------------|-------|----------|
| Image | Symbol | Qty | Label | Manufacturer | Description | No. Lamps | Lum. Watts | Lumens/Lamp | LLF | Notes |
| | | 23 | A | ERCO | 33268000_V09 KUBUS BOLLARD - 30x-DEEP BEAM | 1 | 32 | N.A. | 0.900 | BOLLARD |
| | | 2 | B | CREE | OSQM-B-4L-30K7-4M-UL-xx-xxx-xxxx w-OSQ-BLSMF | 1 | 30 | N.A. | 0.900 | POLE |
| | | 1 | C | LITELINE | RA35-12F-30K-90WH | 1 | 10.01 | 802 | 0.900 | RECESSED |
| | | 6 | D | NOVAFLEX | NF-LINE2-O-80-120V-3000K-12' + NF-CH-LINE2-C/SOFT-12' | 1 | 56.2 | 5057.729 | 0.900 | SURFACE |
| | | 5 | E1 | ECOSENSE | L50-I-12-06-30-80-MULT-LOL | 1 | 6 | 322.4679 | 0.900 | SURFACE |
| | | 19 | E2 | ECOSENSE | L50-I-48-06-30-80-MULT-LOL | 1 | 24 | 1289.872 | 0.900 | SURFACE |

① POINT BY POINT PHOTOMETRIC CALCULATION
SCALE: 1/2" = 1'

② SCHEDULE AND CALCULATION SUMMARY
SCALE: NTS

ALFA+
PROJECT LEADERS

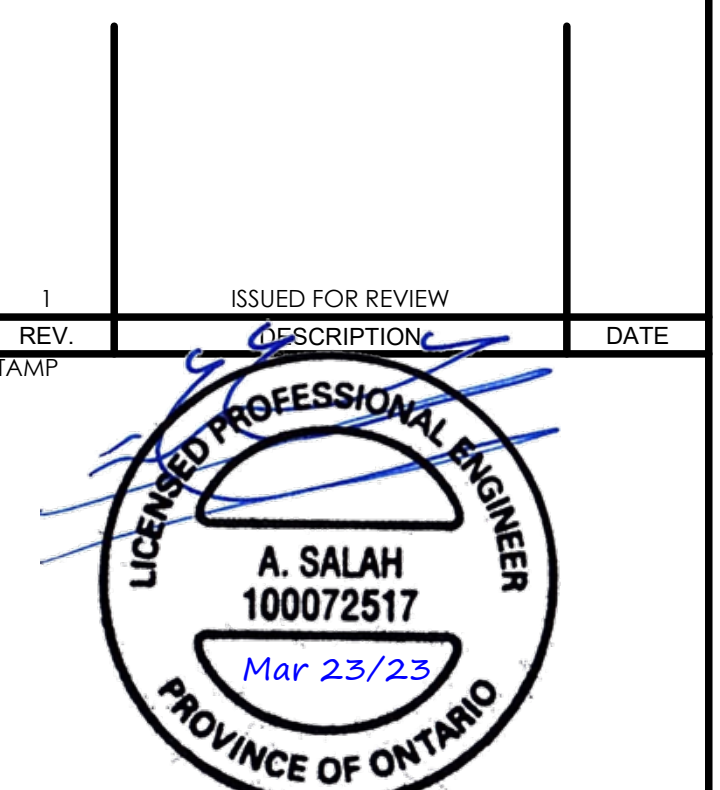

| | |
|----------------|---------------------|
| Project name | 3055 RICHMOND ROAD |
| Project number | PHOTOMETRIC SUMMARY |
| Scale | AS SHOWN |
| Date | 2023.03.23 |
| Project number | 23076 |
| Drawing number | L-02 |

Lighting • Controls • Shades
FLUX
Control the Experience